



HAGERSMITH

ARCHITECTURE | INTERIOR DESIGN
LANDSCAPE ARCHITECTURE

300 S. DAWSON STREET
RALEIGH, NC 27601 | 919.821.5547
www.hagersmith.com

© COPYRIGHT 2023

SEALS



PROJECT

ROOMS TO GO -
PHASE II
EXPANSION

901 Rooms To Go Way
Dunn, NC 28334


CONSULTANTS



BASS | NIXON | KENNEDY
CONSULTING ENGINEERS

ENGINEERING FIRM NUMBER: C-0110

6310 CHAPEL HILL ROAD, SUITE 250
RALEIGH, NC 27607
PHONE: 919.851.4422

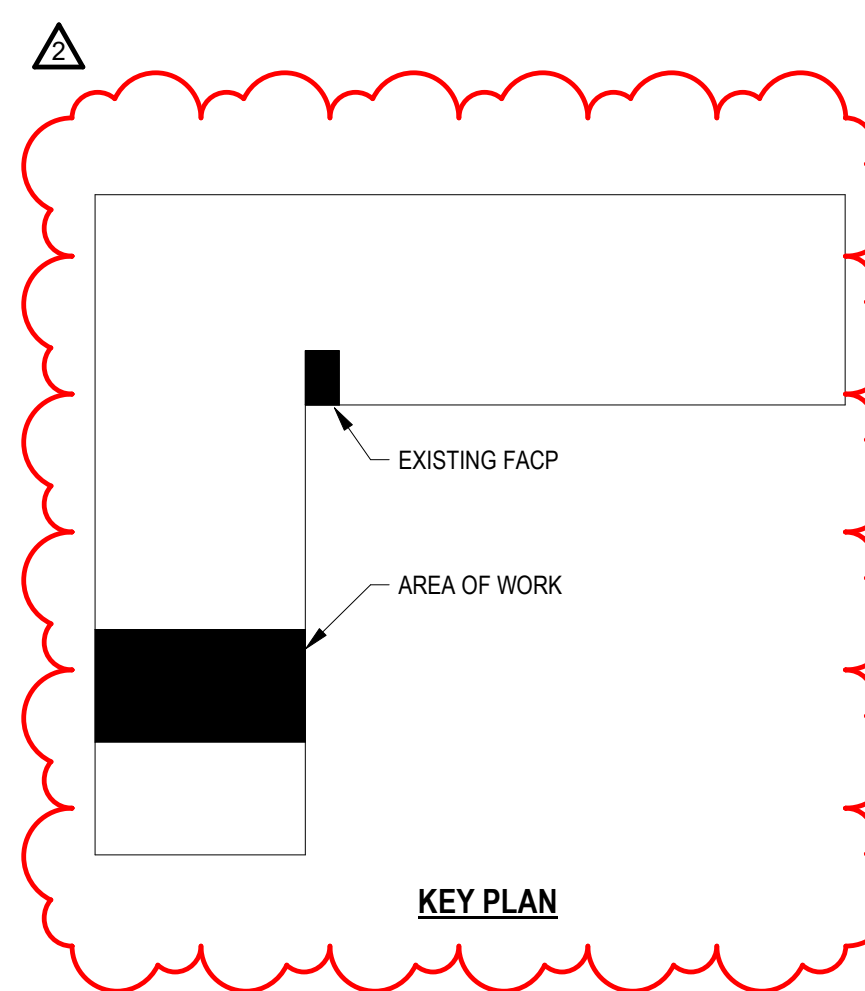

CLEAR



901 Rooms to Go Way
Dunn, NC 28334
(910) 292-3505

DRAWING TITLE

PARTIAL FLOOR PLAN NORTH - FIRE
ALARM

REVISIONS

NUMBER	DESCRIPTION	DATE
2	BID ADDENDUM #02	02/16/24

DRAWN BY

AMW

CHECKED BY


PLC

DATE ISSUED

12/18/2023

2 OF 3

FA-101

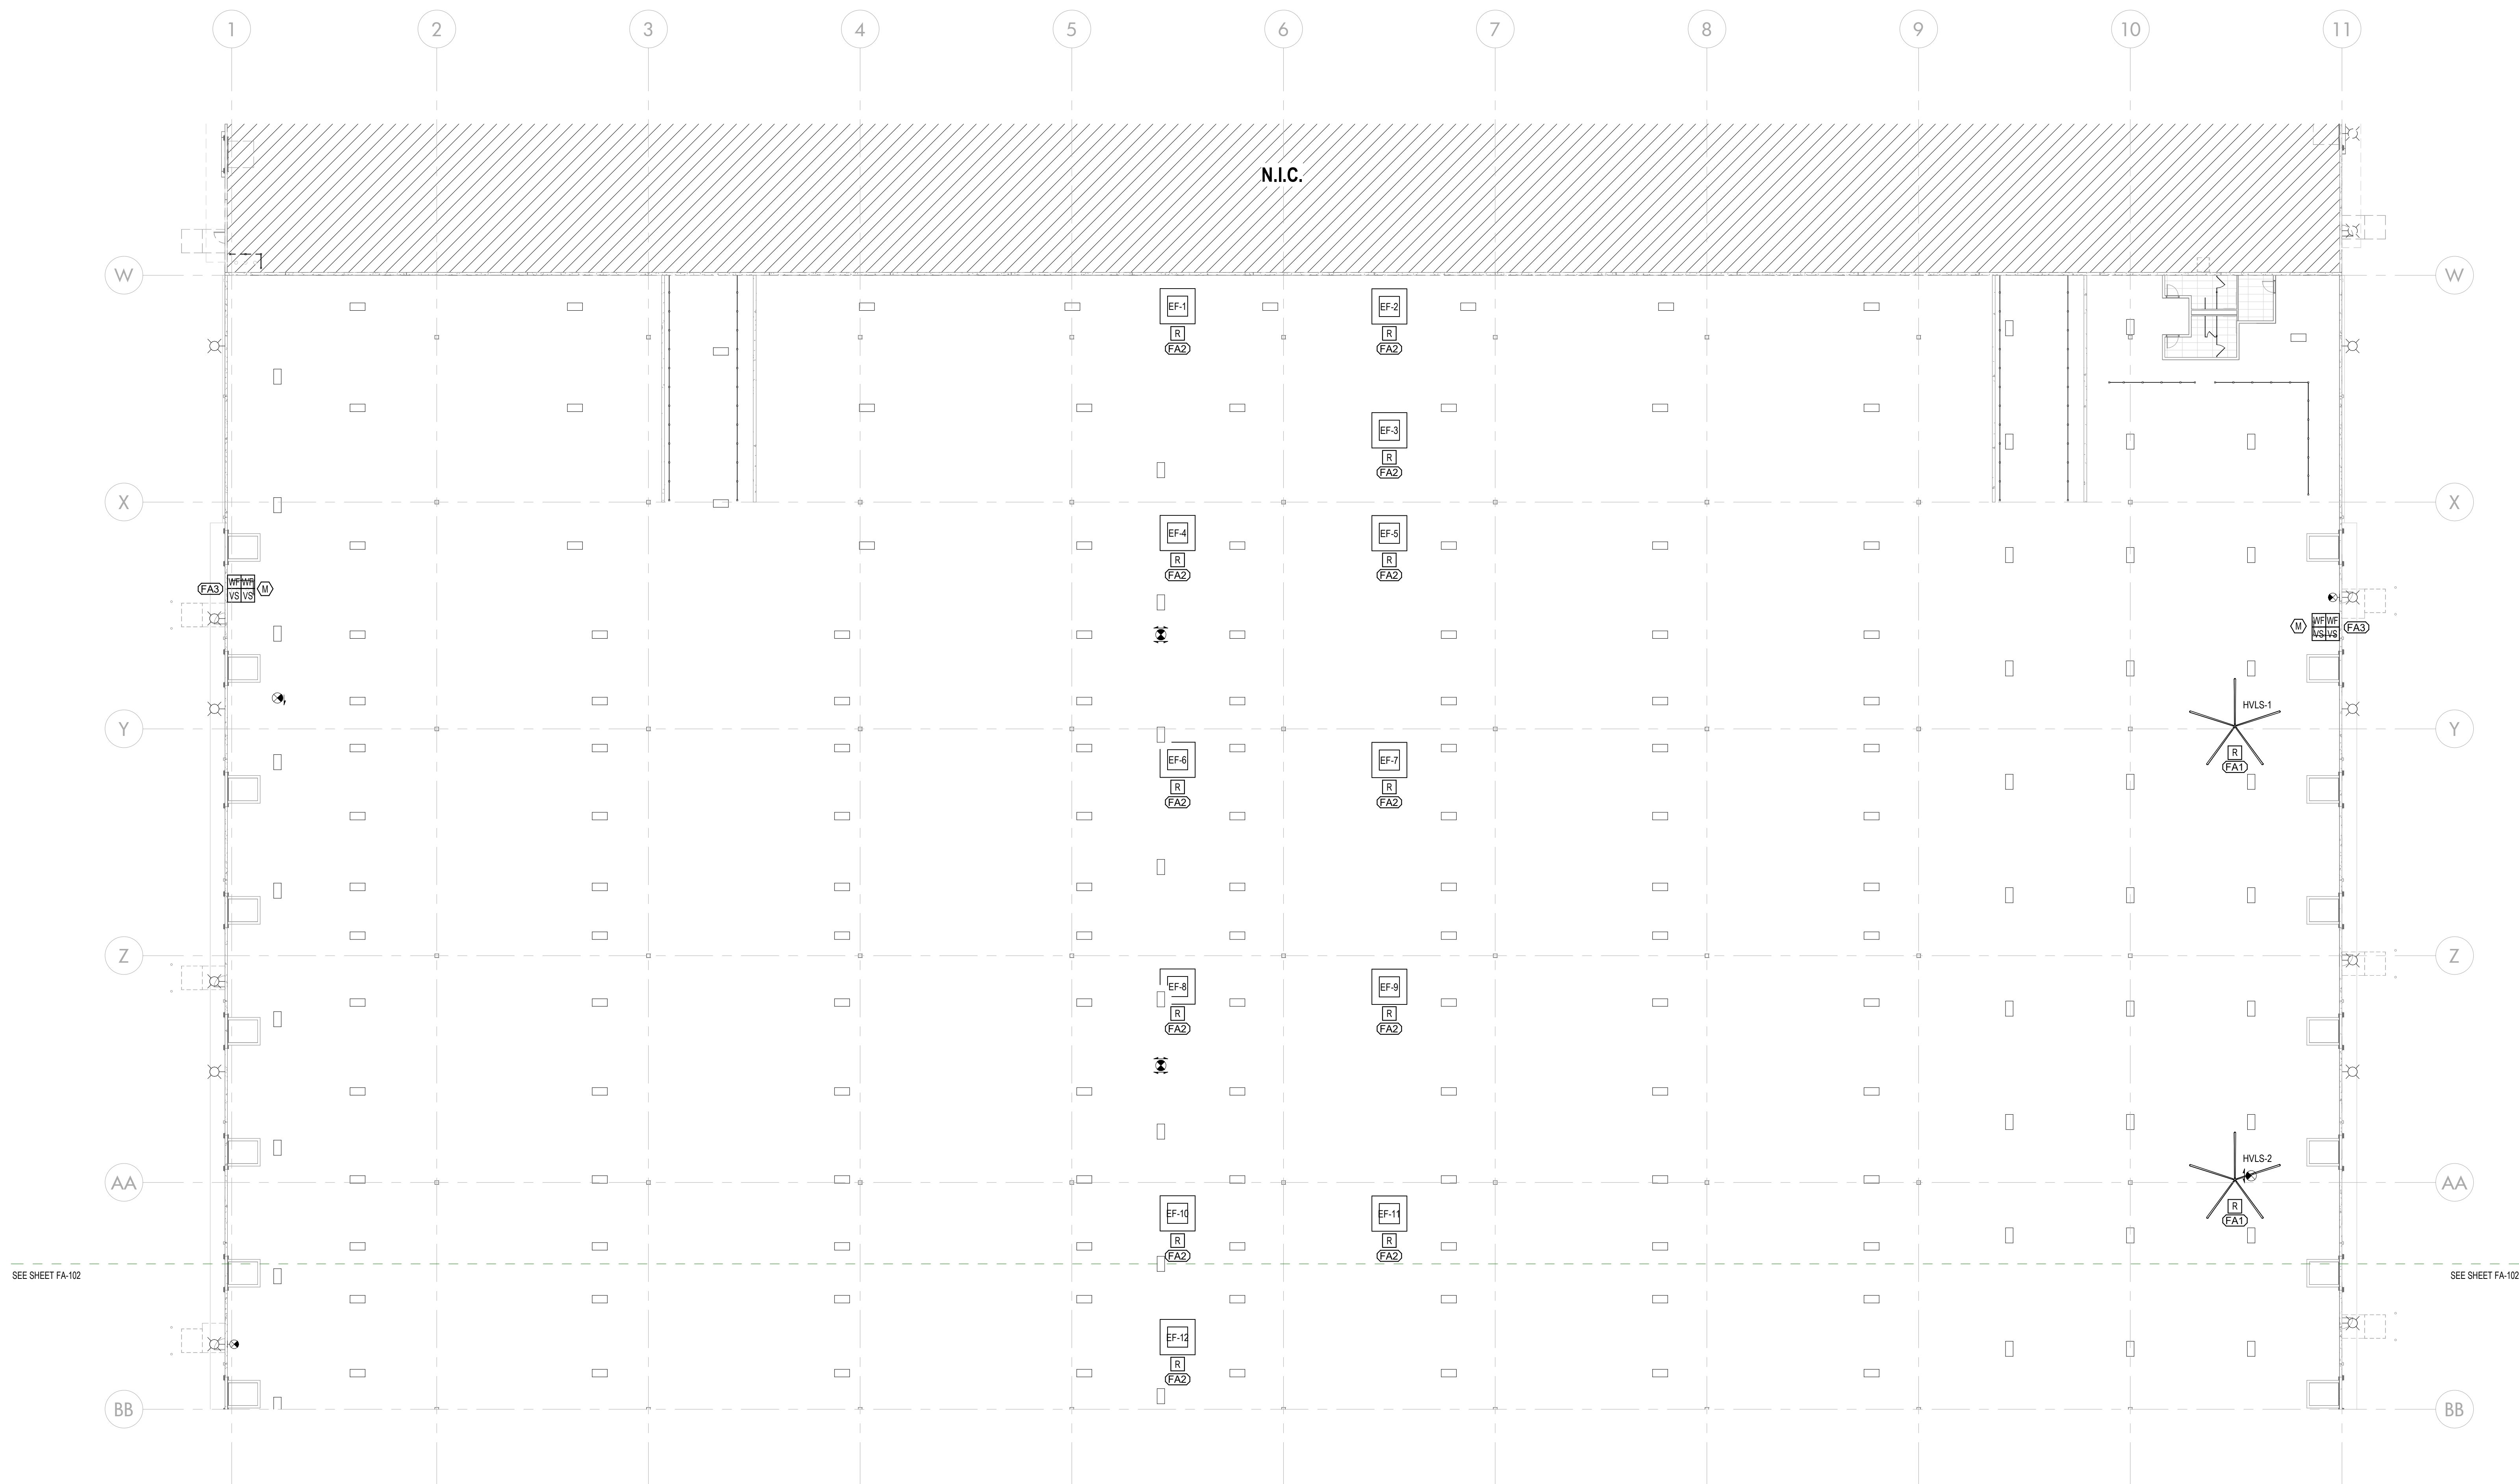

NOTE:
1. FOR BUILDING CODE SUMMARY SHEET, THIS IS A STORAGE OCCUPANCY AND FULL COVERAGE
NOTIFICATION IS NOT REQUIRED PER NCC SECTION 907.

1 PHASE II FLOOR PLAN - PLAN NORTH - FA
SCALE: 1" = 20'-0"

FIRE ALARM KEYNOTE LEGEND	
KEY VALUE	KEYNOTE TEXT
FA1	F.A.C. SHALL PROVIDE RELAY FOR HVLS SHUTDOWN UPON FACP ACTIVATION.
FA2	F.A.C. SHALL PROVIDE RELAY FOR EXHAUST FAN SHUTDOWN UPON FACP ACTIVATION.
FA3	PROVIDE AND INSTALL TAMPER AND FLOW SWITCHES AS REQUIRED FOR SPRINKLER RISER MONITORING. COORDINATE EXACT LOCATIONS AND QUANTITIES WITH F.P.C. PRIOR TO ROUGH IN.

SEISMIC DESIGN NOTE

SEISMIC DESIGN CATEGORY: C
RISK CATEGORY: II
SITE CLASSIFICATION: D
REFER TO BOOK SPECIFICATIONS FOR COMPLETE SEISMIC DESIGN REQUIREMENTS FOR PIPING, CONDUIT, DUCTWORK, EQUIPMENT, ETC.:
FIRE SUPPRESSION: 21 0548
PLUMBING SECTION: 22 0548
MECHANICAL SECTION: 23 0548
ELECTRICAL SECTION: 26 0548