



ROOMS TO GO -
PHASE II
EXPANSION

01 Rooms To Go Way
Dunn, NC 28334


DISCUSSION

BNK

ASS | NIXON | KENNEDY
CONSULTING ENGINEERS

ENGINEERING FIRM NUMBER: C-0110

10 CHAPEL HILL ROAD, SUITE 250
RALEIGH, NC 27607
PHONE: 919.851.4422

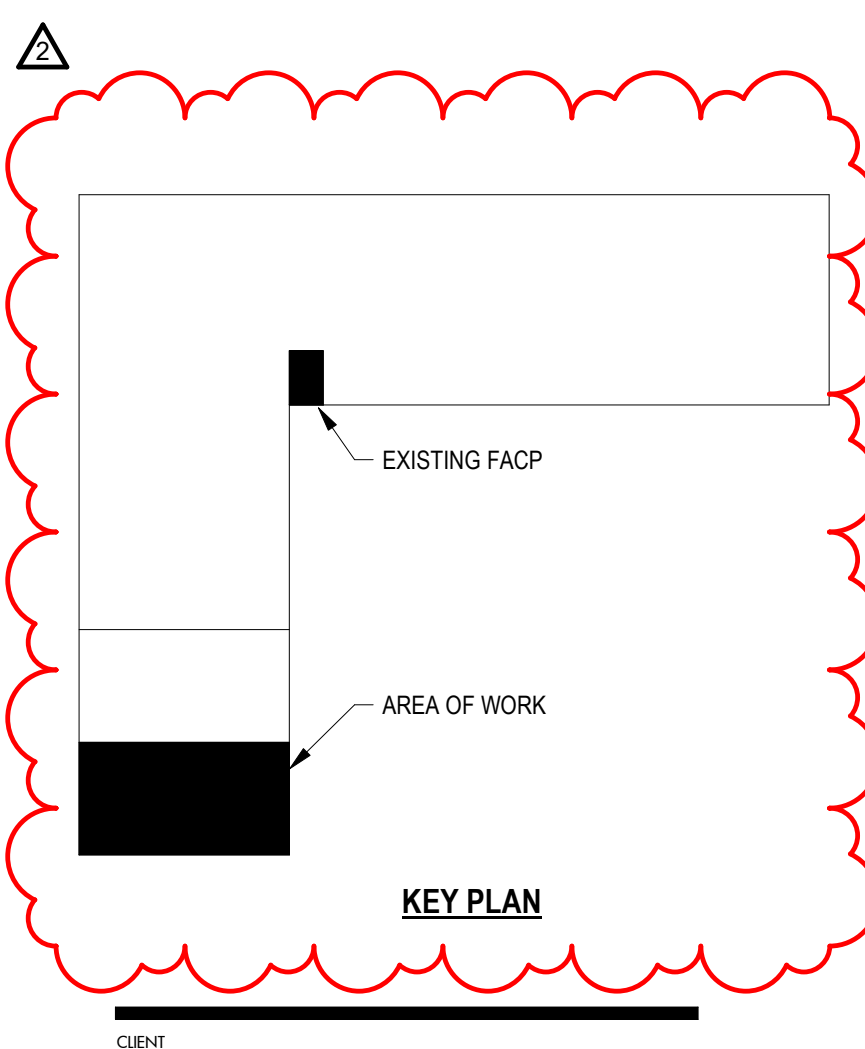

01 Rooms to Go Way
Dunn, NC 28334
(910) 292-3505

WORKING TITLE

PARTIAL FLOOR PLAN SOUTH - FIRE ALARM


[illegible]

OWN BY AMW

COXED BY PLC

DATE ISSUED 12/18/2023 3 OF 3

A-102

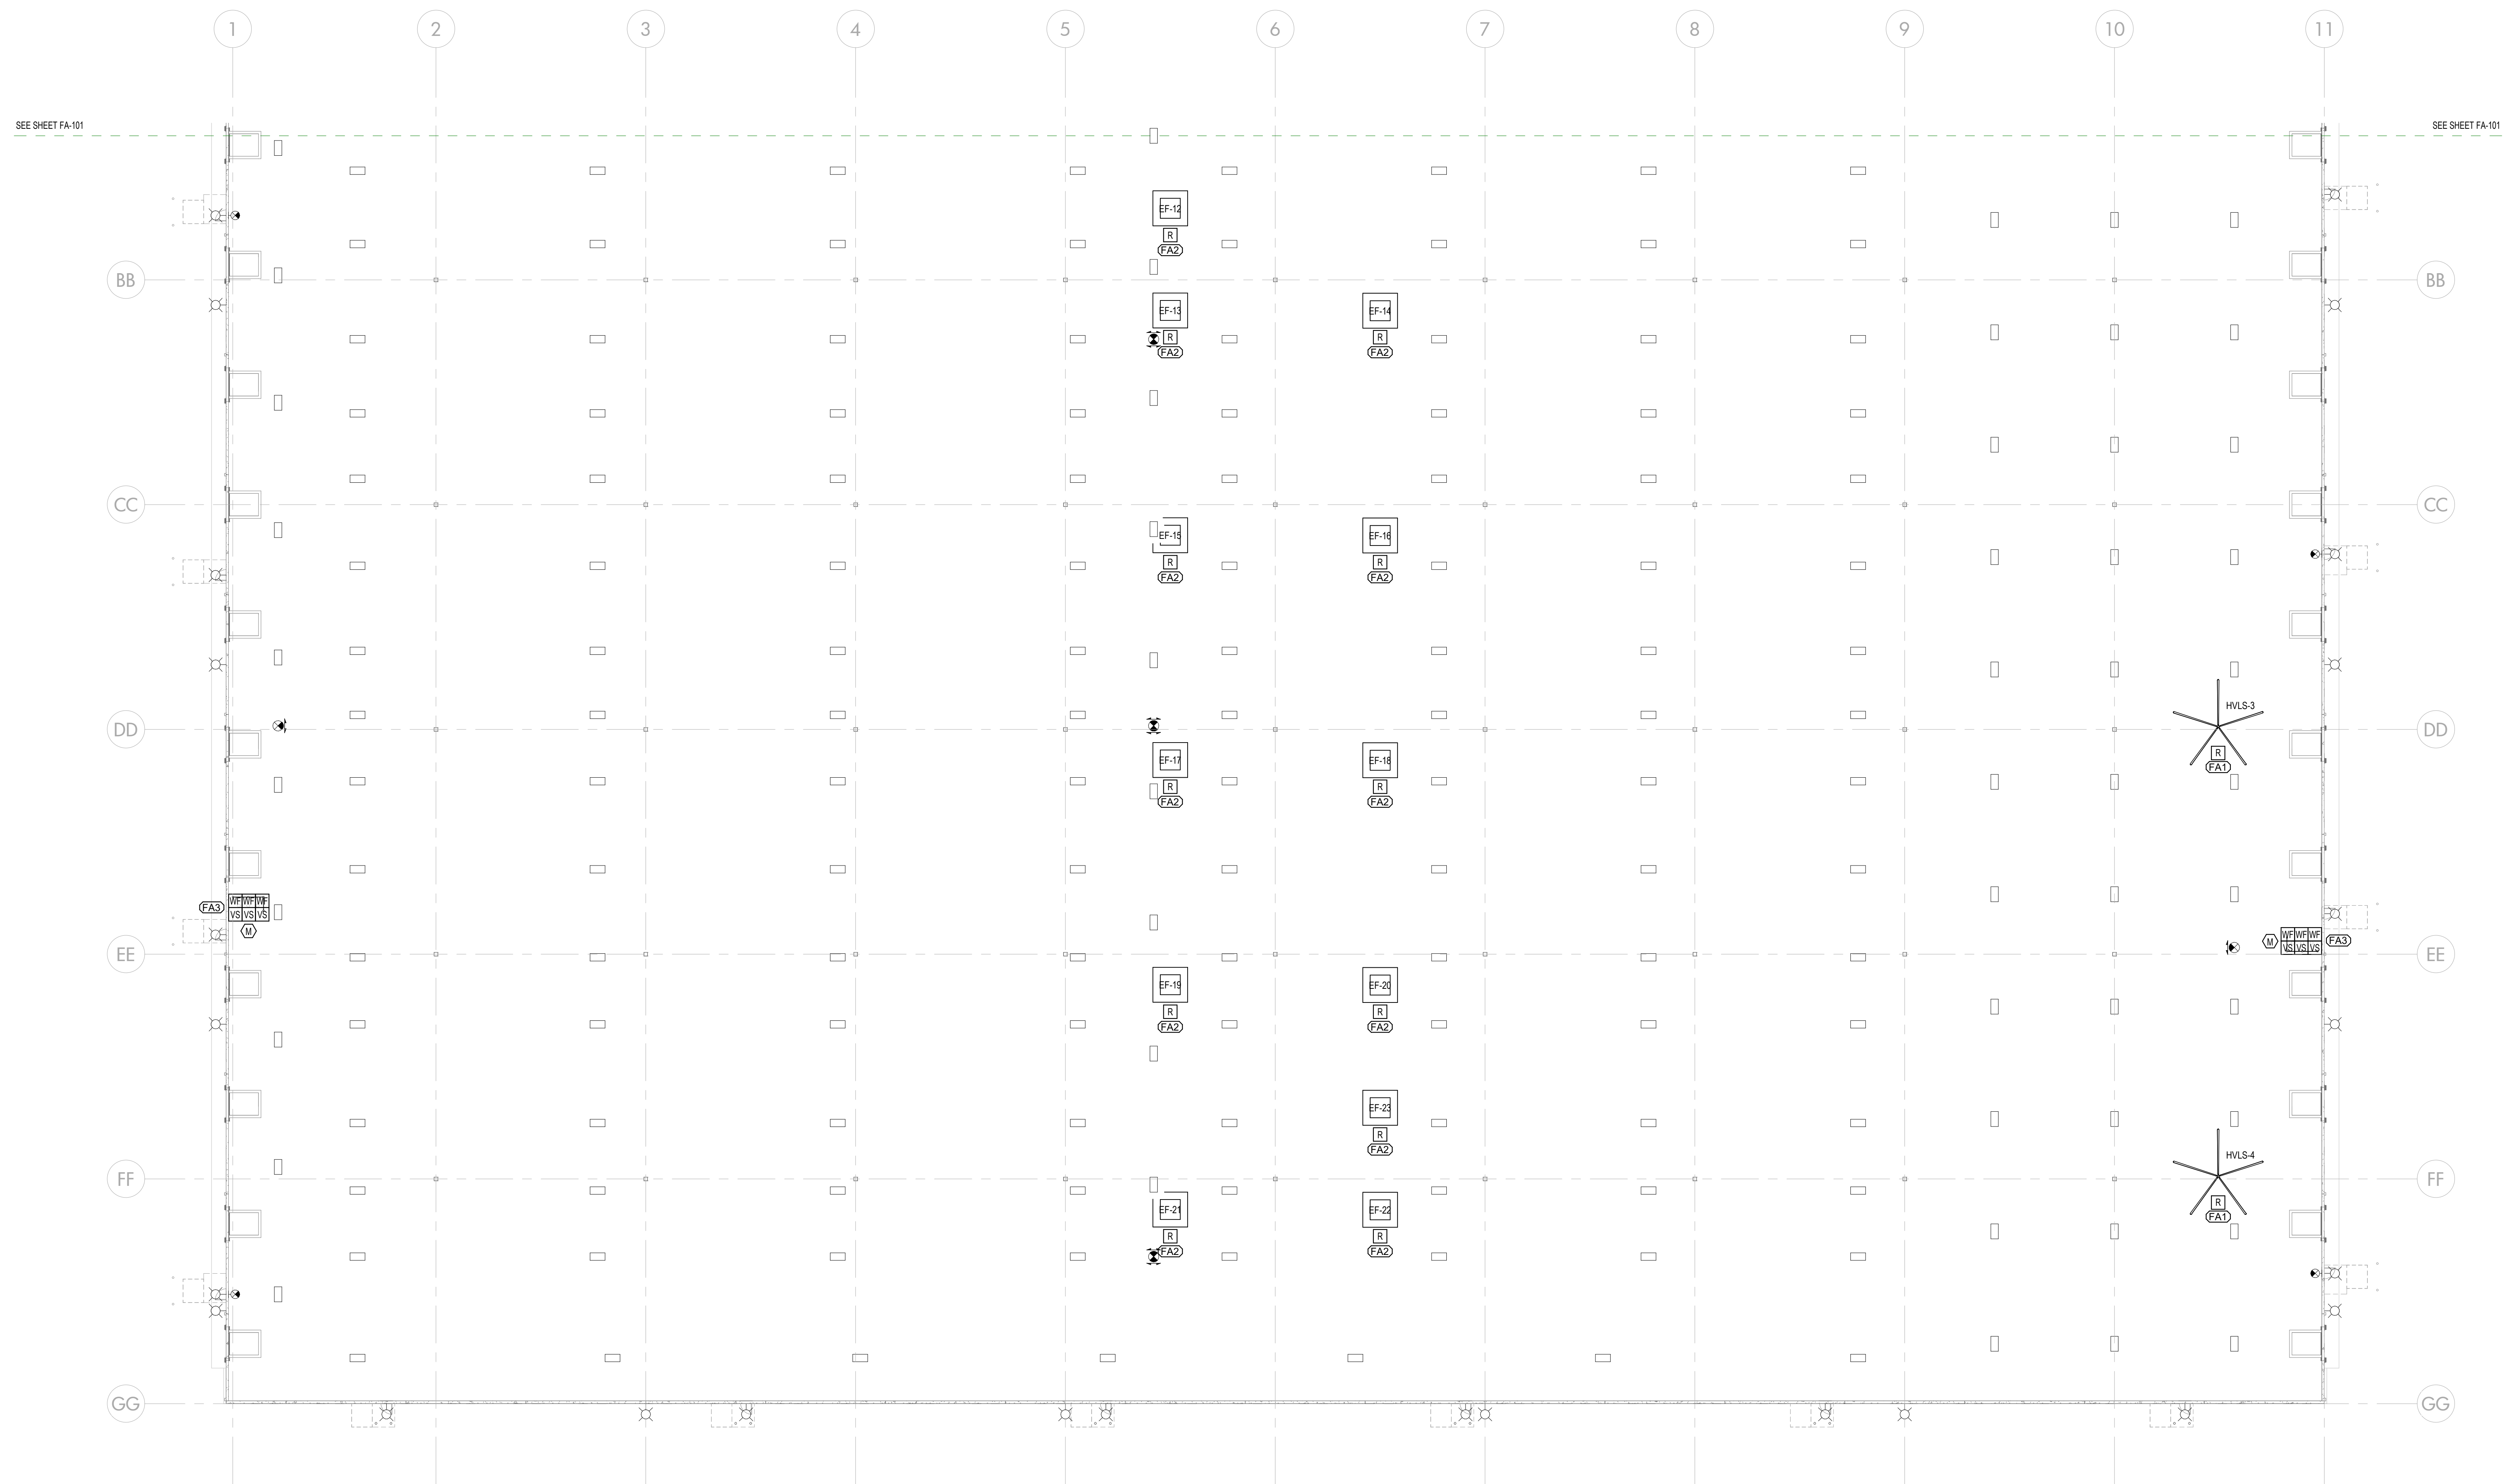

NOTE:
1. PER BUILDING CODE SUMMARY SHEET, THIS IS A STORAGE OCCUPANCY AND FULL COVERAGE NOTIFICATION IS NOT REQUIRED PER NCFC SECTION 907.

1 PHASE II FLOOR PLAN - PLAN SOUTH - FA
SCALE: 1" = 20'-0"

FIRE ALARM KEYNOTE LEGEND	
KEY VALUE	KEYNOTE TEXT
FA1	F.A.C. SHALL PROVIDE RELAY FOR HVLS SHUTDOWN UPON FACP ACTIVATION.
FA2	F.A.C. SHALL PROVIDE RELAY FOR EXHAUST FAN SHUTDOWN UPON FACP ACTIVATION.
FA3	PROVIDE AND INSTALL TAMPER AND FLOW SWITCHES AS REQUIRED FOR SPRINKLER RISER MONITORING. COORDINATE EXACT LOCATIONS AND QUANTITIES WITH F.P.C. PRIOR TO ROUGH-IN.

SEISMIC DESIGN NOTE

SEISMIC DESIGN CATEGORY: C
RISK CATEGORY: II
SITE CLASSIFICATION: D

REFER TO BOOK SPECIFICATIONS FOR COMPLETE SEISMIC DESIGN
REQUIREMENTS FOR PIPING, CONDUIT, DUCTWORK, EQUIPMENT, ETC.,

FIRE SUPPRESSION: 21 0548
PLUMBING SECTION: 22 0548
MECHANICAL SECTION: 23 0548
ELECTRICAL SECTION: 26 0548