



ARCHITECTURE | INTERIOR DESIGN
LANDSCAPE ARCHITECTURE

300 S. DAWSON STREET
RALEIGH, NC 27601 | 919.821.5547
www.hagersmith.com

© COPYRIGHT 2023

SEALS



PROJECT 288-000-000

ROOMS TO GO - PHASE II EXPANSION

901 Rooms to Go Way
Dunn, NC 28334


CONSULTANTS



1101 Haynes Street Suite 207
Raleigh, NC 27604
tel: 919.821.7146 www.fluhrerreed.com



BASS | NIXON | KENNEDY
CONSULTING ENGINEERS
ENGINEERING FIRM NUMBER: C-0110
6310 CHAPEL HILL ROAD, SUITE 250
RALEIGH, N.C. 27607
P.919.851.4422 BNKINC.COM

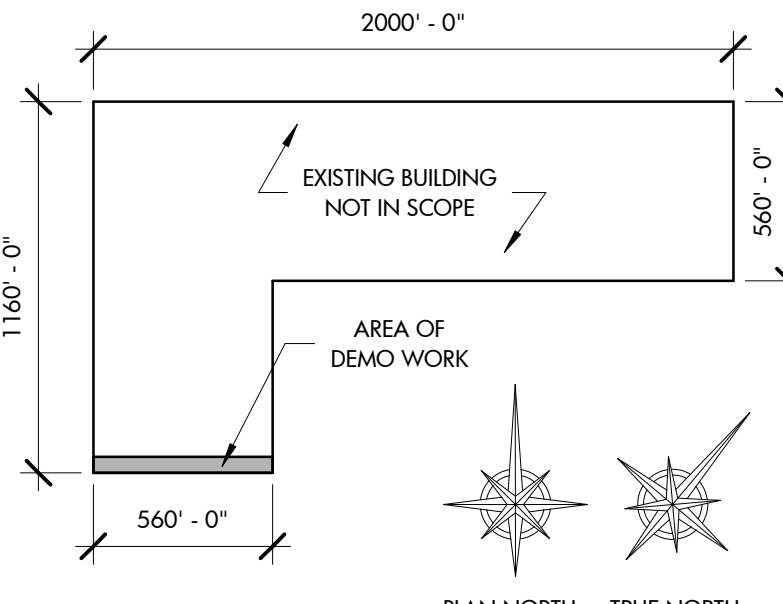

KEY PLAN
NTS

EXISTING FINISH
FLOOR LEVEL
0"

CLEAR



901 Rooms to Go Way
Dunn, NC 28334
(910) 292-3505


DRAWING TITLE

DEMOLITION PLAN, ELEVATION AND
DETAILS


REVISIONS		
NUMBER	DESCRIPTION	DATE

DRAWN BY: KRT
CHECKED BY: BDG
DATE ISSUED: 12/18/23 OF


D-101

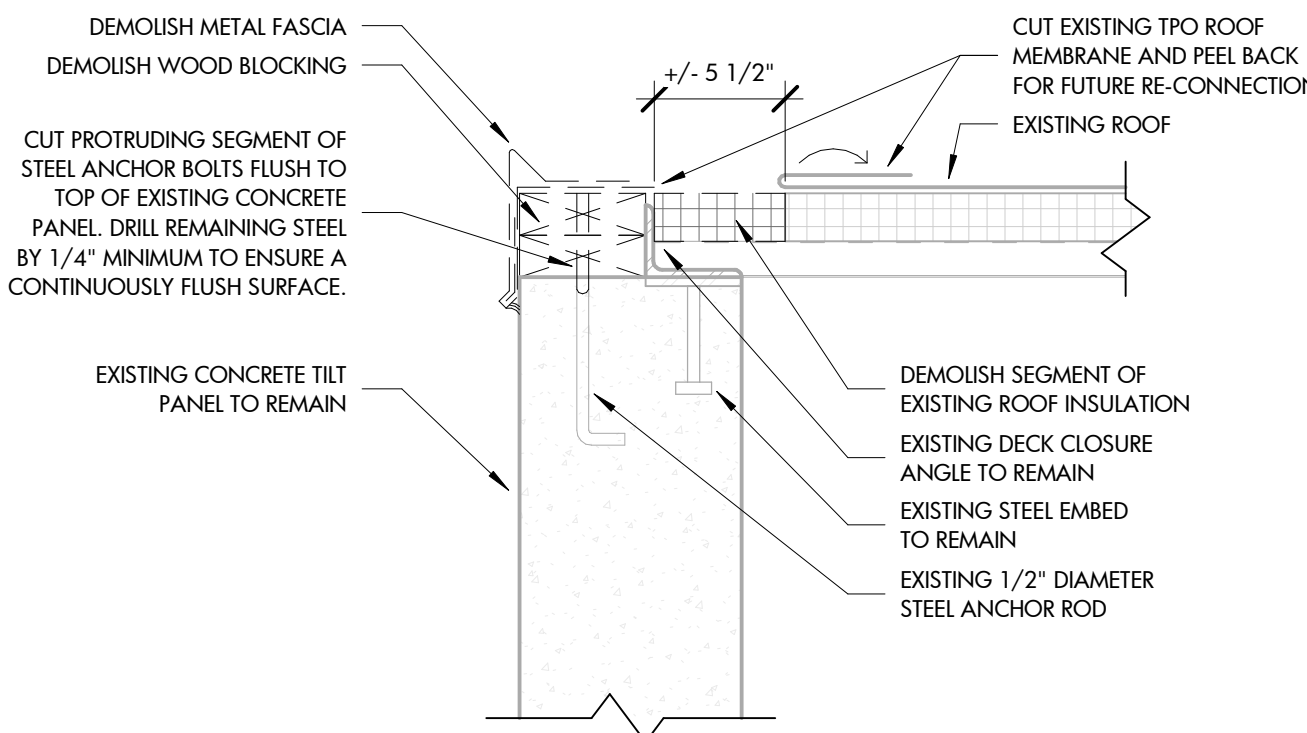

CS
D-101 FASCIA DEMOLITION DETAIL
1 1/2" = 1'-0"

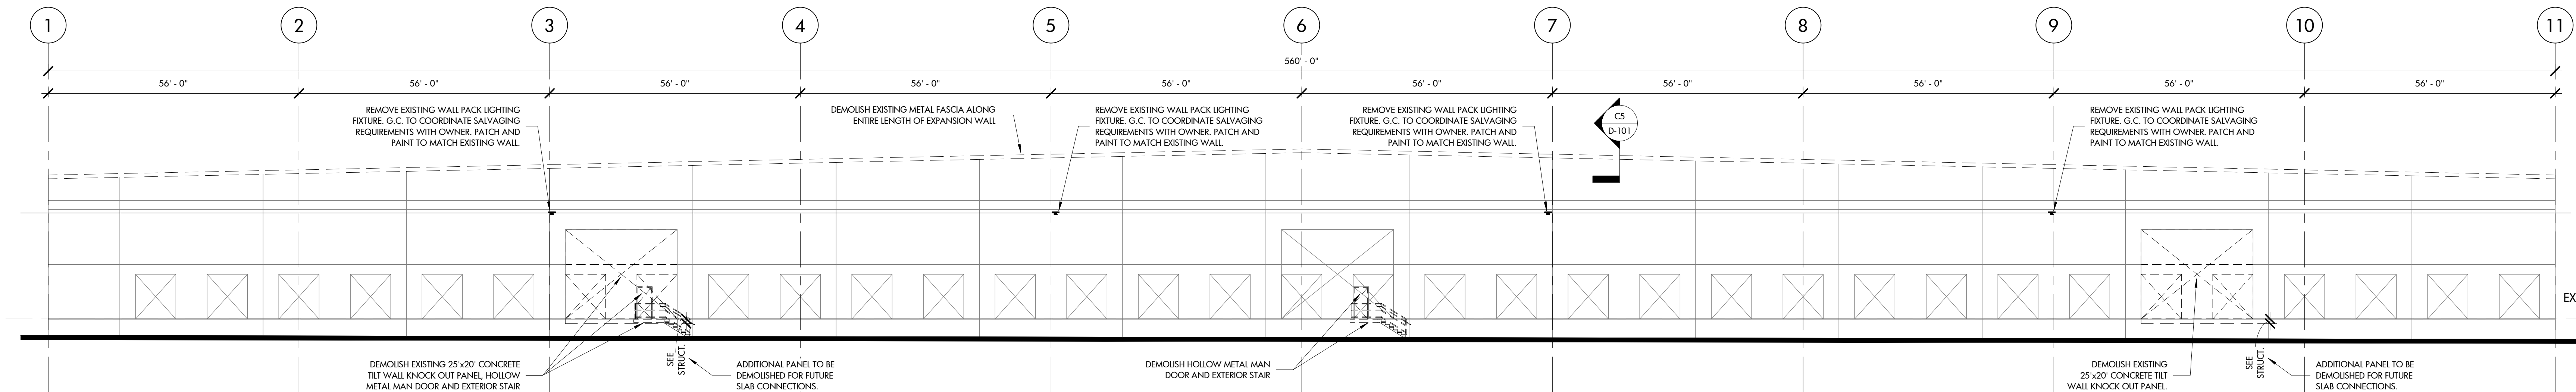

B1
D-101 EXISTING SOUTH WALL ELEVATION
1/16\"/>

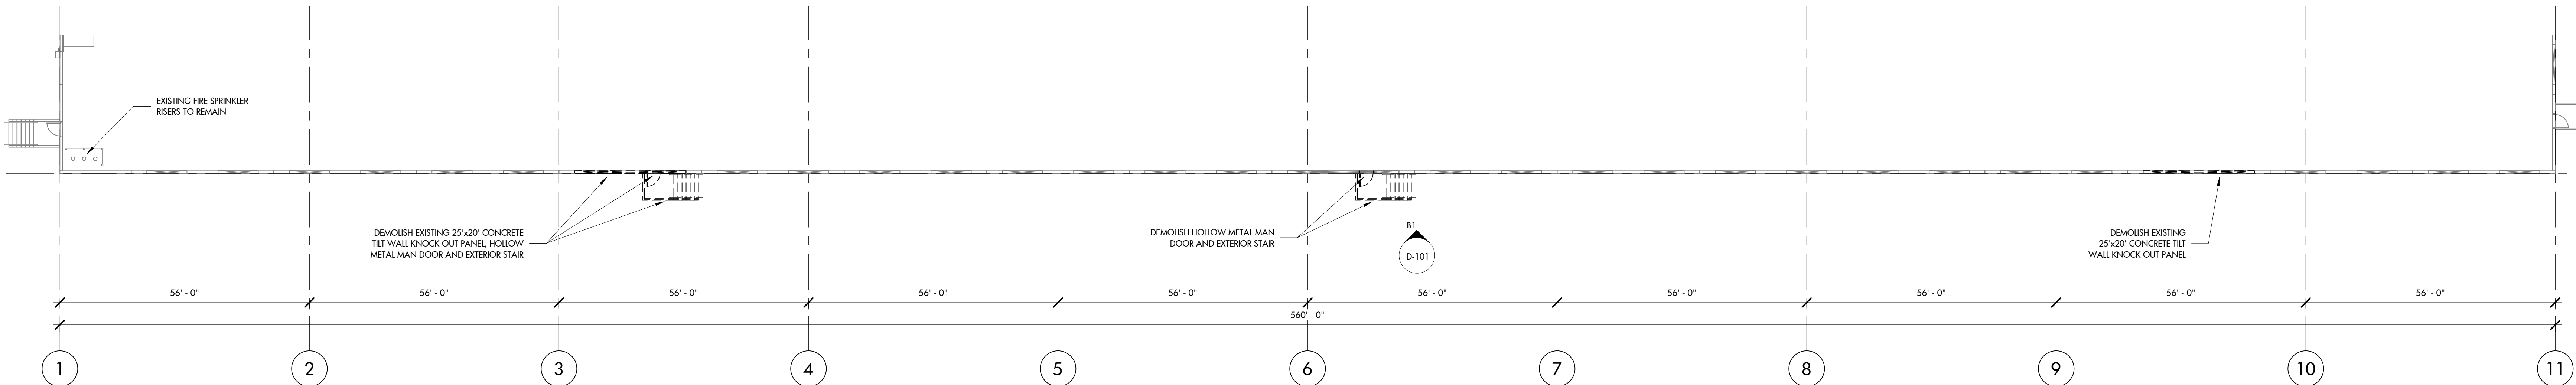


A1
D-101 DEMO FLOOR PLAN
1/16\"/>



PROJECT 288-000-000
**ROOMS TO GO -
PHASE II
EXPANSION**
901 Rooms to Go Way
Dunn, NC 28334



BNK
BASS | NIXON | KENNEDY
CONSULTING ENGINEERS
ENGINEERING FIRM NUMBER: C-0110
6310 CHAPEL HILL ROAD, SUITE 250
RALEIGH, N.C. 27607
P.919.851.4422 BNKINC.COM

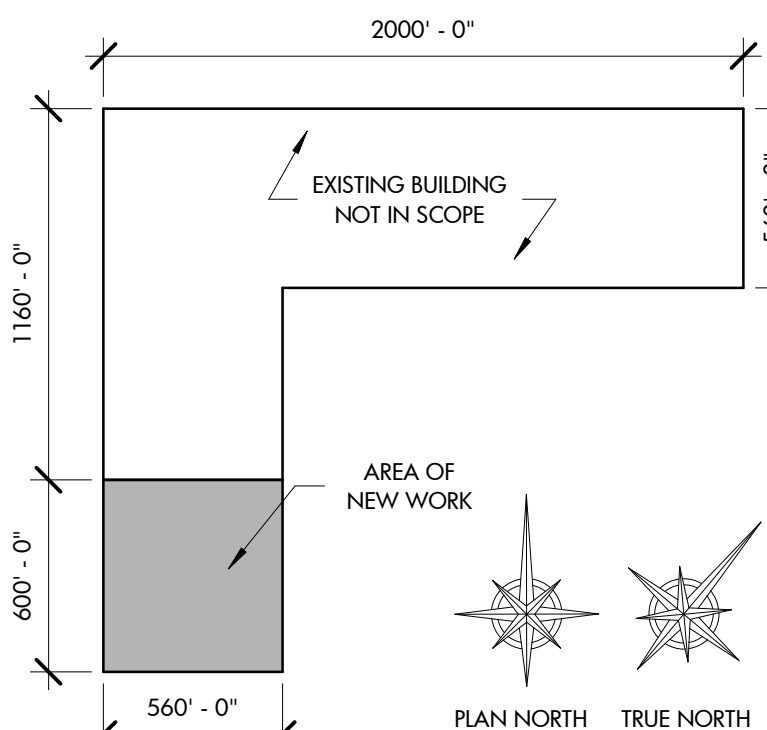

KEY PLAN
NTS
CLIENT

ROOMS TO GO

901 Rooms to Go Way
Dunn, NC 28334
(910) 292-3505

DRAWING TITLE
PHASE II EXPANSION FLOOR PLAN

REVISIONS		
NUMBER	DESCRIPTION	DATE
1	BID DOCUMENTS	02/02/24

DRAWN BY **KRT**
CHECKED BY **BDG**
DATE ISSUED **12/18/23** OF


A-101

GENERAL NOTES

- DO NOT SCALE DRAWINGS. ALL DIMENSIONS ARE TAKEN FROM FACE OF SHEATHING, TYPICAL. ANY DIMENSIONS DEEMED QUESTIONABLE ARE TO BE VERIFIED BY THE ARCHITECT/DESIGNER.
- COORDINATE WORK OF THIS TRADE WITH OTHER TRADES.
- DOOR AND FRAME NUMBERS CORRESPOND TO ROOM NUMBERS. WHERE THERE IS MORE THAN ONE DOOR PER ROOM, A SUFFIX HAS BEEN ADDED - LETTERS "I" AND "O" HAVE BEEN OMITTED FOR CLARITY. SEE A-600 SERIES SHEETS FOR DOOR AND FRAME INFORMATION.
- APPLY SEALANT AT ALL JUNCTURES BETWEEN DIFFERENT MATERIALS, AT PLUMBING FIXTURES AT JUNCTURE WITH WALLS, AT ALL COUNTERTOPS/BACKSPLASH AT JUNCTURE WITH WALL AND WHERE INDICATED THROUGHOUT THESE DRAWINGS.
- PROVIDE MISCELLANEOUS METAL SUPPORT FOR ALL CEILING SUSPENDED ITEMS AS REQUIRED.
- ALL DOORS MUST BE INSTALLED WITH AT LEAST THE MINIMUM MANEUVERING CLEARANCES AT THE DOOR APPROACH PER THE MOST CURRENT VERSION OF THE AMERICANS WITH DISABILITIES ACT.
- PROVIDE IN-WALL BLOCKING AS REQUIRED FOR ALL SURFACE MOUNTED ITEMS.

PLAN NOTES


- JANITOR'S SINK. PROVIDE FIBERGLASS REINFORCED PLASTIC PANEL FROM TOP OF SINK TO BOTTOM OF FAUCET ON BOTH WALLS ADJACENT TO THE SINK. PROVIDE 30" LONG FLEXIBLE HOSE AND HOSE CLAMP. SEE PLUMBING DRAWINGS FOR ADDITIONAL INFORMATION.
- CARD READER LOCATION. REFERENCE SHEET A-601 FOR DOOR HARDWARE INFORMATION.
- 6" DIA. CONCRETE FILLED HEAVY GAUGE STEEL PIPE BOLLARD, 42" TALL. SEE DETAIL A5/A-501.
- REFINISHED AND PREFABRICATED GUARD RAIL SYSTEM, YELLOW FINISH. PROVIDE "HERVIN SAFETY WAREHOUSE BARBER GUARDRAIL BY GUARDSMITH" OR OWNER APPROVED ALTERNATE.
- 4" TALL CAST-IN-PLACE CONCRETE PAD, G.C. TO COORDINATE AGAINST FINAL SWITCHGEAR SELECTION.
- DOWNSPOUT LOCATION. REFERENCE A-102 FOR ADDITIONAL INFORMATION. SEE A1/A-501 FOR GUARD PROTECTION DETAILS.
- CHARGING STATIONS BY OWNER. SHOWN FOR REFERENCE ONLY.
- BELOW-GRADE SEWAGE LIFT STATION. REFERENCE PLUMBING DRAWINGS FOR ADDITIONAL INFORMATION.
- ELECTRICAL CONTROL PANEL LOCATION. REFERENCE MEP DRAWINGS FOR ADDITIONAL INFORMATION.
- TRANSFORMER LOCATION. REFERENCE ELECTRICAL AND CIVIL DRAWINGS FOR ADDITIONAL INFORMATION.
- GENERATOR LOCATION. REFERENCE ELECTRICAL DRAWINGS FOR ADDITIONAL INFORMATION.
- PROPOSED INTERMEDIATE DISTRIBUTION FRAME (IDF) CABINET LOCATION. GENERAL CONTRACTOR TO DETERMINE FINAL LOCATION WITH OWNER. SEE ELECTRICAL DRAWINGS FOR ADDITIONAL INFORMATION.
- DOCK STAR LOCATION. SEE DETAILS A4&D4/A-501.
- FIRE RISER LOCATION. REFERENCE BASIS OF DESIGN FIRE SPRINKLER DRAWINGS FOR ADDITIONAL INFORMATION. SEE A1/A-501 FOR GUARD PROTECTION DETAILS.
- 6" x 8", 30,000# AIRBAG DOCK LEVELER UNIT. BASIS OF DESIGN; KELLEY "dpx".

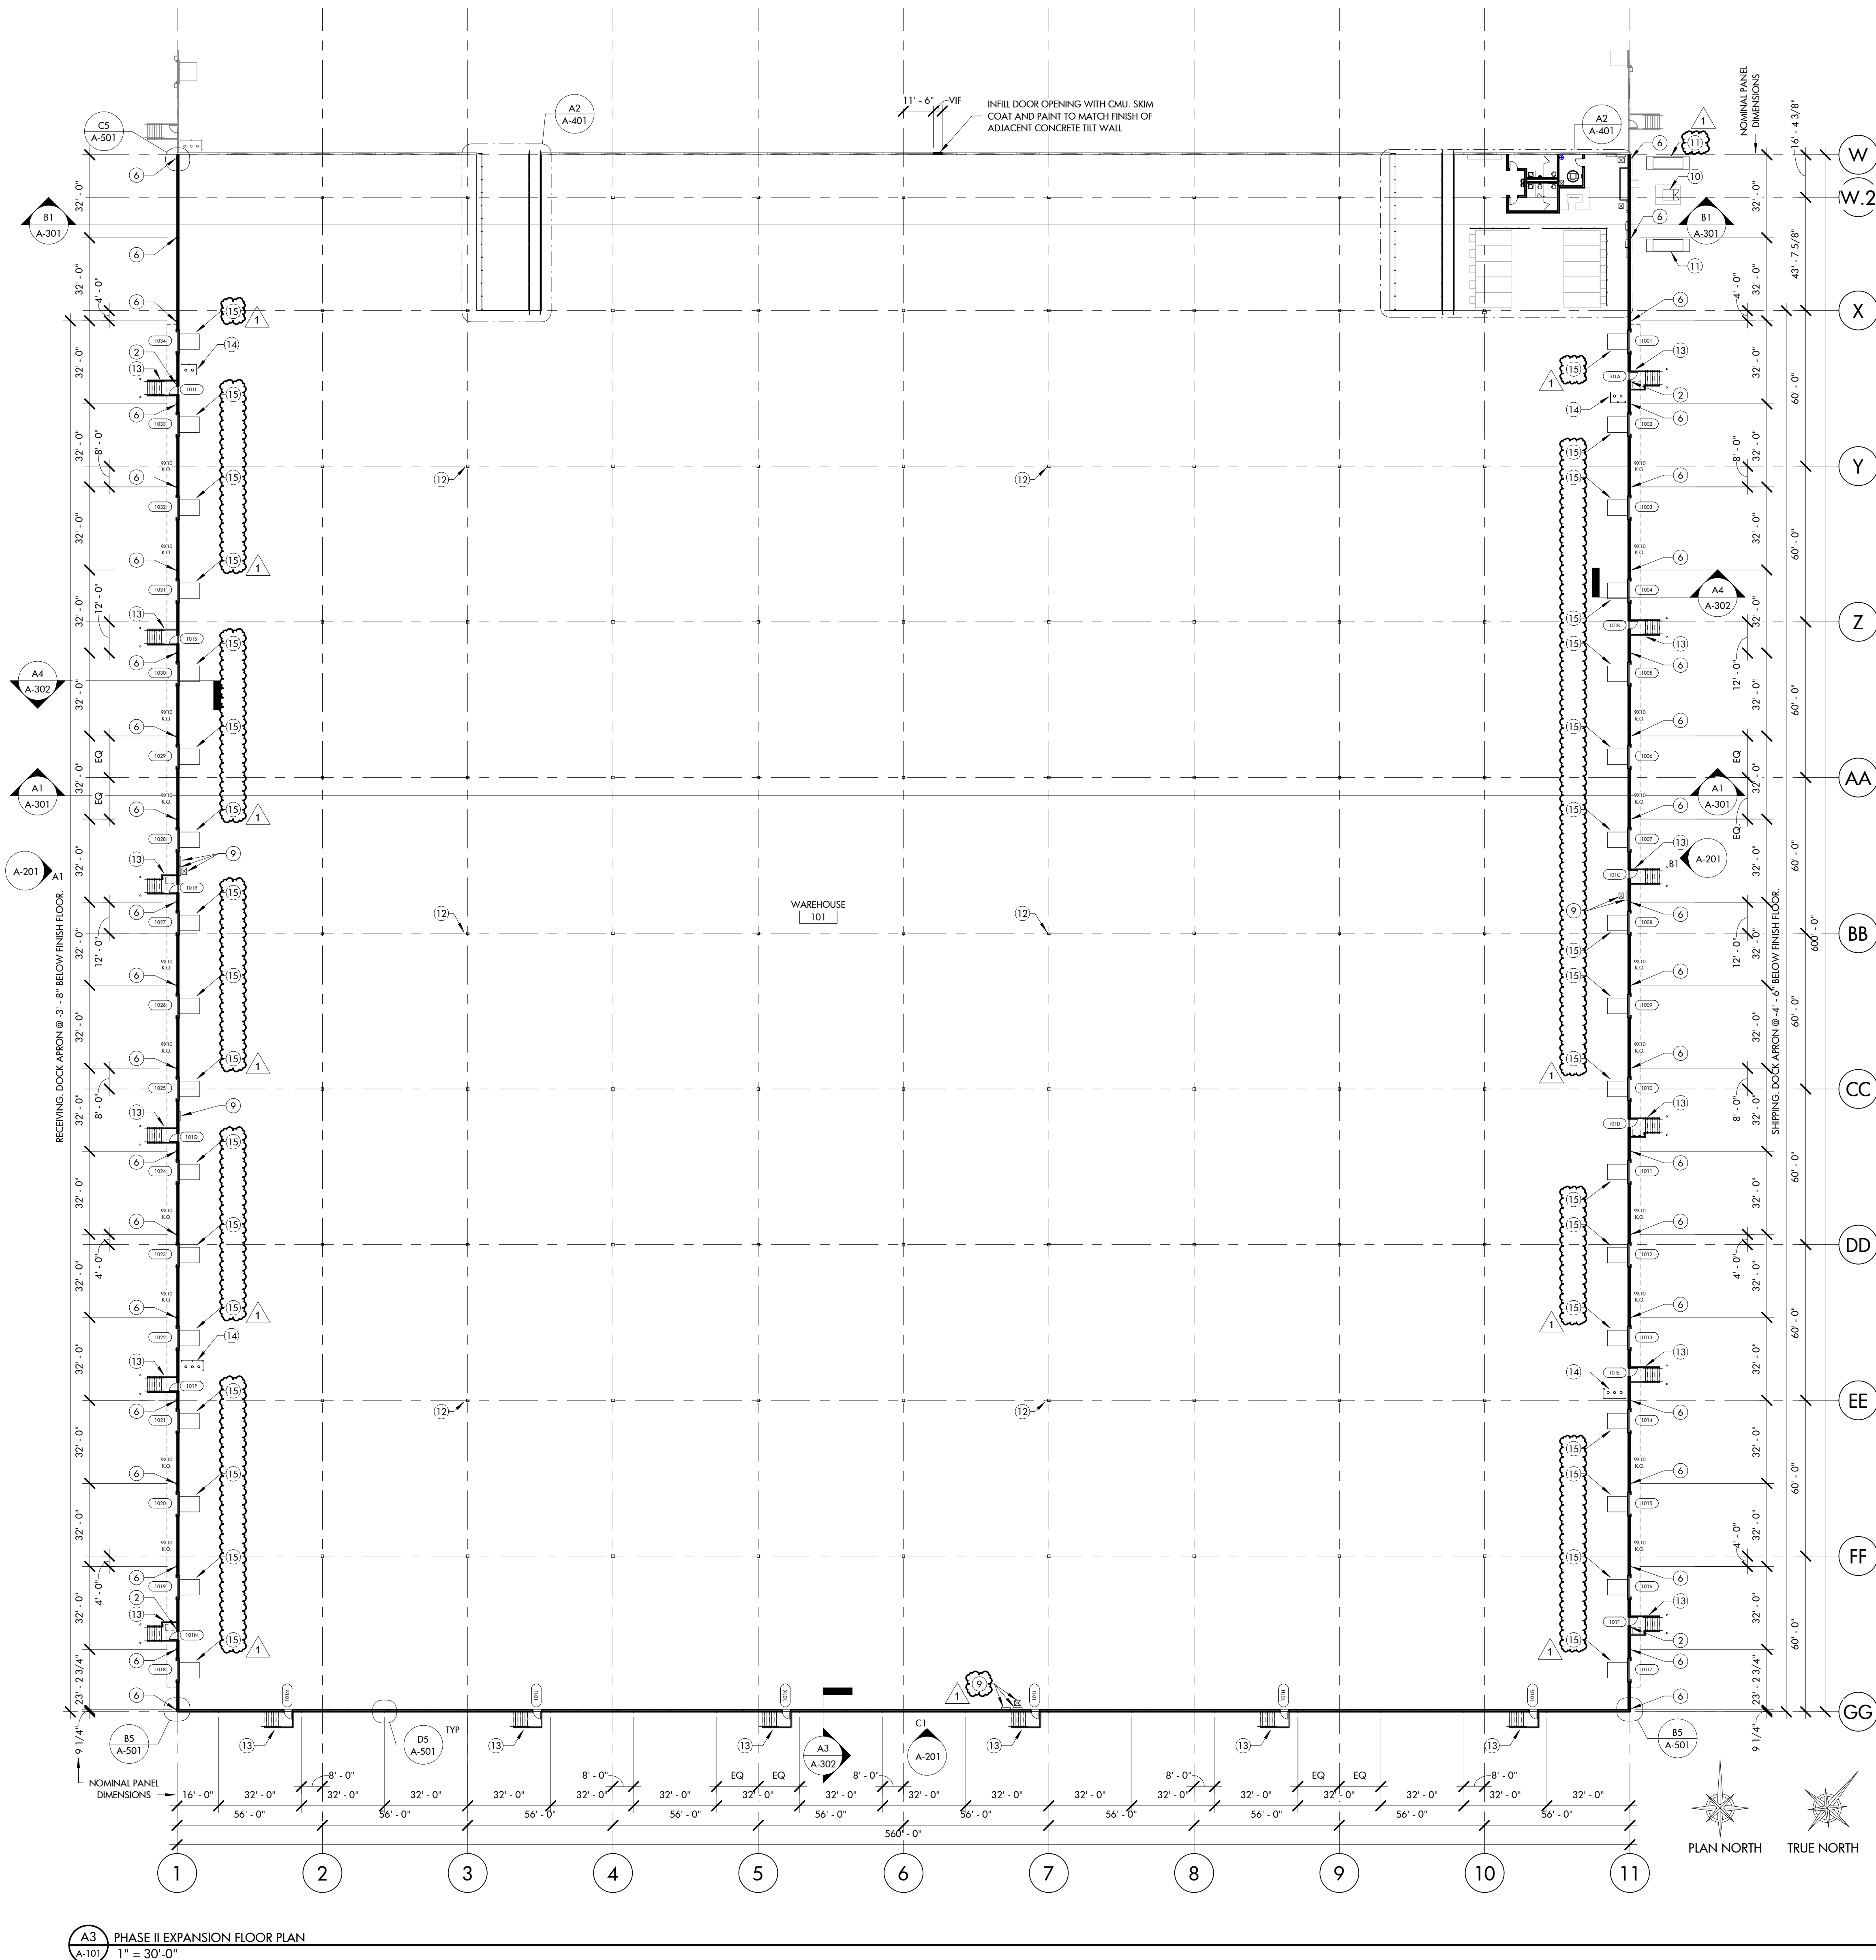

A3 PHASE II EXPANSION FLOOR PLAN
A-101 1" = 30'-0"

- EXTERIOR TILT PANELS TO RECEIVE ONE COAT OF "TEXCOTE XL-70 PRIMER", COARSE WHITE TEXTURE PRIOR TO PAINTING.
- EXPOSED INTERIOR AND EXTERIOR GAS LINES ARE TO BE PAINTED.
- RTU CONDENSATE LINES EXPOSED TO DIRECT SUNLIGHT SHALL BE PAINTED.

- 100

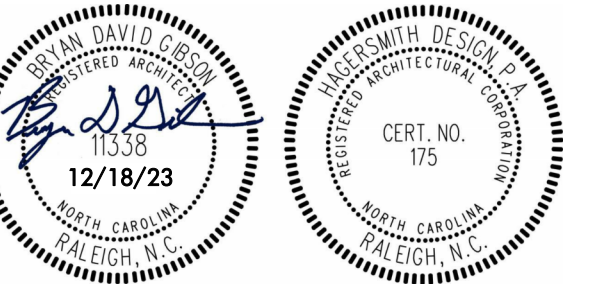


PROJECT 288-000-000

01 Rooms to Go Way
Dunn, NC 28334

CONSULTANTS






1101 Haynes Street Suite 207
Raleigh, NC 27604
919.821.7146 www.fuhrerreed.com

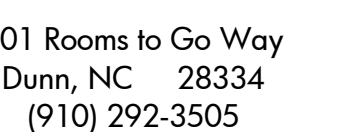

EXTERIOR ELEVATIONS

[illegible]

   A-201





300 S. DAWSON STREET
LEIGH, NC 27601 | 919.821.5547
www.hagersmith.com

SALS



PROJECT 288-000-000

ROOMS TO GO - PHASE II EXPANSION

01 Rooms to Go Way
Dunn, NC 28334


CONSULTANTS



1101 Haynes Street Suite 207
Raleigh, NC 27604
919.821.7146 www.fuhrerreed.com



BASS | NIXON | KENNEDY
CONSULTING ENGINEERS
ENGINEERING FIRM NUMBER: C-0110
6310 CHAPEL HILL ROAD, SUITE 250
RALEIGH, N.C. 27607
P.919.851.4422 BNKINC.COM

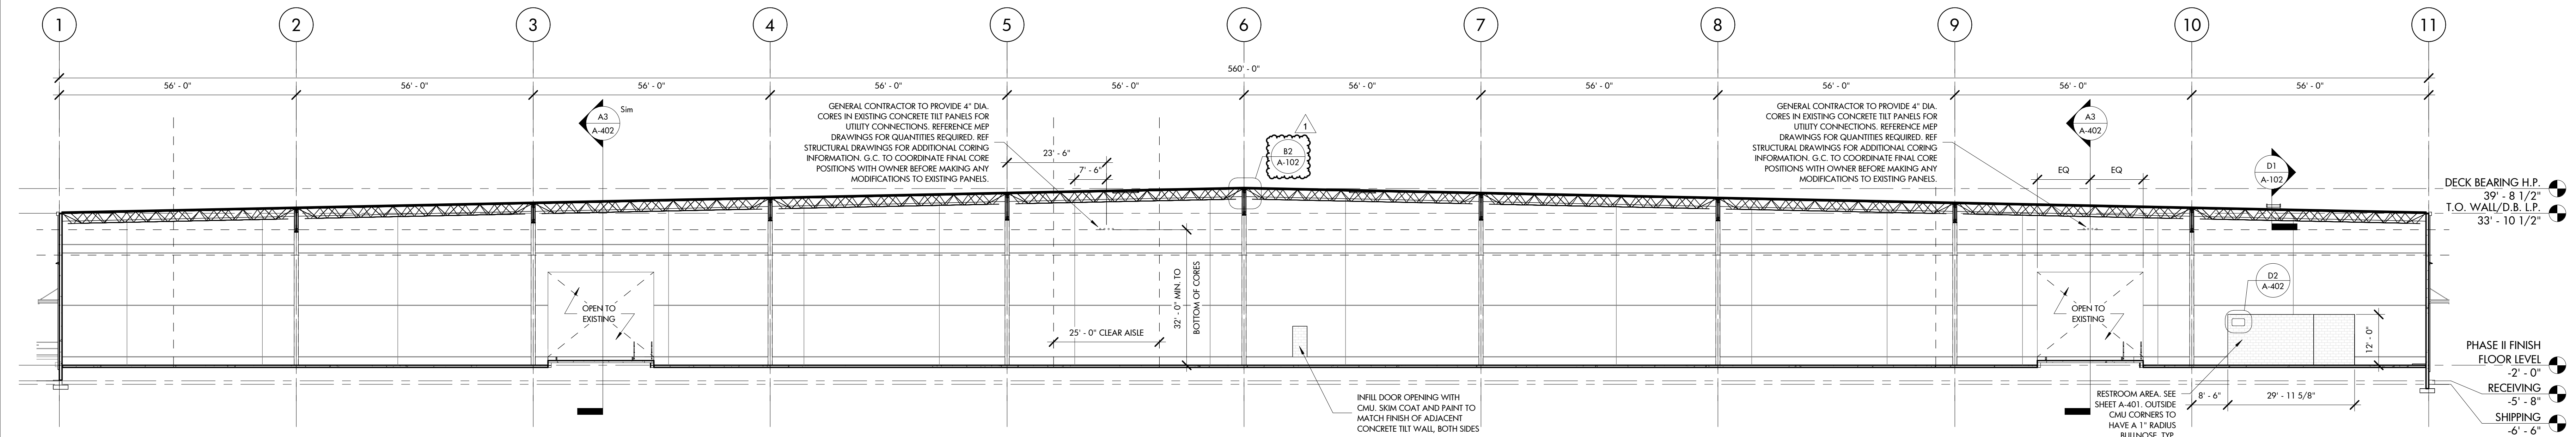

B1 BUILDING SECTION
A-301 1/16" = 1'-0"


JENT



01 Rooms to Go Way
Dunn, NC 28334
(910) 292-3505

DRAWING TITLE

BUILDING SECTIONS


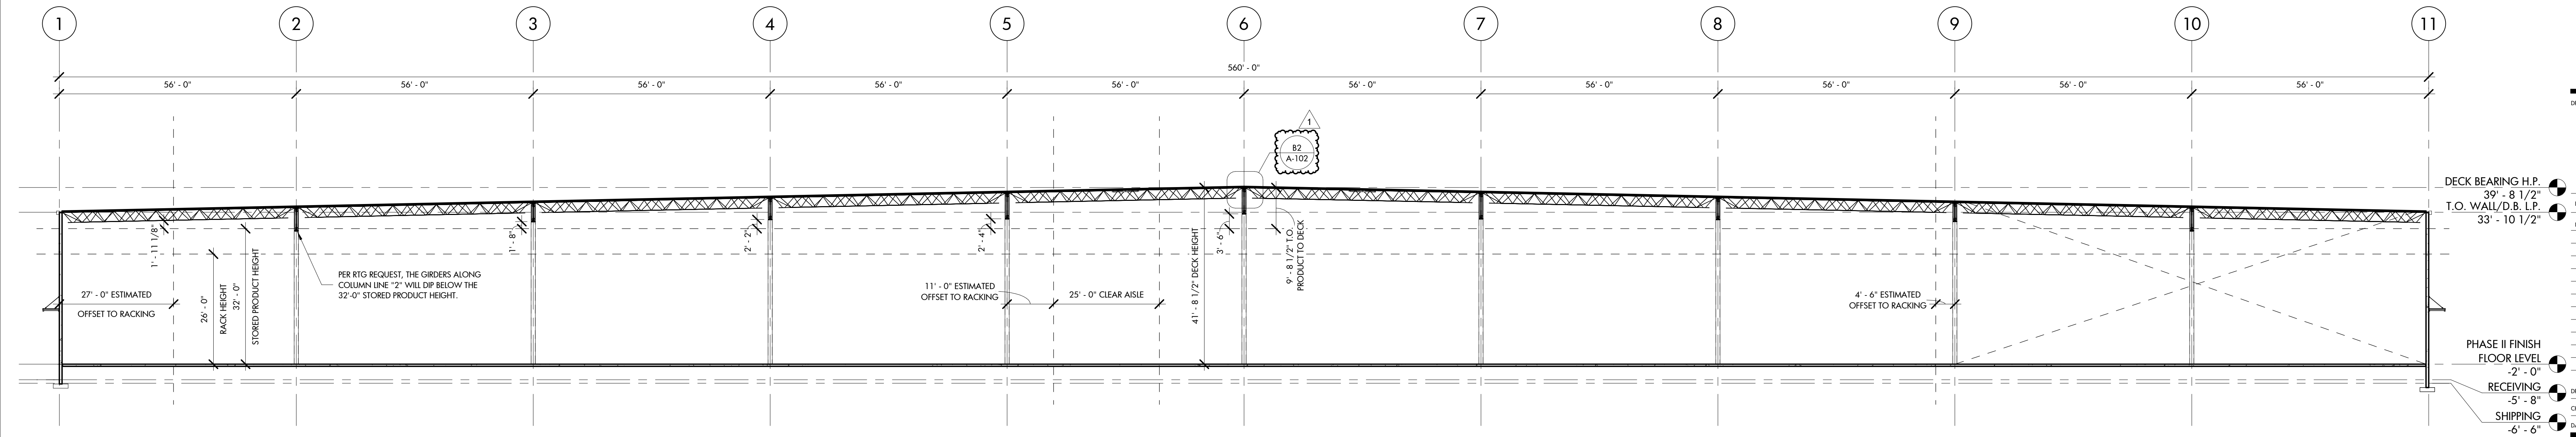


A1 BUILDING SECTION
A-301 $1/16" = 1'-0"$

DRAWN BY **KRI**
 CHECKED BY **BDG**
 DATE ISSUED **12/18/23** ____ OF ____

DRAWN BY	KRT
CHECKED BY	BDG
DATE ISSUED	12/18/

A-301

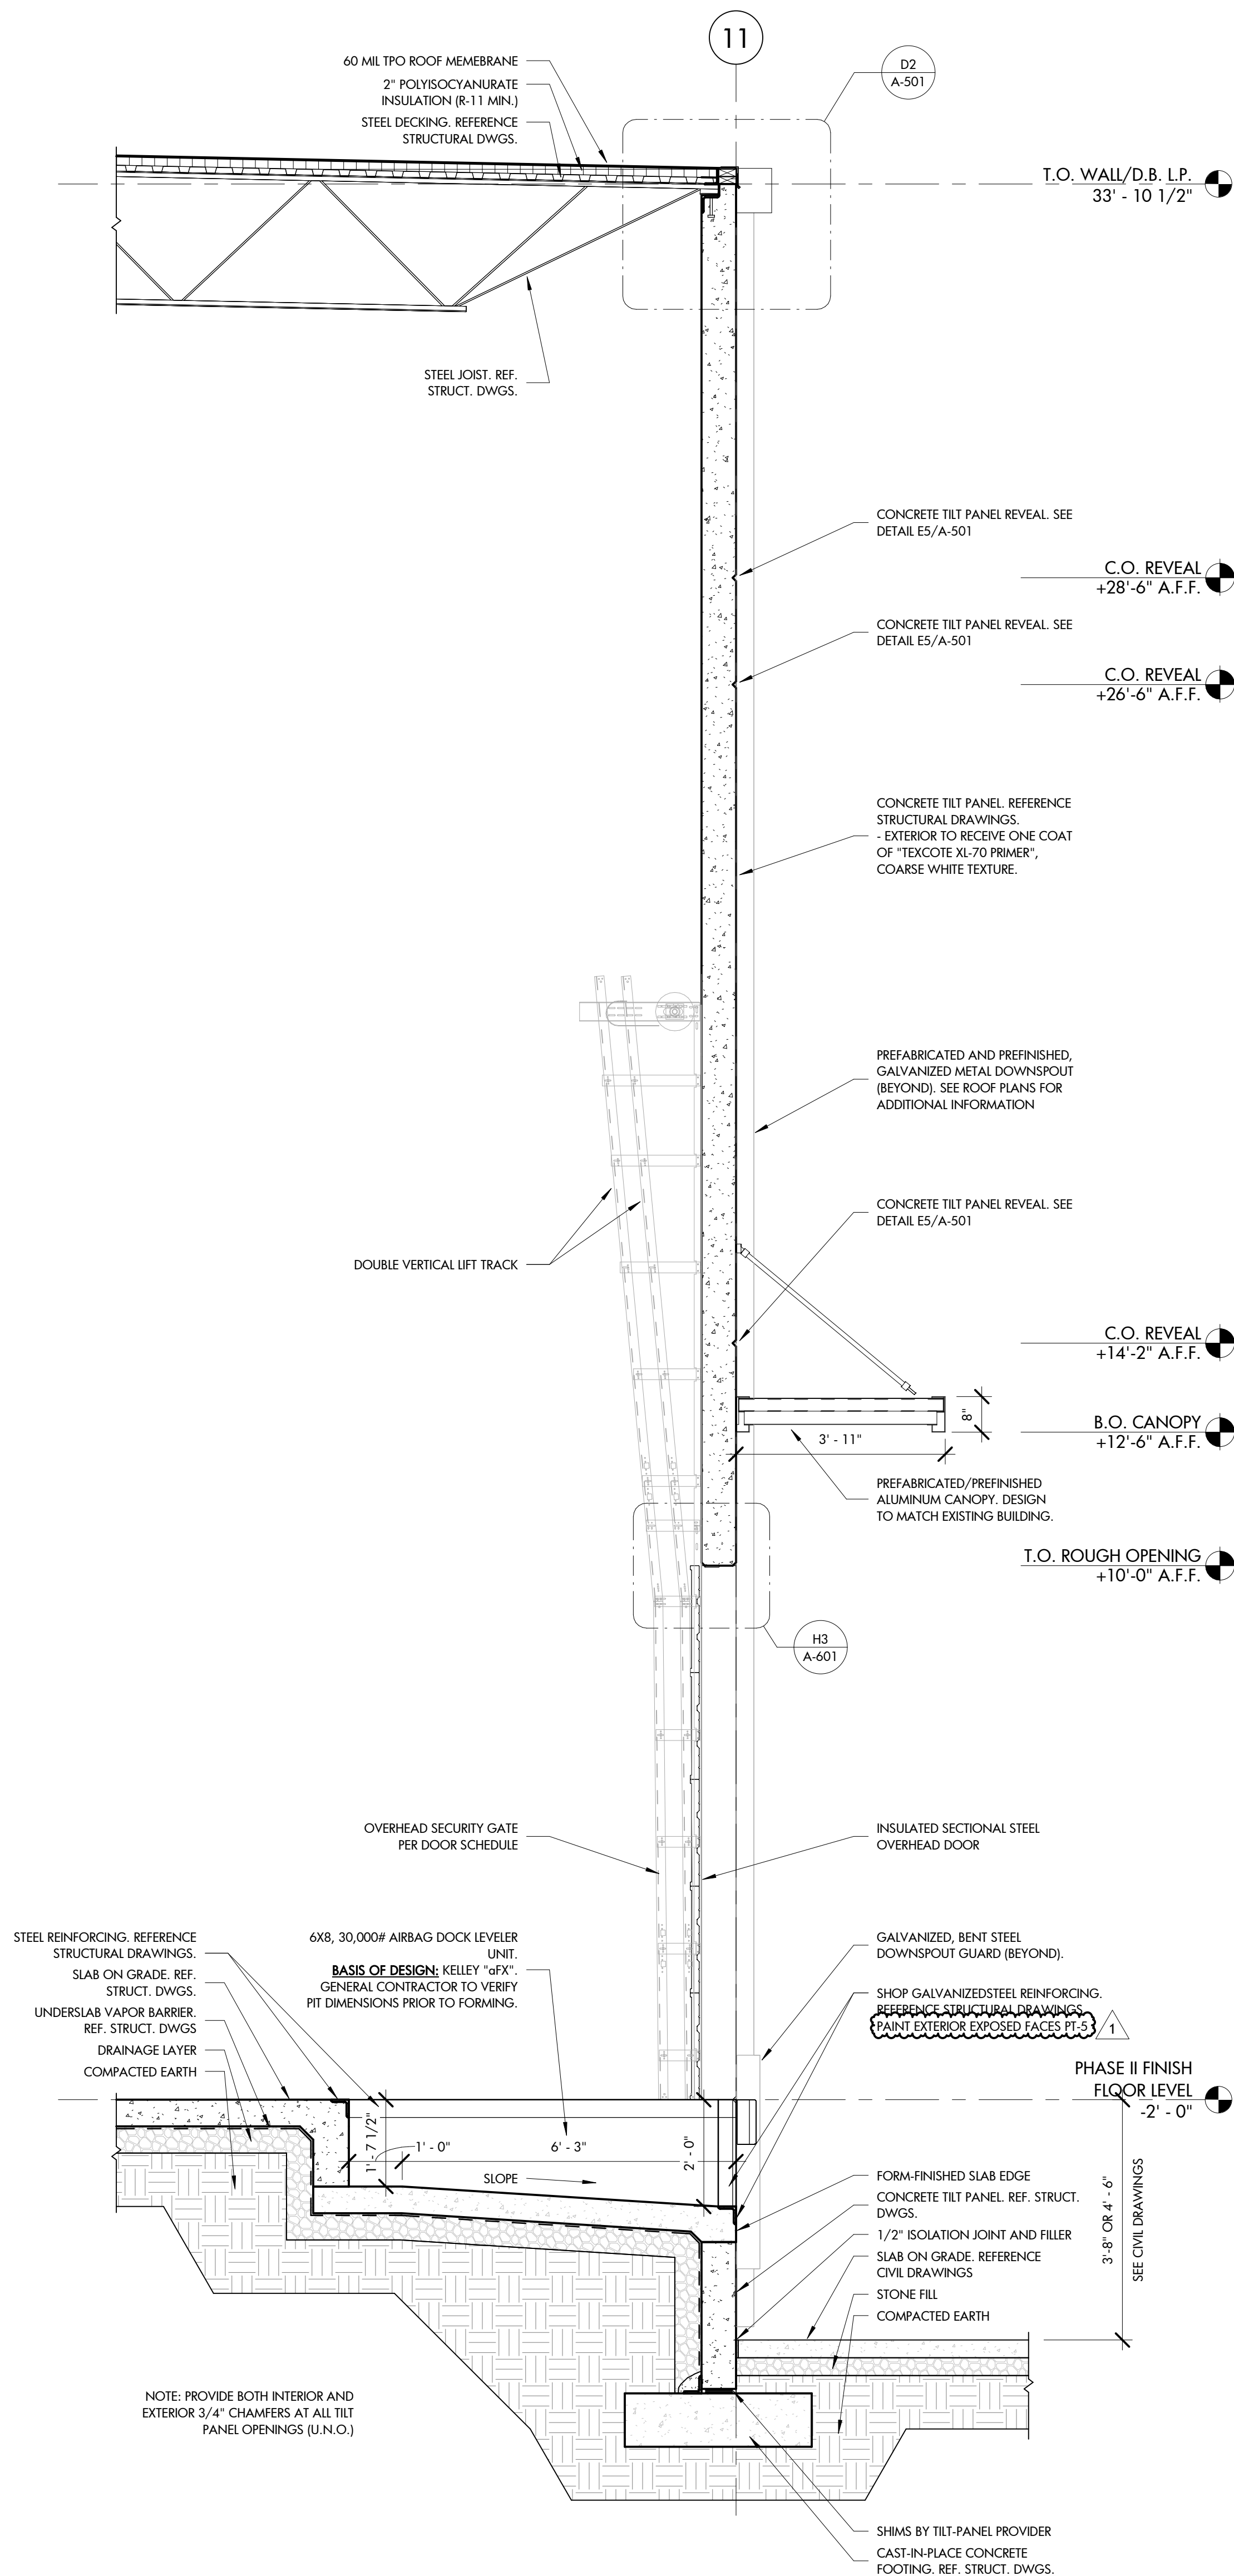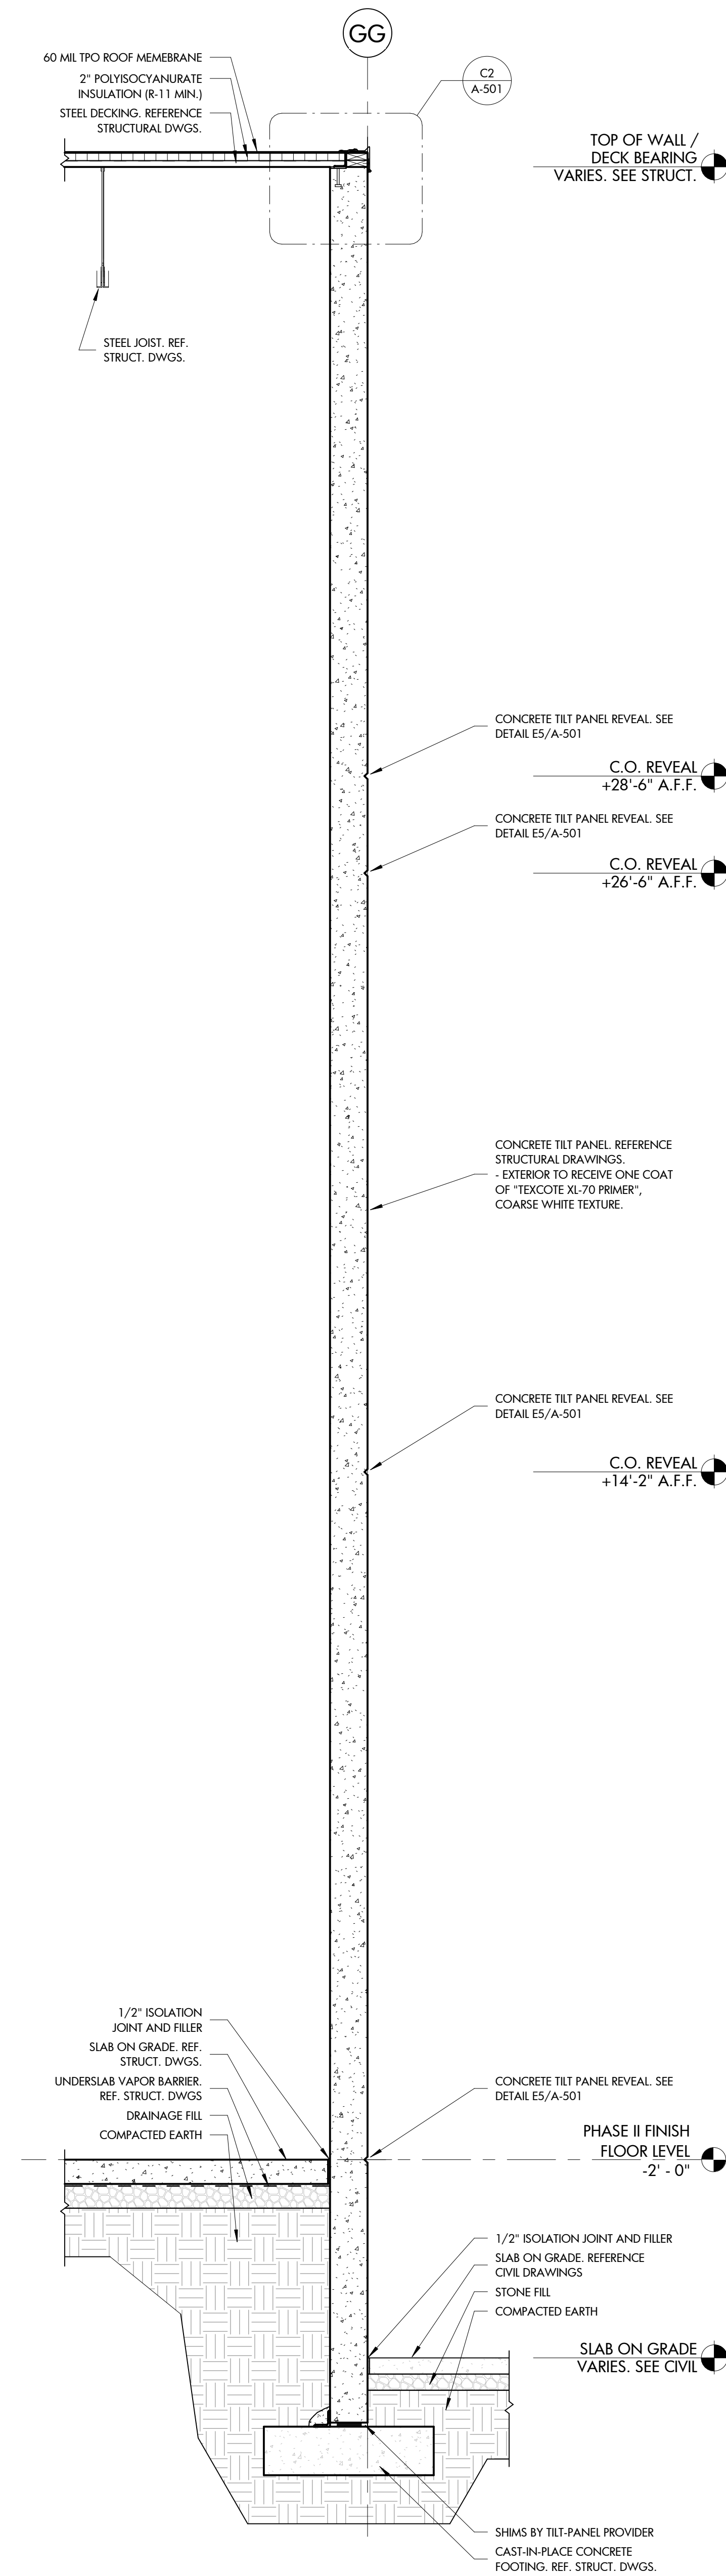

NUMBER	DESCRIPTION	DATE
1	BID DOCUMENTS	02/02/24



1. LIGHTS AND DIFFUSERS ARE SHOWN FOR LOCATION ONLY. REFERENCE ENGINEERING DRAWINGS FOR ADDITIONAL INFORMATION.
2. ALL SUSPENDED ACOUSTICAL CEILINGS ARE TO BE TYPE "AT-1" UNLESS NOTED OTHERWISE ON PLAN.
3. ALL CEILING GRID AND ACOUSTIC TILE INSTALLED CENTERED HORIZONTALLY AND VERTICALLY WITHIN A ROOM OR SPACE UNLESS NOTED OTHERWISE ON PLAN.
4. EDGE MOULDINGS AND TRIMS AT ACOUSTICAL DROP CEILING LOCATIONS TO BE CAULKED WHERE IT MEETS THE ADJACENT WALL.

ACOUSTICAL CEILING TILE (AT-1)

NOTE: MOUNTING HEIGHTS NOTED ARE TO BE USED ONLY WHEN MANUFACTURERS STANDARD MOUNTING HEIGHTS ARE NOT PROVIDED. ALL ACCESSORIES IN HANDICAP STALLS TO COMPLY WITH MANUFACTURER'S RECOMMENDED "BARRIER-FREE" MOUNTING HEIGHTS. SEE G-103.

THE FOLLOWING ACCESSORIES SHALL BE FURNISHED BY THE OWNER. THE GENERAL CONTRACTOR SHALL COORDINATE WHO IS RESPONSIBLE FOR INSTALLATION WITH THE OWNER.

- TOILET PAPER HOLDER
- SOAP DISPENSER
- PAPER TOWEL DISPENSER
- WASTE RECEPTACLE

- PROVIDE MOISTURE-RESISTANT GYPSUM WALL BOARD ON STUD PARTITIONS IN JANITOR'S CLOSET 104.
- ALL TOILET ROOM WET WALL STUD PARTITIONS TO RECEIVE CEMENT BACKER BOARD ("DUROCK" OR EQ.) TO 4'-0" A.F.F. AND MOISTURE RESISTANT GYPSUM WALL BOARD TO CEILING OR STRUCTURE ABOVE. WALLS TO BE COMPLETELY COVERED IN FIBERGLASS REINFORCED PANELS.
- ALL CONCRETE MASONRY UNIT WALLS TO RECEIVE EPOXY PAINT.

A. DO NOT SCALE DRAWINGS. ALL DIMENSIONS ARE TAKEN FROM FACE OF SHEATHING. TYPICAL ANY DIMENSIONS DEEMED QUESTIONABLE ARE TO BE VERIFIED BY THE ARCHITECT/DESIGNER.

B. COORDINATE WORK OF THIS TRADE WITH OTHER TRADES.

C. DOOR AND FRAME NUMBERS CORRESPOND TO ROOM NUMBERS. WHERE THERE IS MORE THAN ONE DOOR PER ROOM, A SUFFIX HAS BEEN ADDED - LETTERS "I" AND "O" HAVE BEEN OMITTED FOR CLARITY. SEE A-600 SERIES SHEETS FOR DOOR AND FRAME IDENTIFICATION.

 
 
 
D. APPLY SEALANT AT ALL JUNCTURES BETWEEN DIFFERENT MATERIALS, AT PLUMBING FITTERS AT JUNCTURE WITH WALL, AT ALL COUNTERTOPS/BACKSPLASH AT JUNCTURE WITH WALL AND WHERE INDICATED THROUGHOUT THESE DRAWINGS.

E. PROVIDE MISCELLANEOUS METAL SUPPORT FOR ALL THE CEILING SUSPENDED ITEMS AS REQUIRED.



F. ALL DOORS MUST BE INSTALLED WITH AT LEAST THE MINIMUM MANEUVERING CLEARANCES AT THE DOOR APPROACH PER THE MOST CURRENT VERSION OF THE AMERICANS WITH DISABILITIES ACT.

G. PROVIDE IN WALL BLOCKING AS REQUIRED FOR ALL SURFACE MOUNTED ITEMS.

- 1 JANITOR'S SINK. PROVIDE FIBERGLASS REINFORCED PLASTIC PAN FROM TOP OF SINK TO BOTTOM OF FAUCET ON BOTH WALLS ADJACENT TO THE SINK. PROVIDE 30" LONG FLEXIBLE HOSE AND HOSE CLAMP. SEE PUMPING DRAWINGS FOR ADDITIONAL INFORMATION.
- 2 CARD READER LOCATION. REFERENCE SHEET A-501 FOR DOOR HARDWARE INFORMATION.
- 3 6" DIA. CONCRETE FILL WITH HEAVY GAUGE STEEL PIPE BOLLARD. 42" TALL. SEE DETAIL A5-1.
- 4 PREFINISHED AND PREHABITATED GARD RAIL SYSTEM, YELLOW FINISH. PROVIDE "HERVIN SAFETY" TRANSPARENT BARRIER GUARDRAIL. PROVIDE APPROVED ALTERNATE "A" TALL CAST-IN-PLACE CONCRETE PAD. G.C. TO COORDINATE AGAINST FINAL SWITCHGEAR SELECTION.
- 5 DOWNPOUT/STATION LOCATION. REFERENCE A-102 FOR ADDITIONAL INFORMATION. SEE A-1/501 FOR GUARD PROTECTION DETAILS.
- 6 CHARGING STATIONS BY OWNER. SHOWN FOR REFERENCE ONLY.
- 7 BELOW-GRADE SEWAGE LIFT STATION. REFERENCE PUMPING DRAWINGS FOR ADDITIONAL INFORMATION.
- 8 TRANSFORMER LOCATION. REFERENCE ELECTRICAL AND CIVIL DRAWINGS FOR ADDITIONAL INFORMATION.
- 9 GENERATOR LOCATION. REFERENCE ELECTRICAL DRAWINGS FOR ADDITIONAL INFORMATION.
- 10 PROPOSED INTERMEDIATE DISTRIBUTION FRAME (IDF) CABINET LOCATION. GENERAL CONTRACTOR TO DETERMINE FINAL LOCATION WITH OWNER. SEE ELECTRICAL DRAWINGS FOR ADDITIONAL INFORMATION.
- 11 DUCK STAIR LOCATION. SEE DETAIL A45A-1/501.
- 12 FIRE RISER LOCATION. REFERENCE BASIS OF DESIGN FIRE SPRINKLER DRAWINGS FOR ADDITIONAL INFORMATION. SEE A3/A-501 FOR GUARD PROTECTION DETAILS.
- 13 øx8, 30,000# AIRBAG DUCK LEVELER UNIT. **BASE OF DESIGN**. KELLEY "CIVIL"



EXISTING FLOOR
0' - 0"

  

PROJECT 288-000-000

901 Rooms to Go Way
Dunn, NC 28334

CONSULTANTS



1101 Haynes Street Suite 207
Raleigh, NC 27604
tel 919 821 7146 www.fuhrerreed.com



BASS | NIXON | KENNEDY
CONSULTING ENGINEERS
ENGINEERING FIRM NUMBER: C-0110
6310 CHAPEL HILL ROAD, SUITE 250
RALEIGH, N.C. 27607
P.919.851.4422 BNKINC.COM

CLIENT



901 Rooms to Go Way
Dunn, NC 28334
(910) 292-3505


DRAWING TITLE

ENLARGED PLANS AND ELEVATIONS


REVISIONS		
NUMBER	DESCRIPTION	DATE
1	BID DOCUMENTS	02/02/24

DRAWN BY **KRT**
CHECKED BY **BDG**
DATE ISSUED **12/18/23** OF


A-401

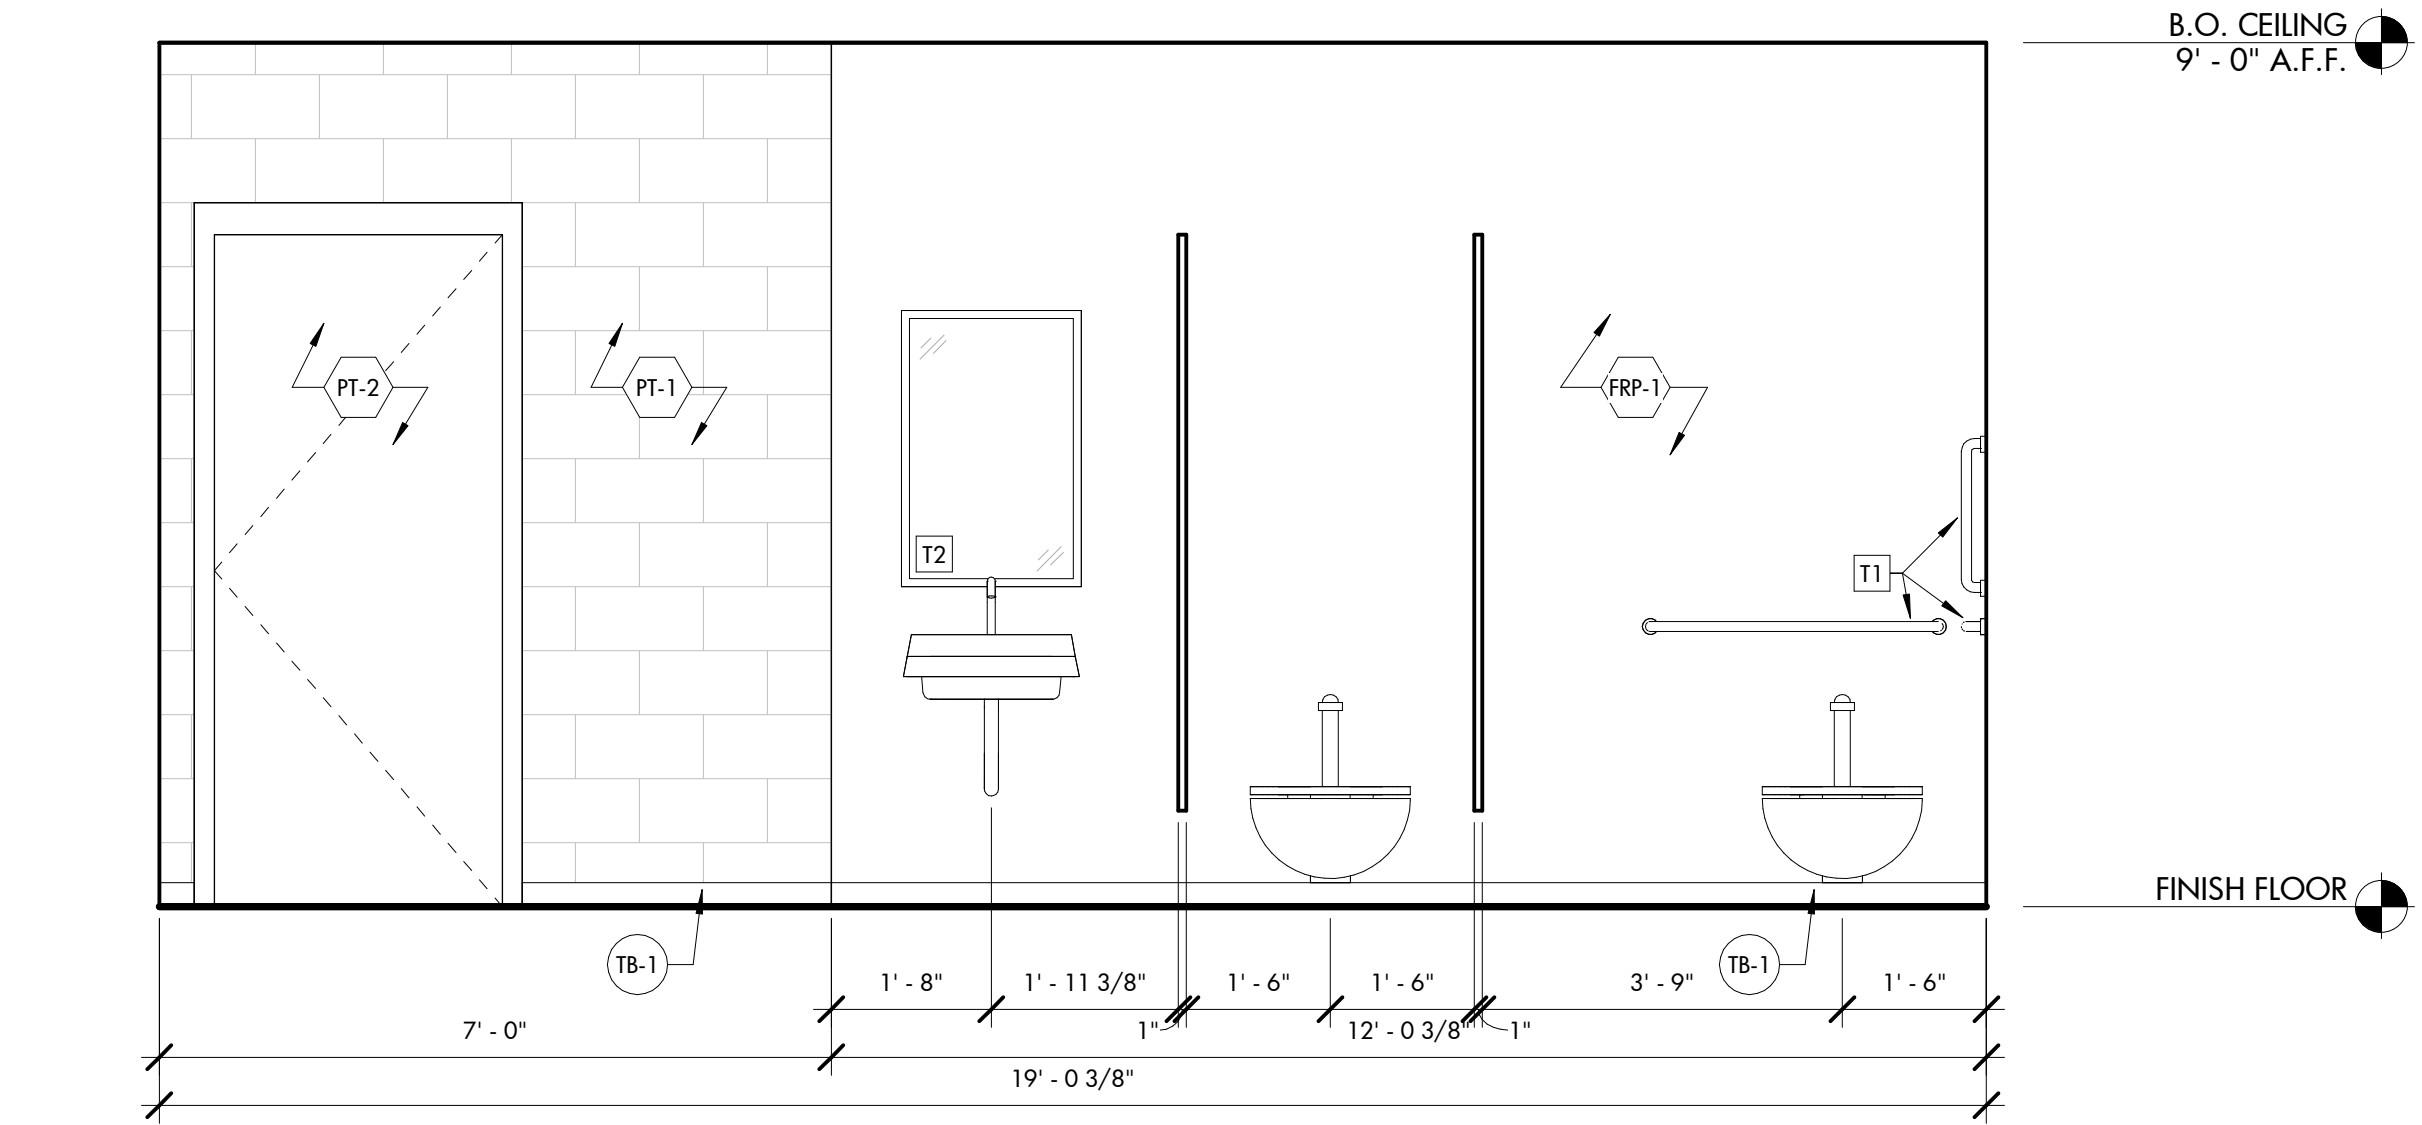


E1 WOMEN'S RR 102 INTERIOR ELEVATION
1/2" = 1'-0"

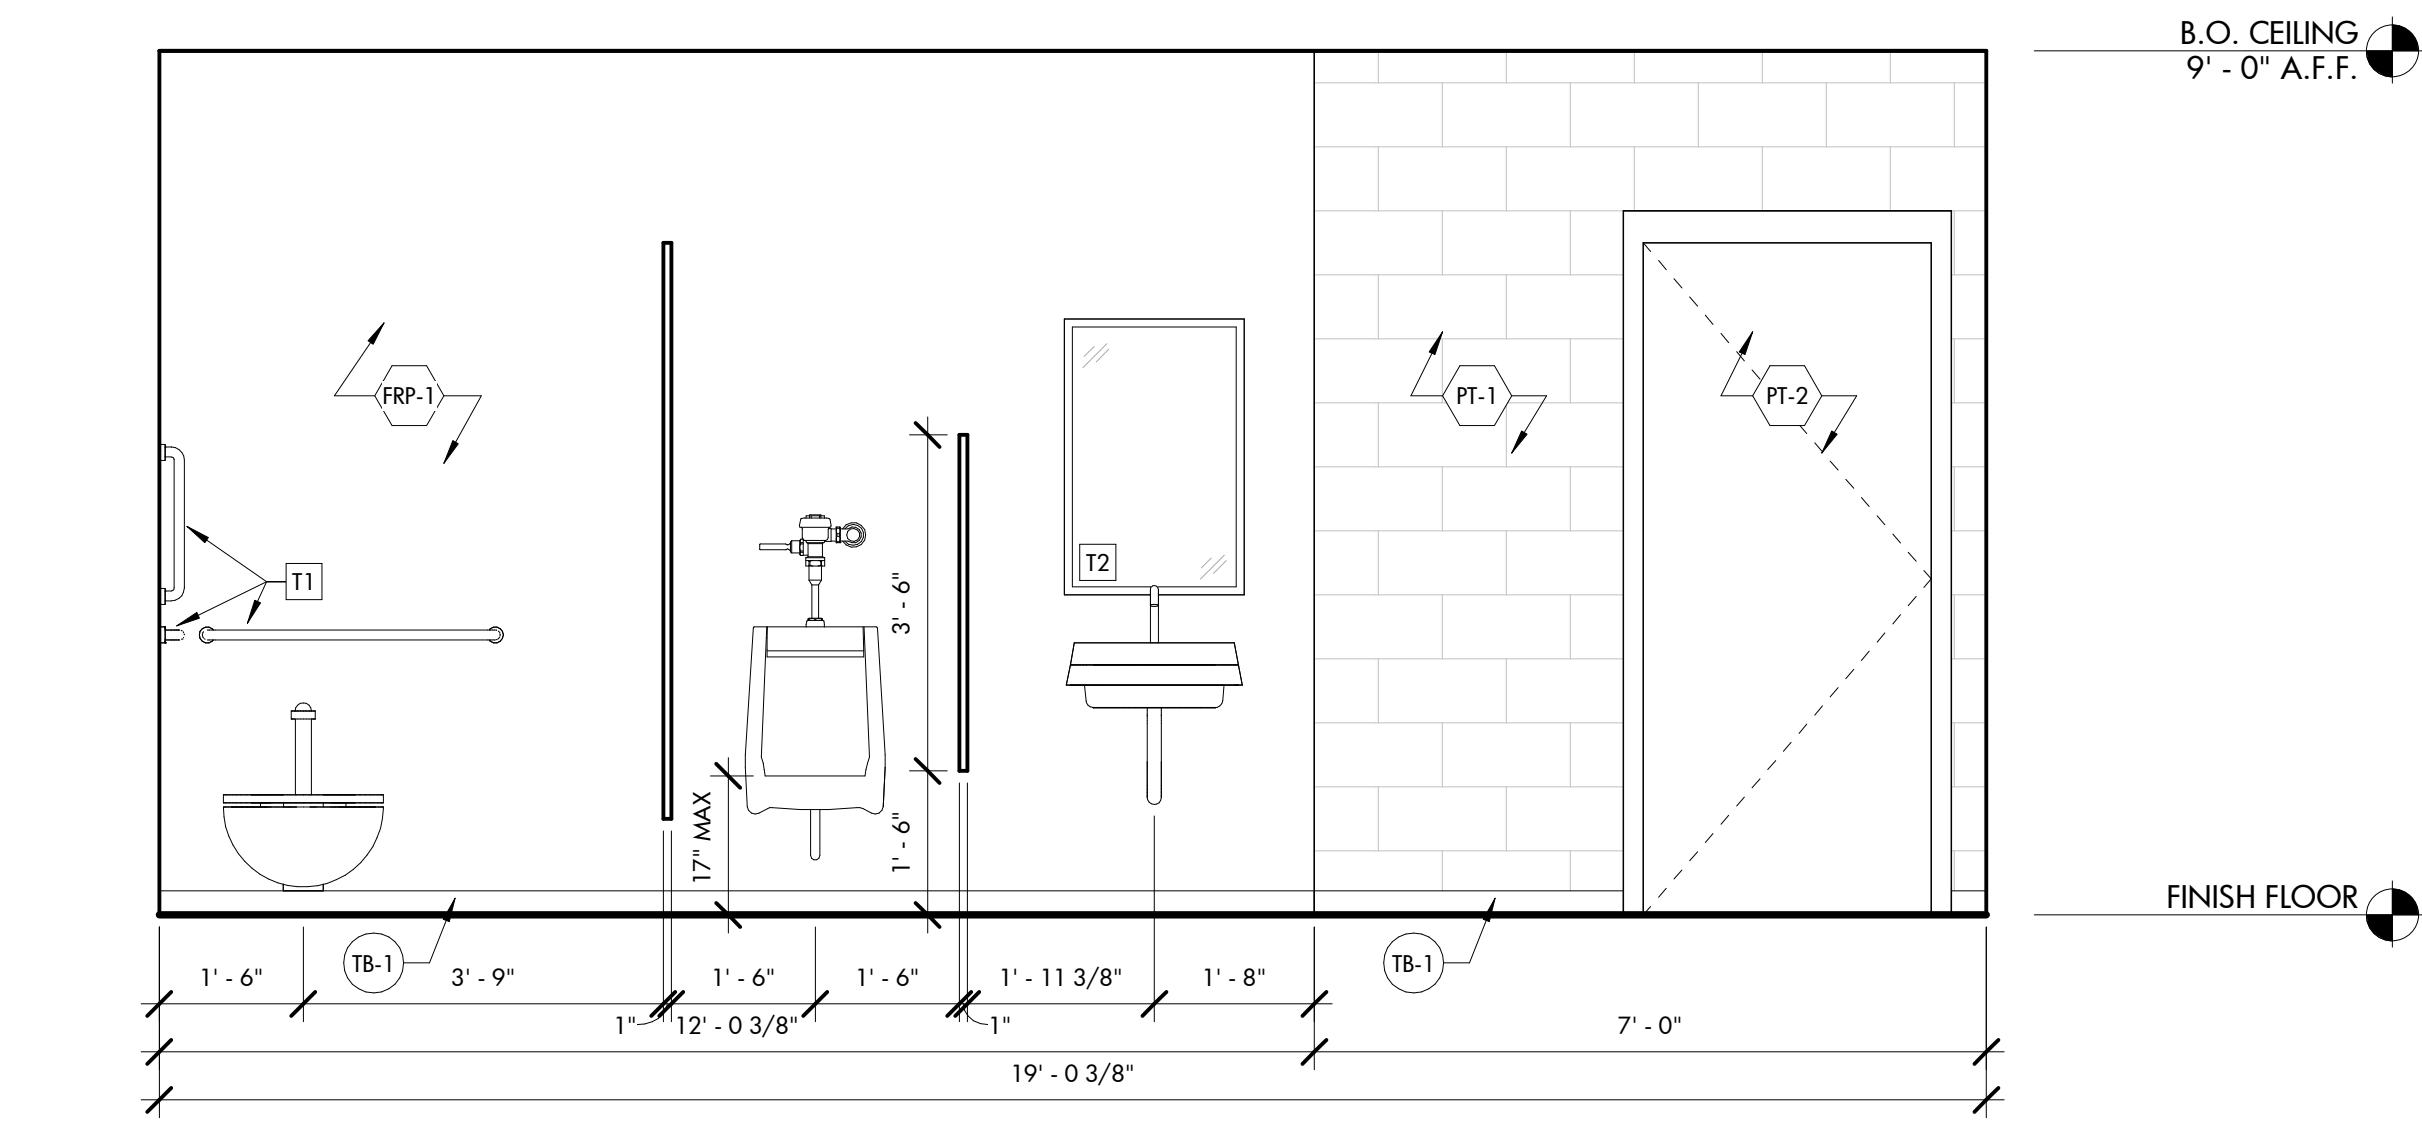


D1 MEN'S RR 103 INTERIOR ELEVATION
1/2" = 1'-0"

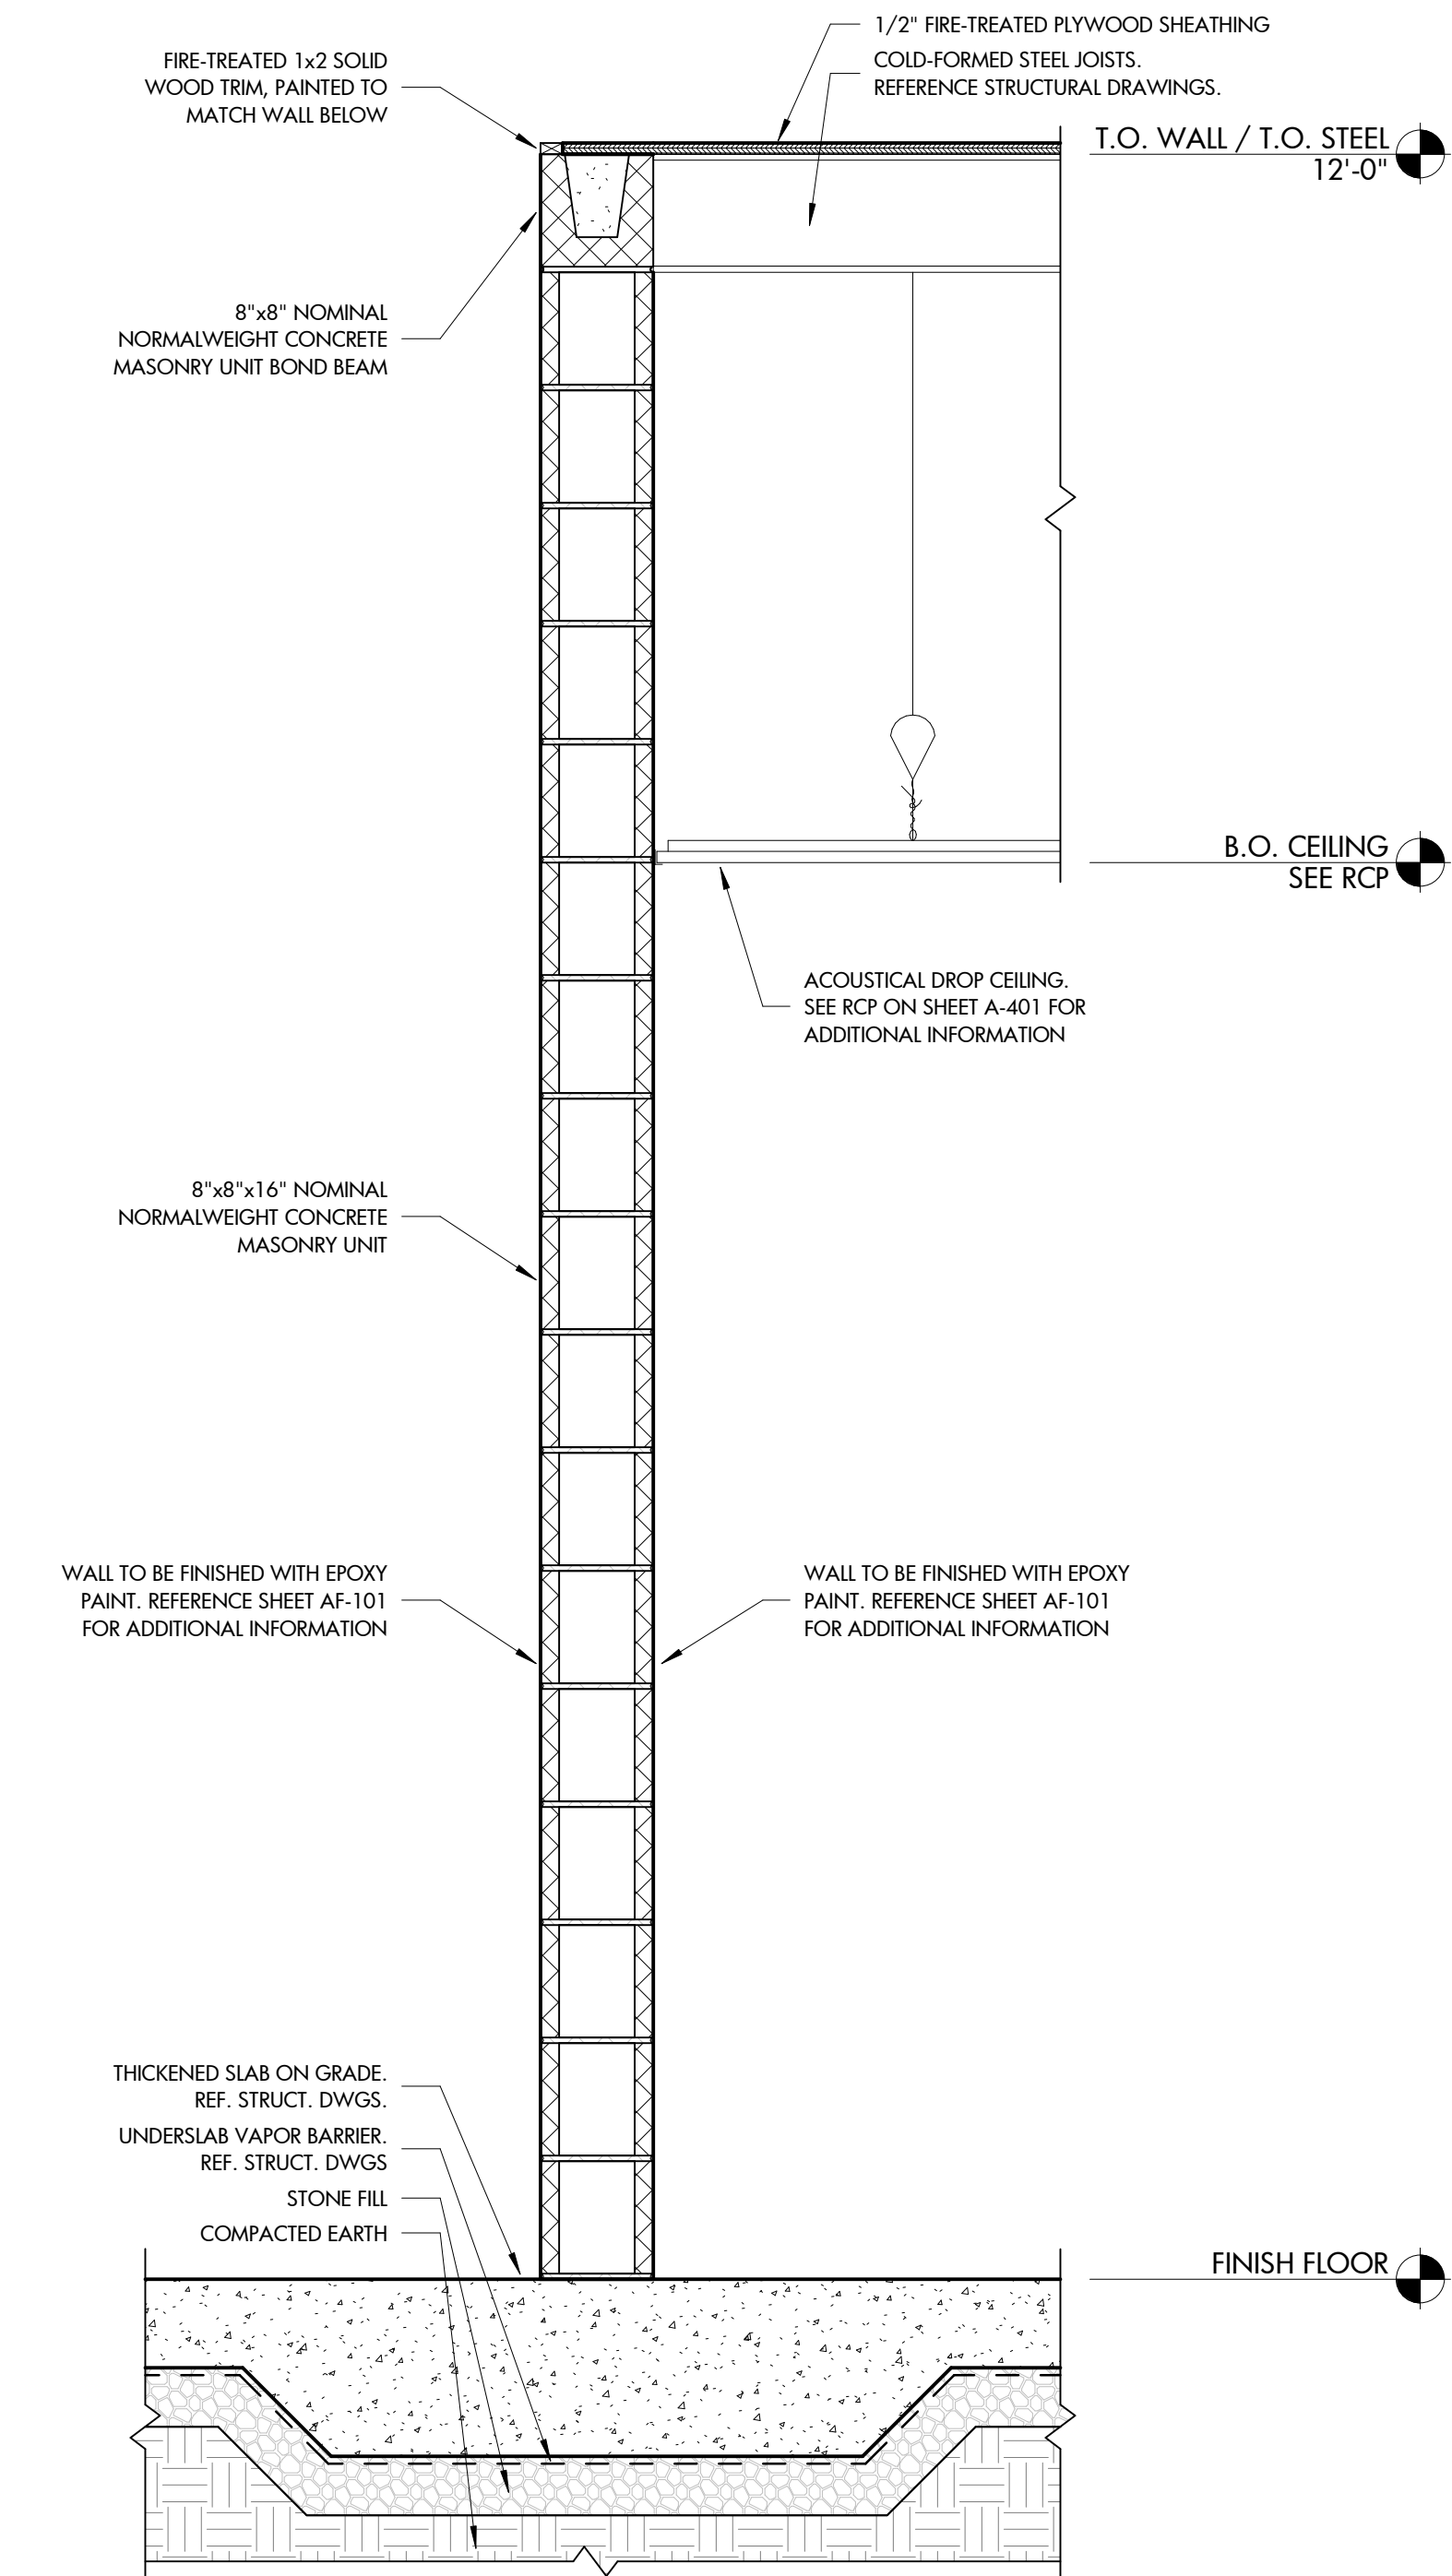


A1 INTERIOR WALL SECTION
1" = 1'-0"

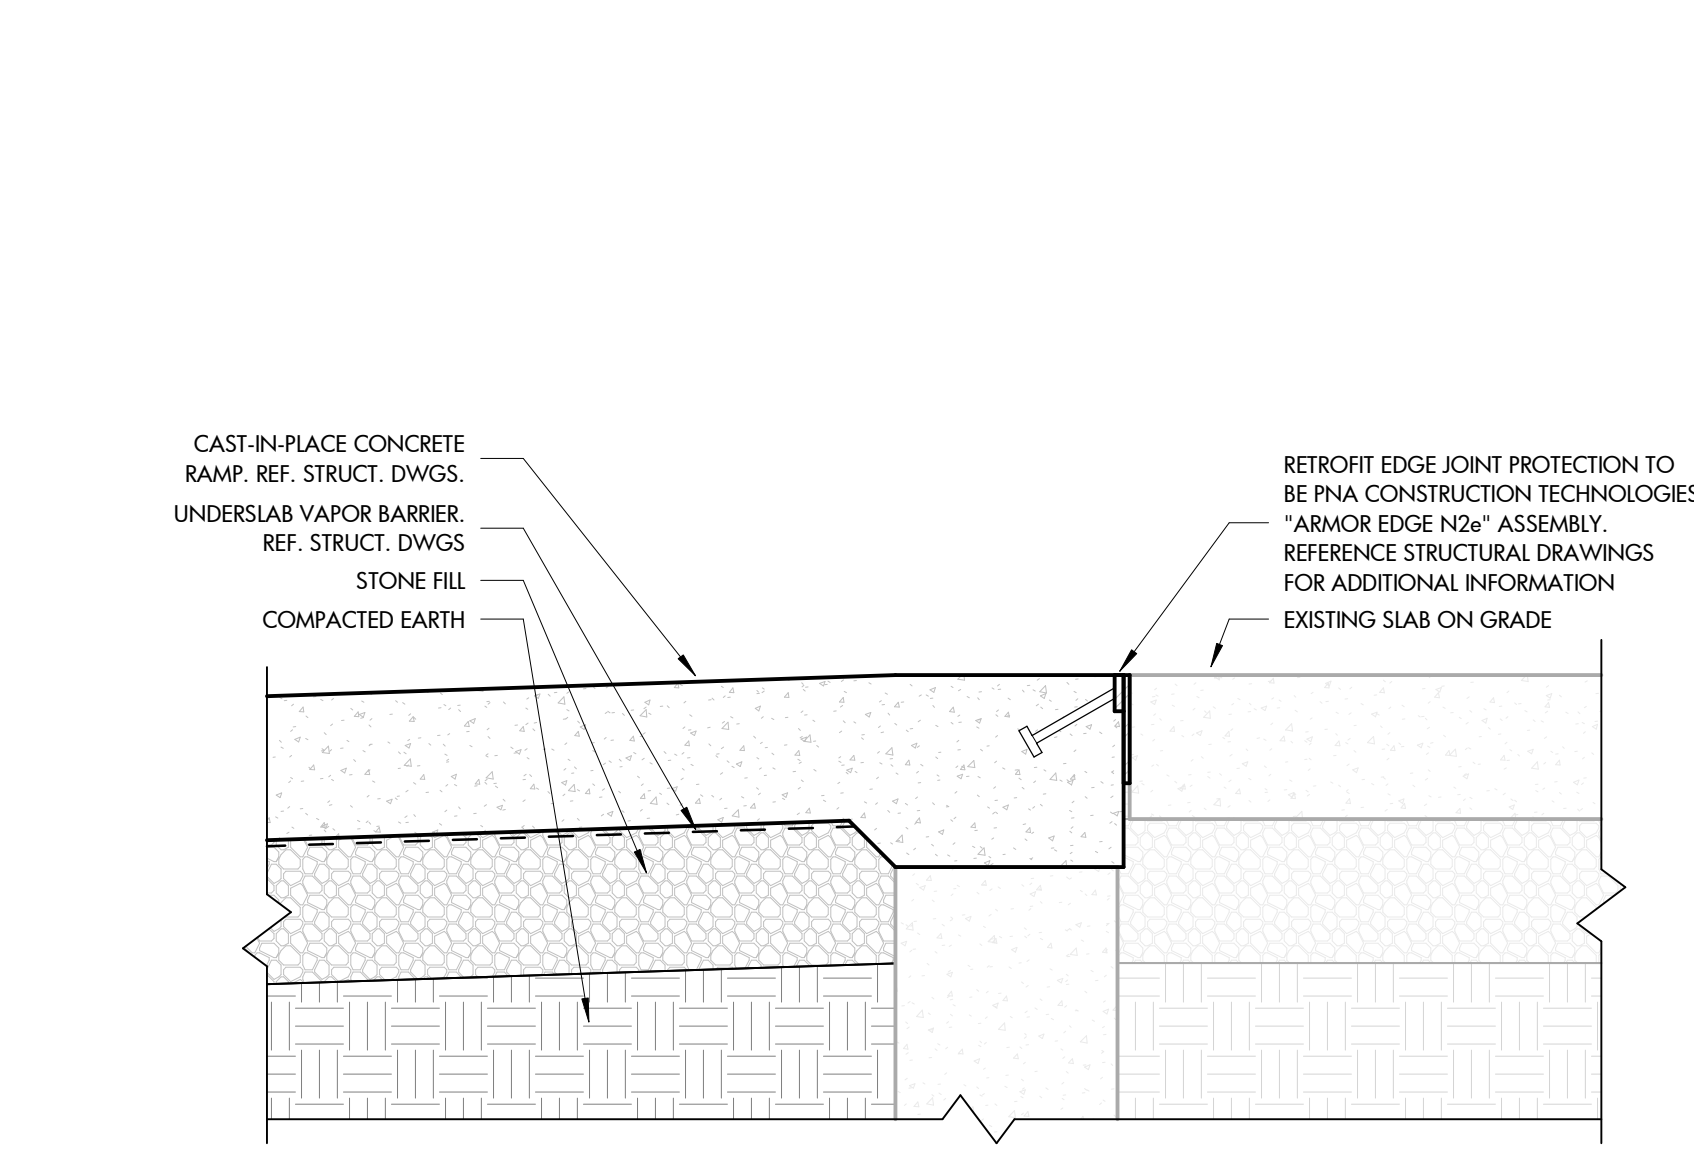


B2 RAMP SECTION
1 1/2" = 1'-0"

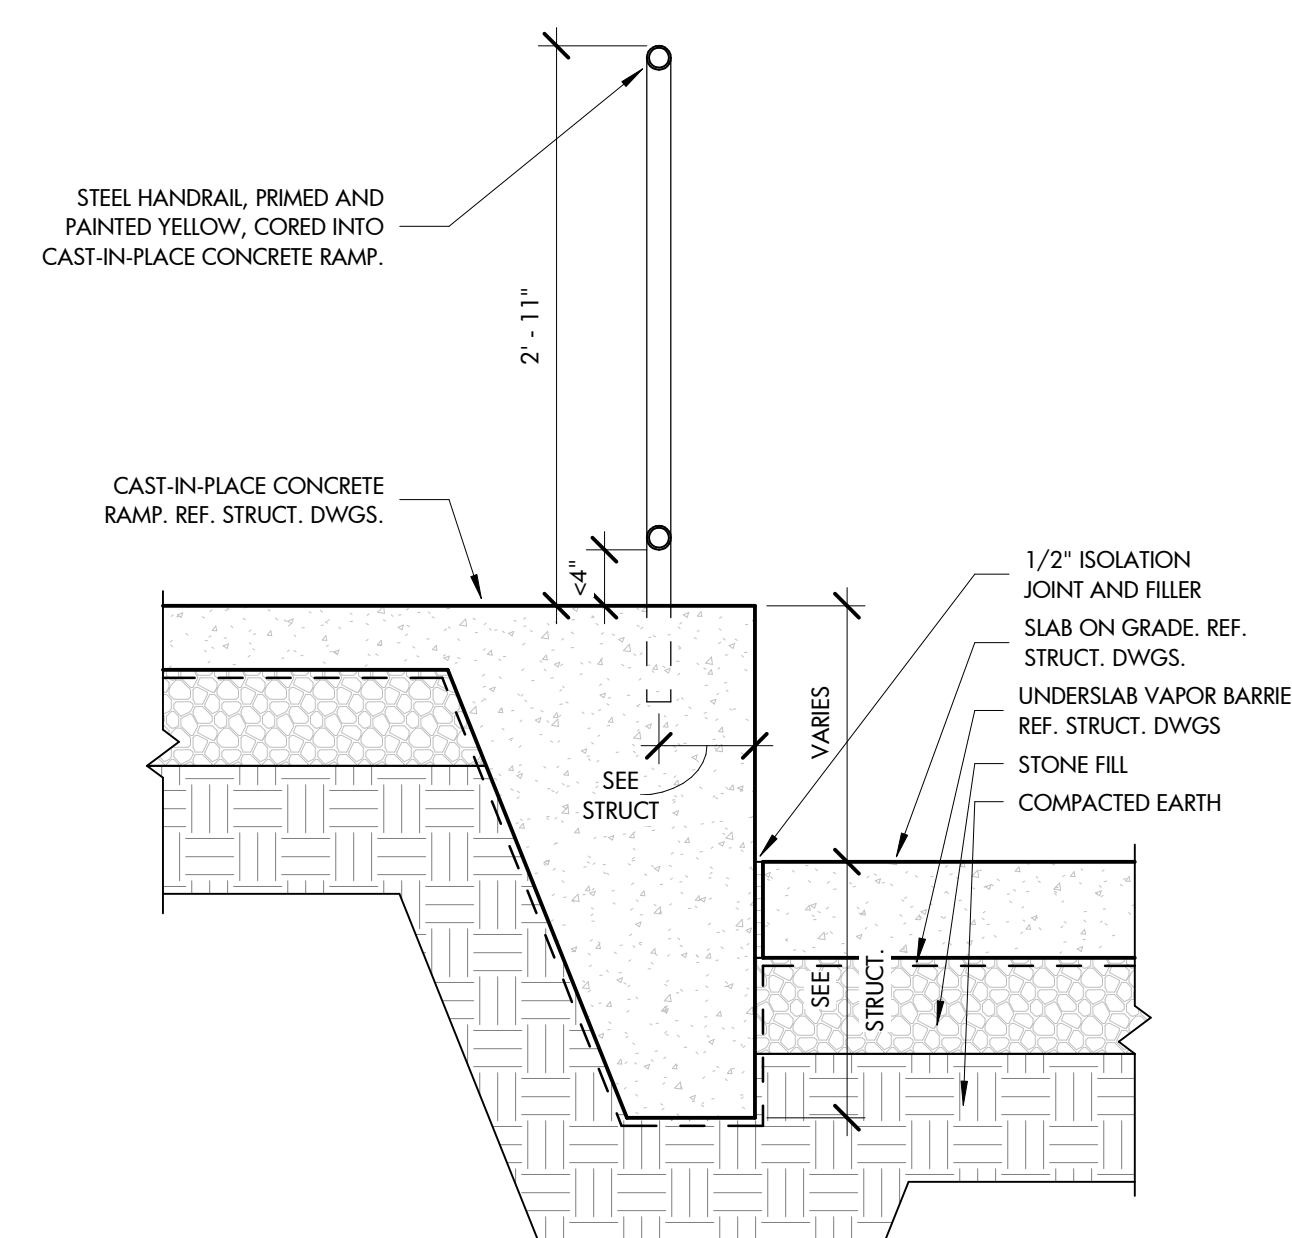

A2 RAMP SECTION
1" = 1'-0"

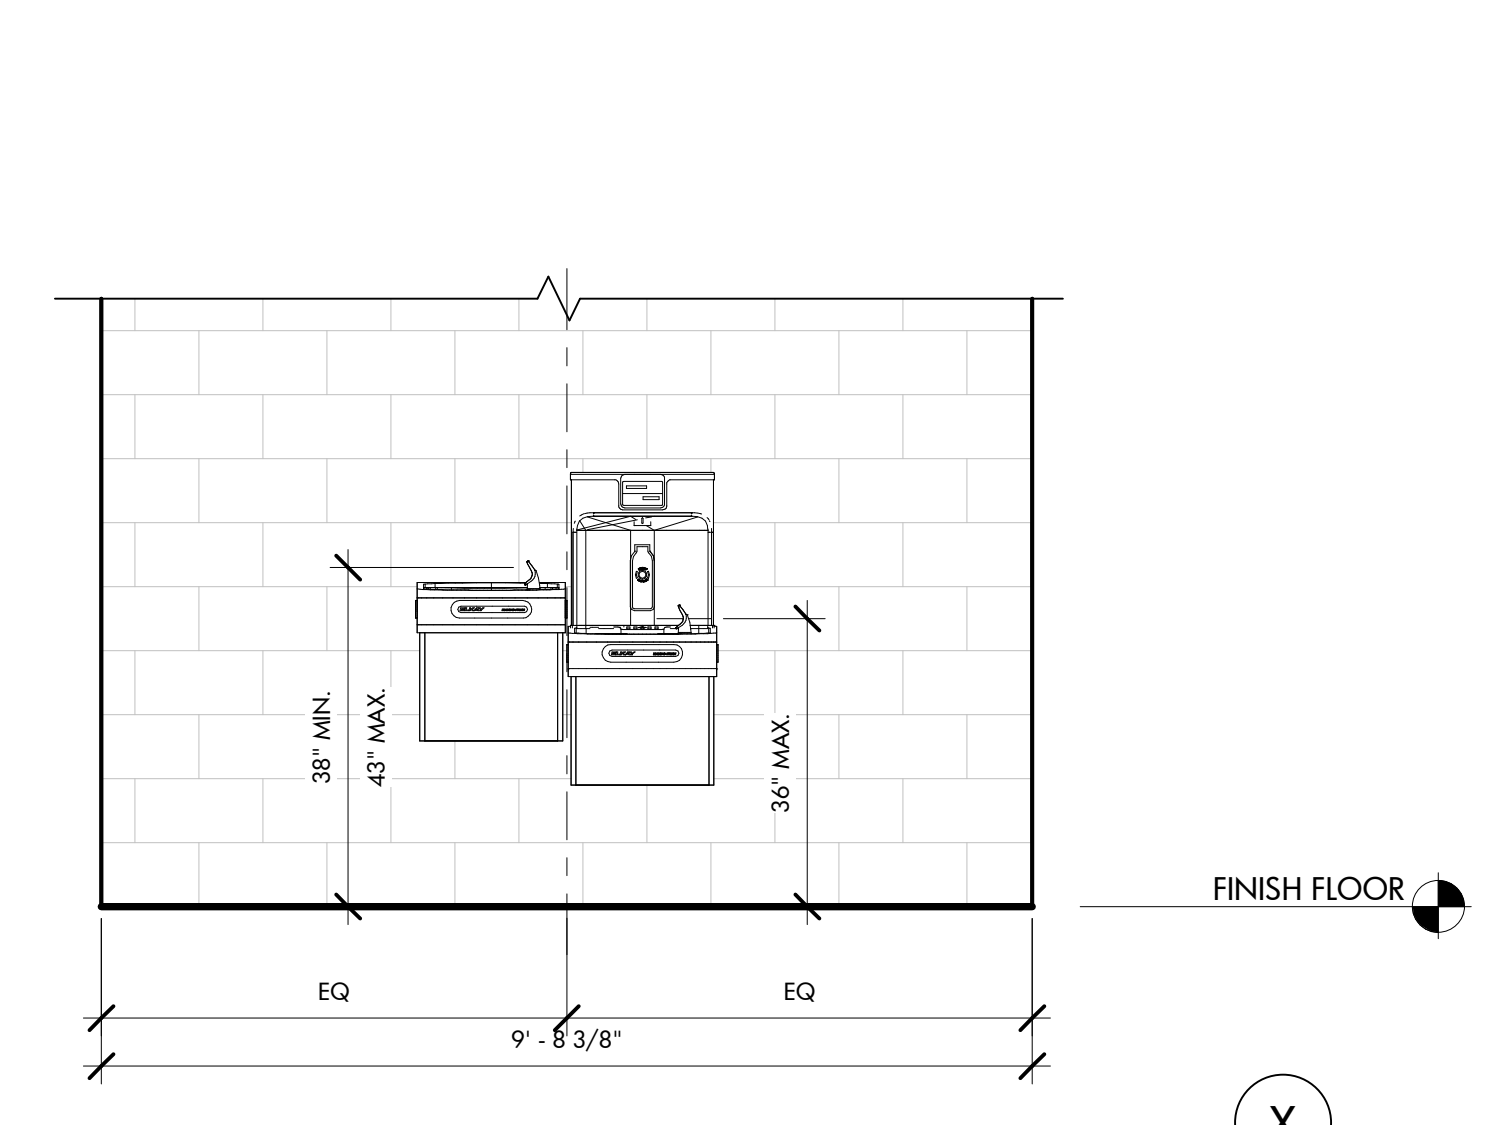


E2 DRINKING FOUNTAIN
1/2" = 1'-0"

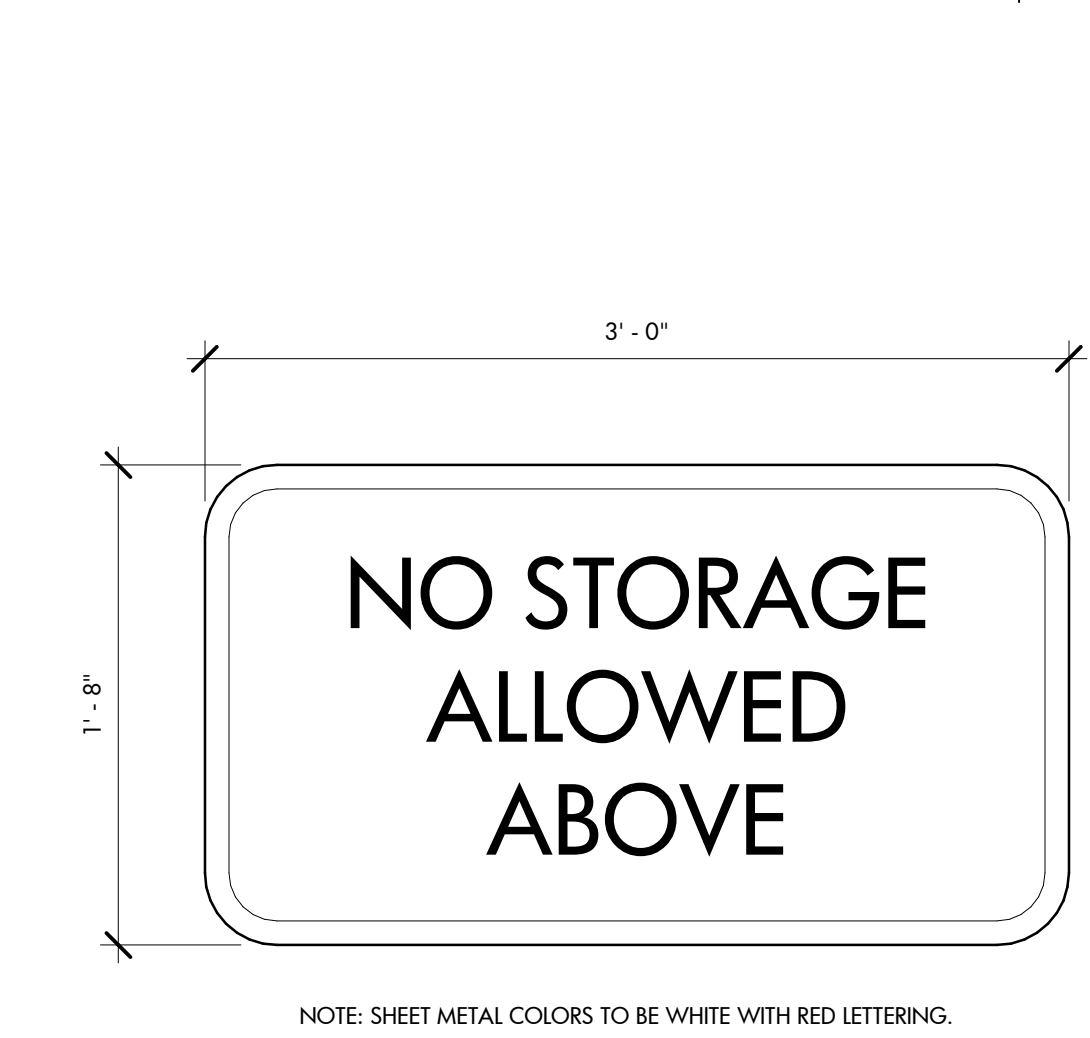


D2 "NO STORAGE ALLOWED" SIGNAGE
1 1/2" = 1'-0"

RESTROOM ACCESSORY LEGEND		
NOTE: MOUNTING HEIGHTS NOTED ARE TO BE USED ONLY WHEN MANUFACTURERS STANDARD MOUNTING HEIGHTS ARE NOT PROVIDED. ALL ACCESSORIES IN HANDICAP STALLS TO COMPLY WITH MANUFACTURER'S RECOMMENDED "BARRIER-FREE" MOUNTING HEIGHTS. SEE G-103.		
NO.	DESCRIPTION	MFR / PART #
T1	GRAB BARS - 18", 36" & 42"	BOBRICK: B-6806 x18, x36, x42
T2	24"x48" MIRROR GLASS	BOBRICK: B-290 2448
THE FOLLOWING ACCESSORIES SHALL BE FURNISHED BY THE OWNER. THE GENERAL CONTRACTOR SHALL COORDINATE WHO IS RESPONSIBLE FOR INSTALLATION WITH THE OWNER.		
- TOILET PAPER HOLDER		
- SOAP DISPENSER		
- PAPER TOWEL DISPENSER		
- WASTE RECEPTACLE		


FINISH SCHEDULE
SEE SHEET AF-101 FOR FINISH SCHEDULE

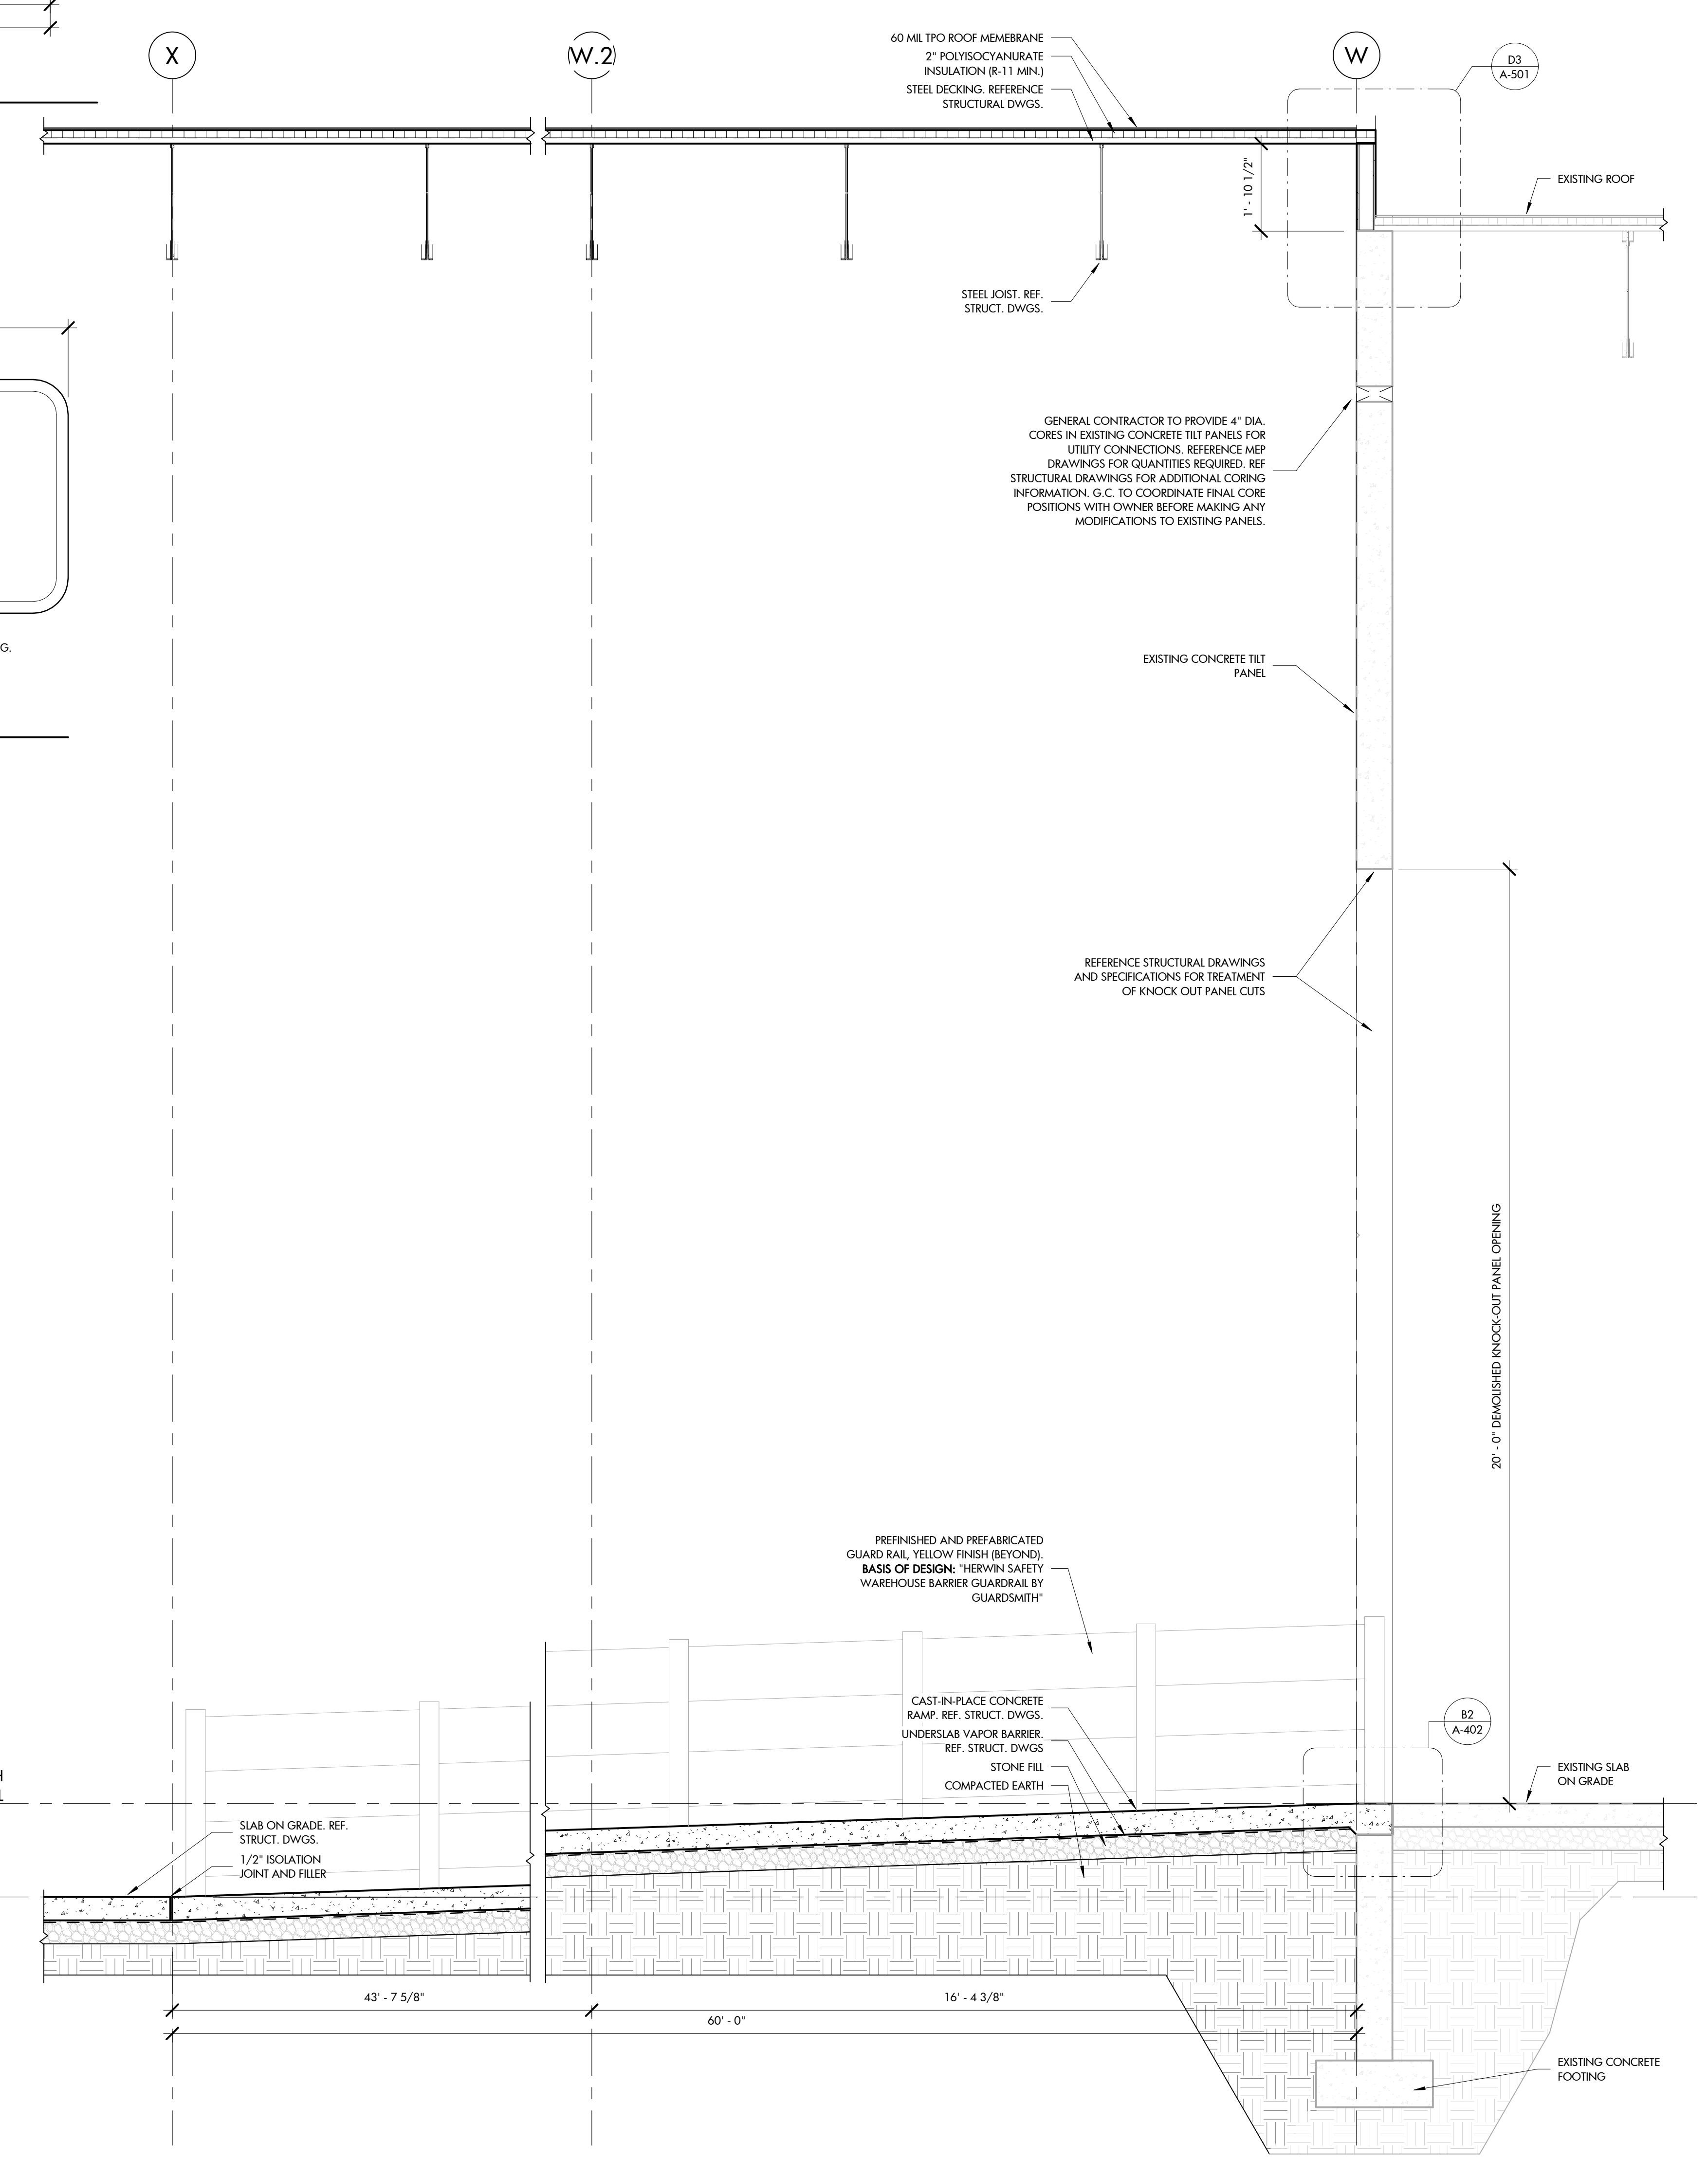


A3 RAMP SECTION
1/2" = 1'-0"

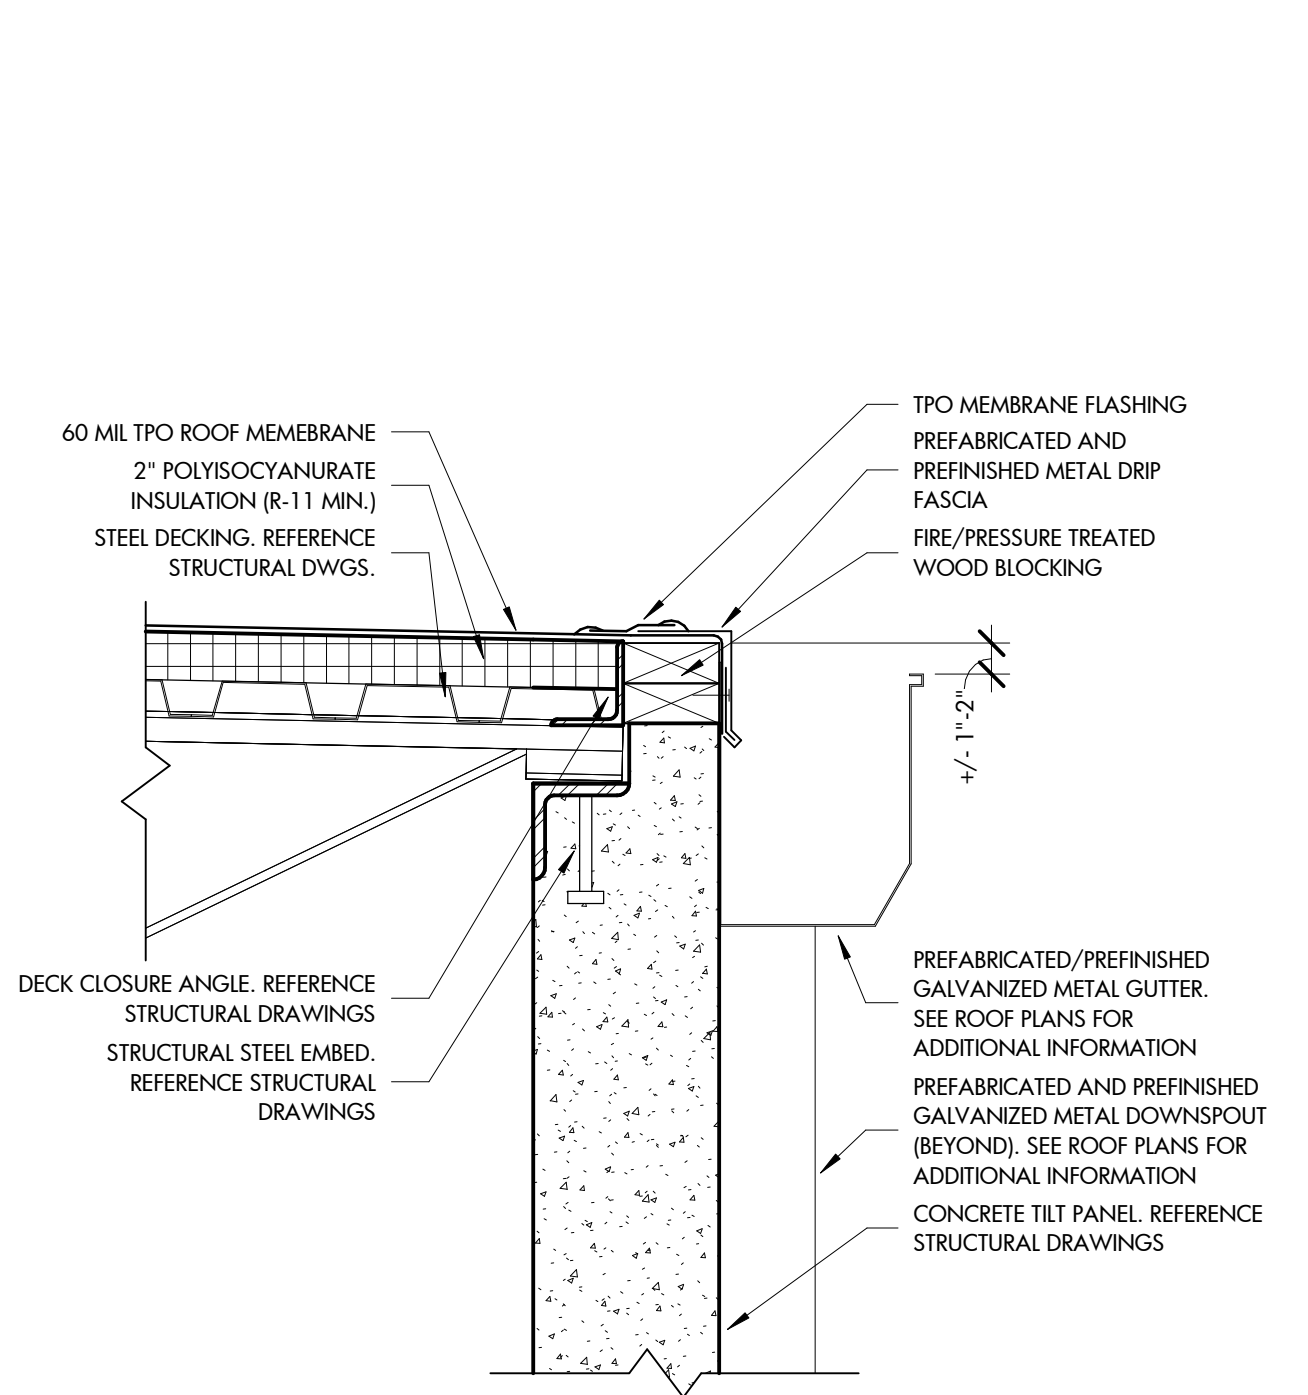


D2 TOP OF WALL DETAIL
1 1/2" = 1'-0"

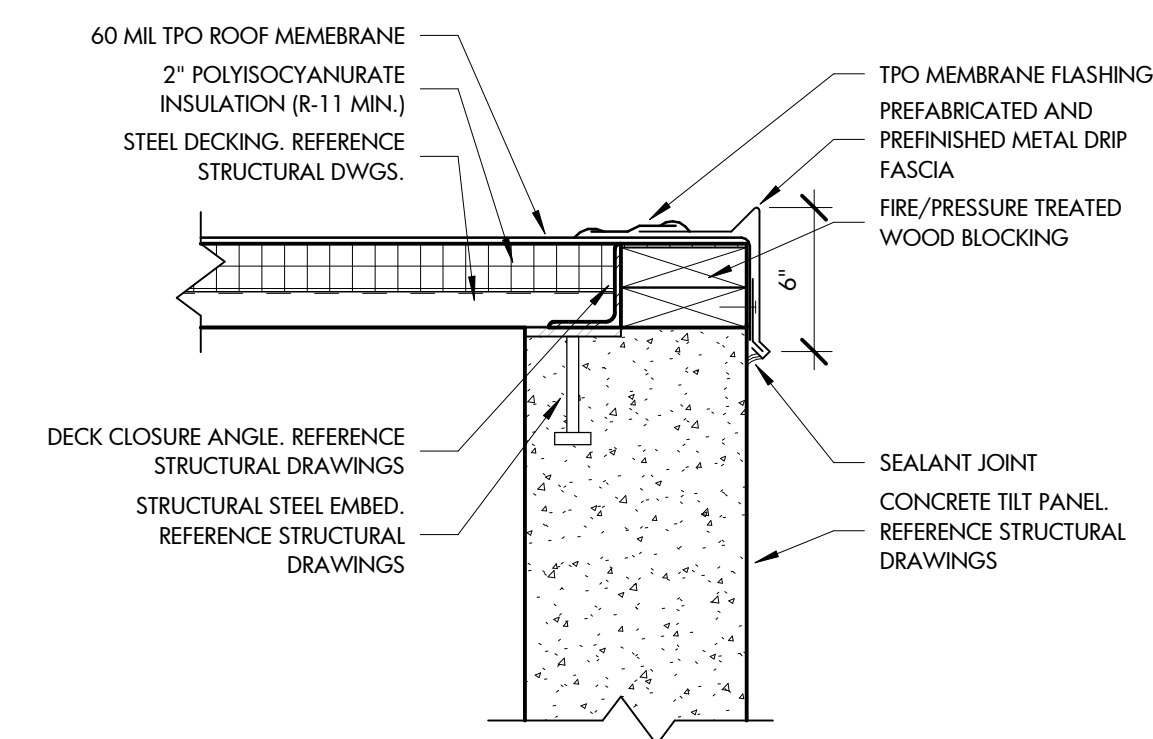


C2 TOP OF WALL DETAIL
1 1/2" = 1'-0"

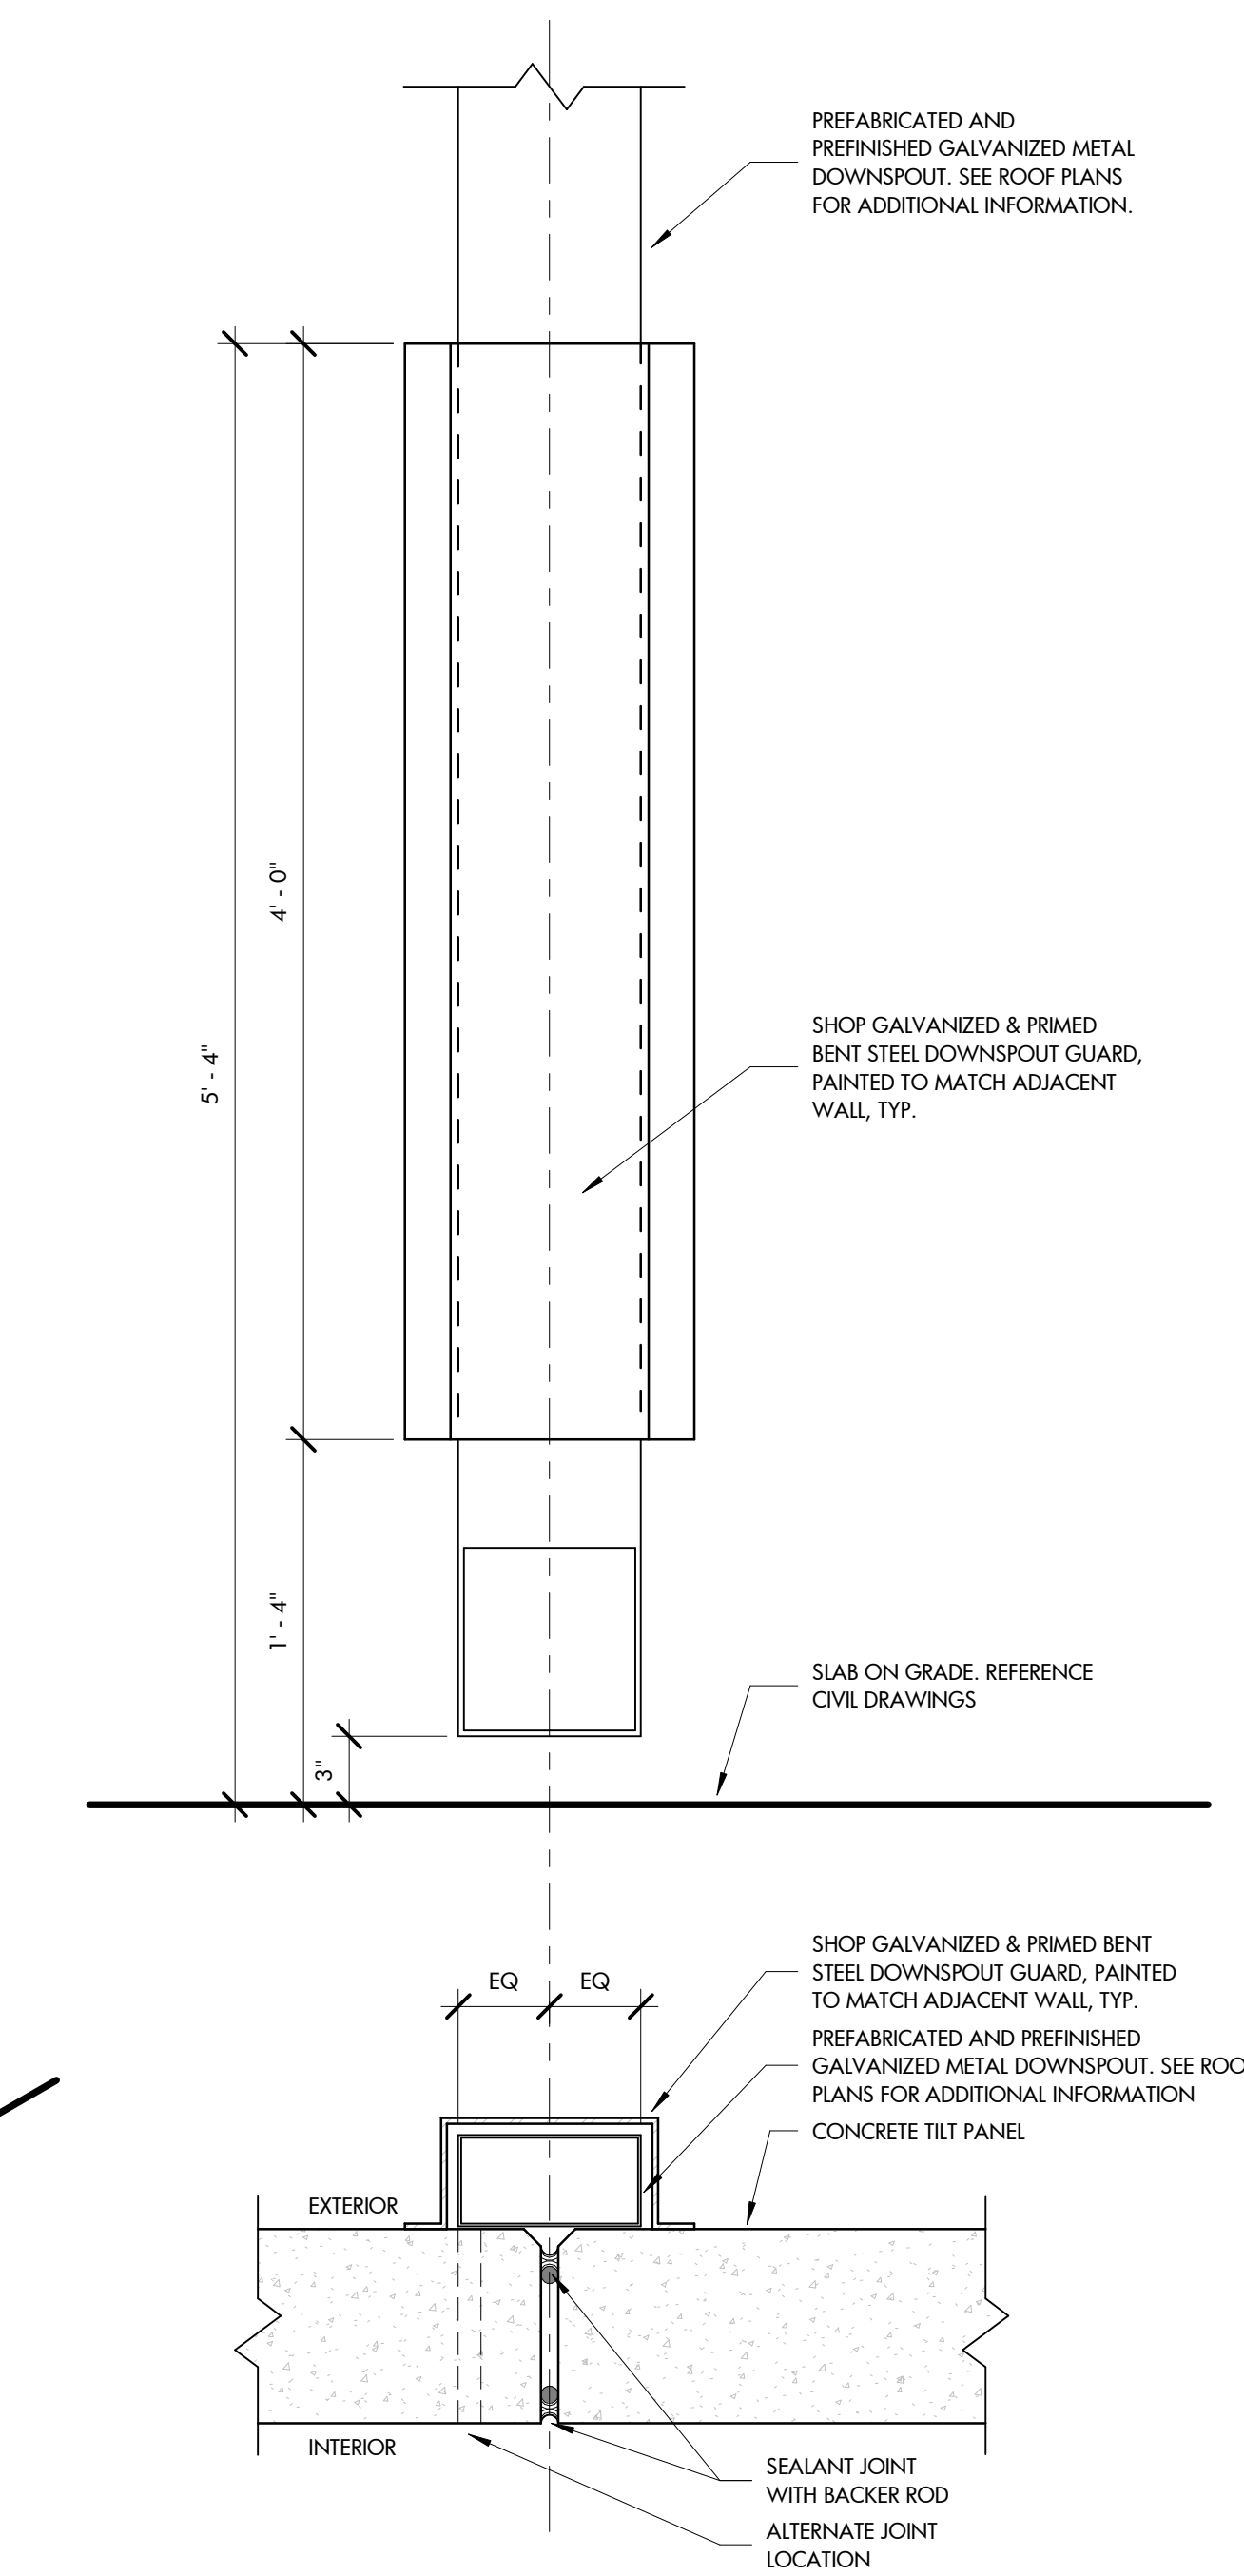


A1 DOWNSPOUT GUARD PROTECTION
1 1/2" = 1'-0"

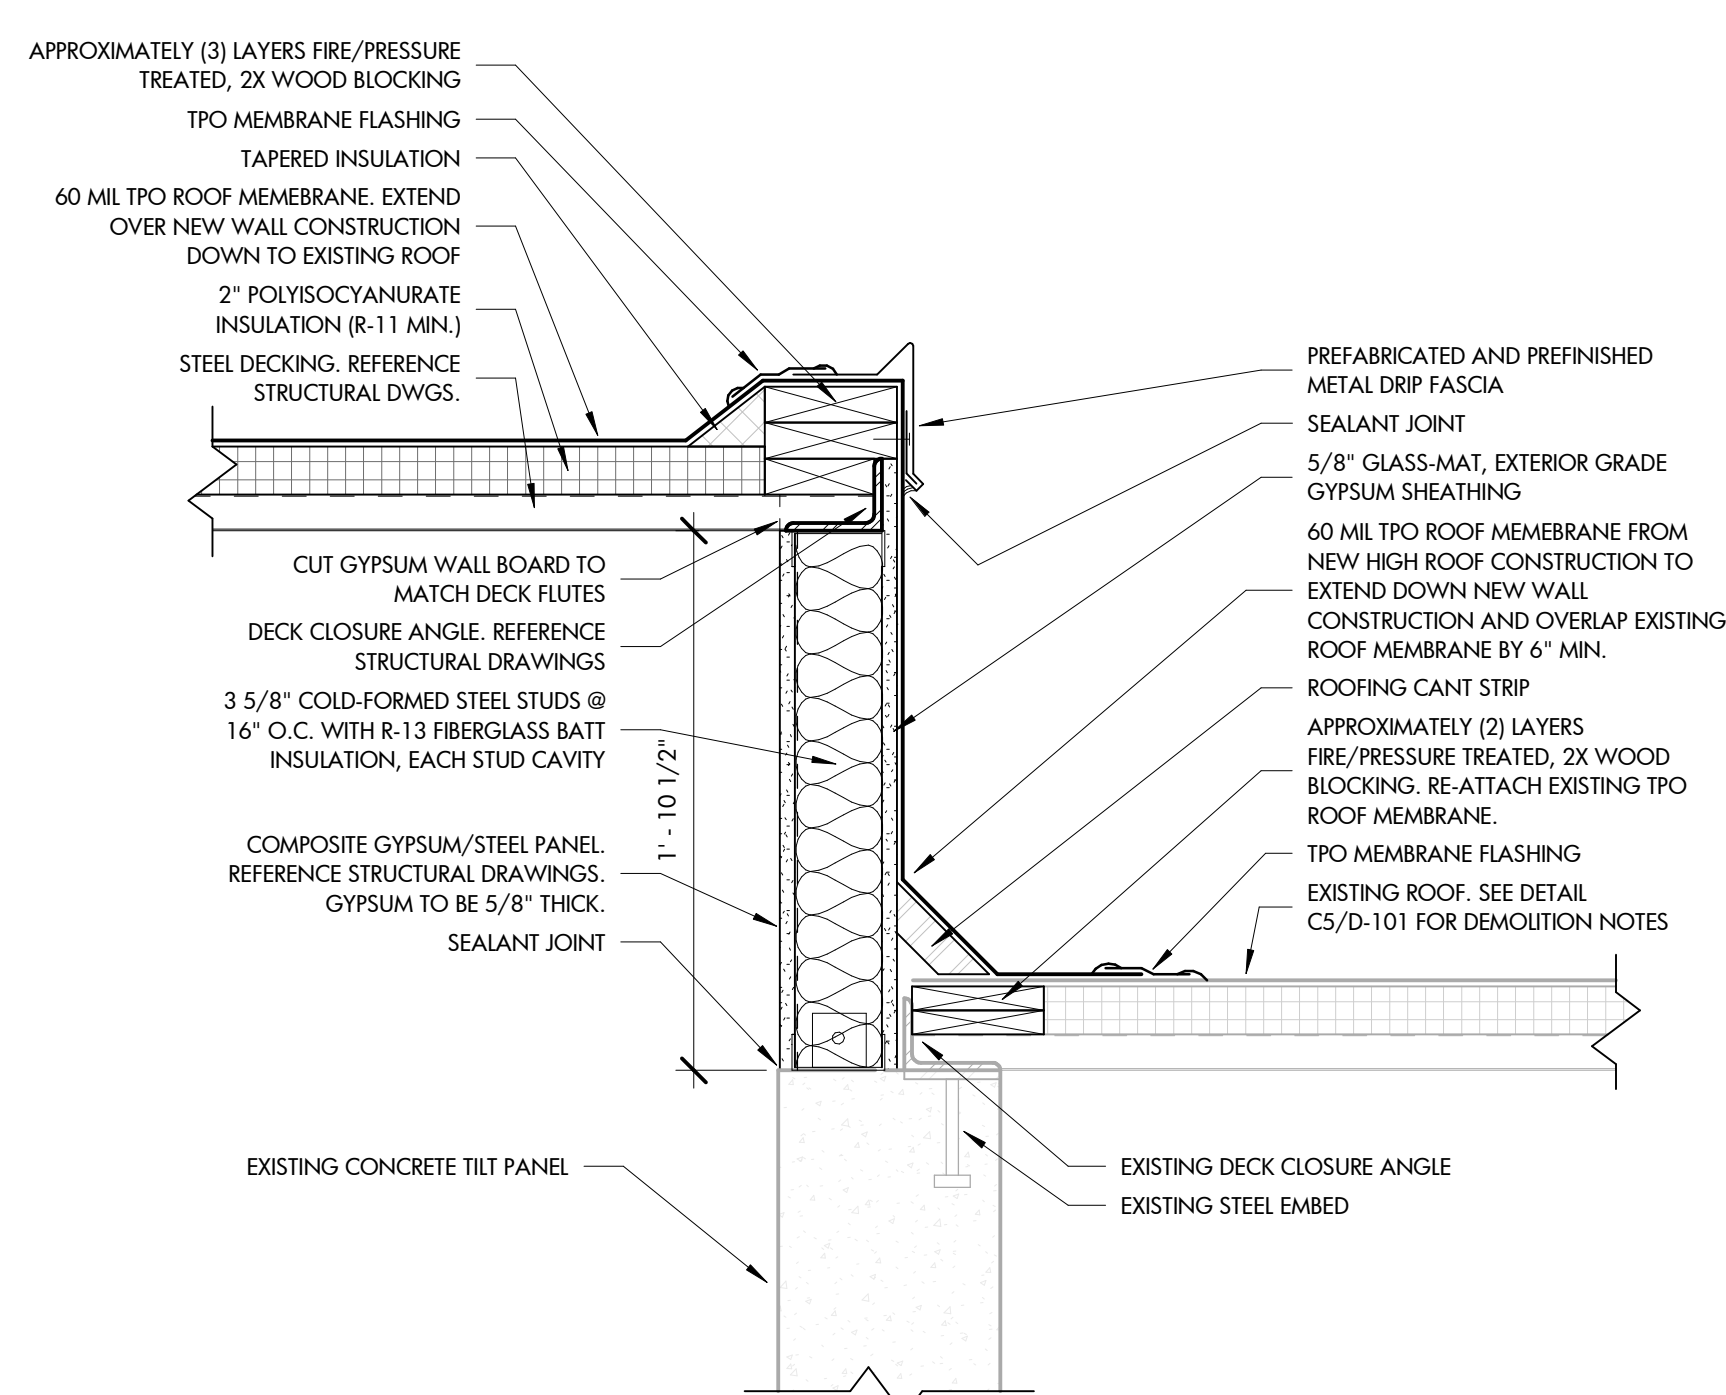


D3 ROOF CONNECTION DETAIL
1 1/2" = 1'-0"

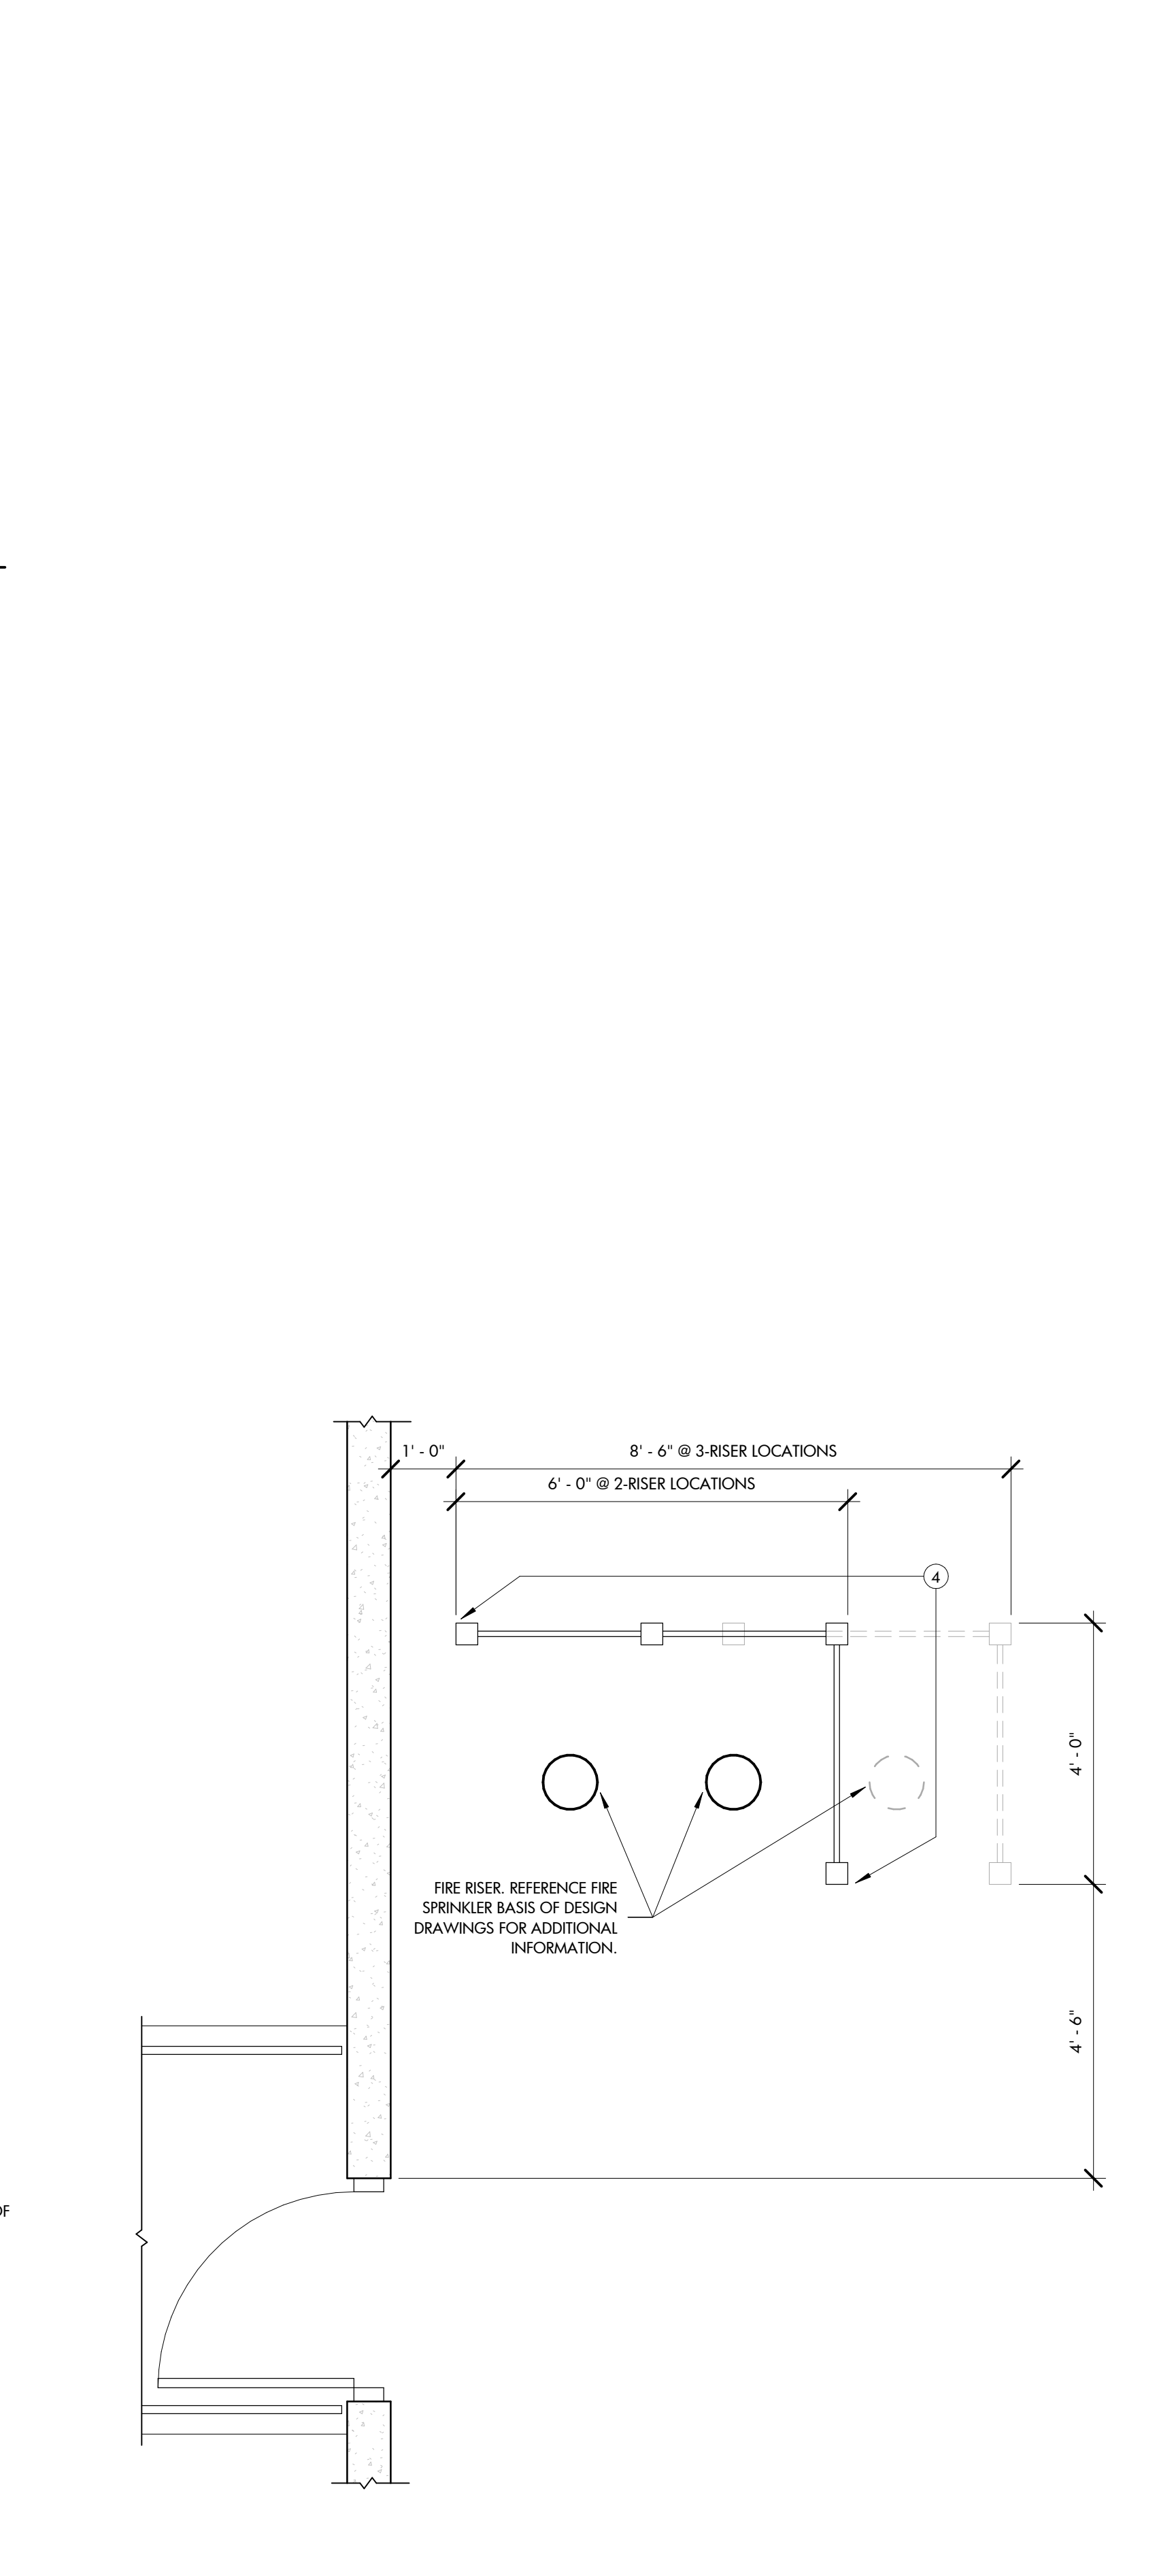


A3 FIRE RISER GUARD PROTECTION
1 1/2" = 1'-0"

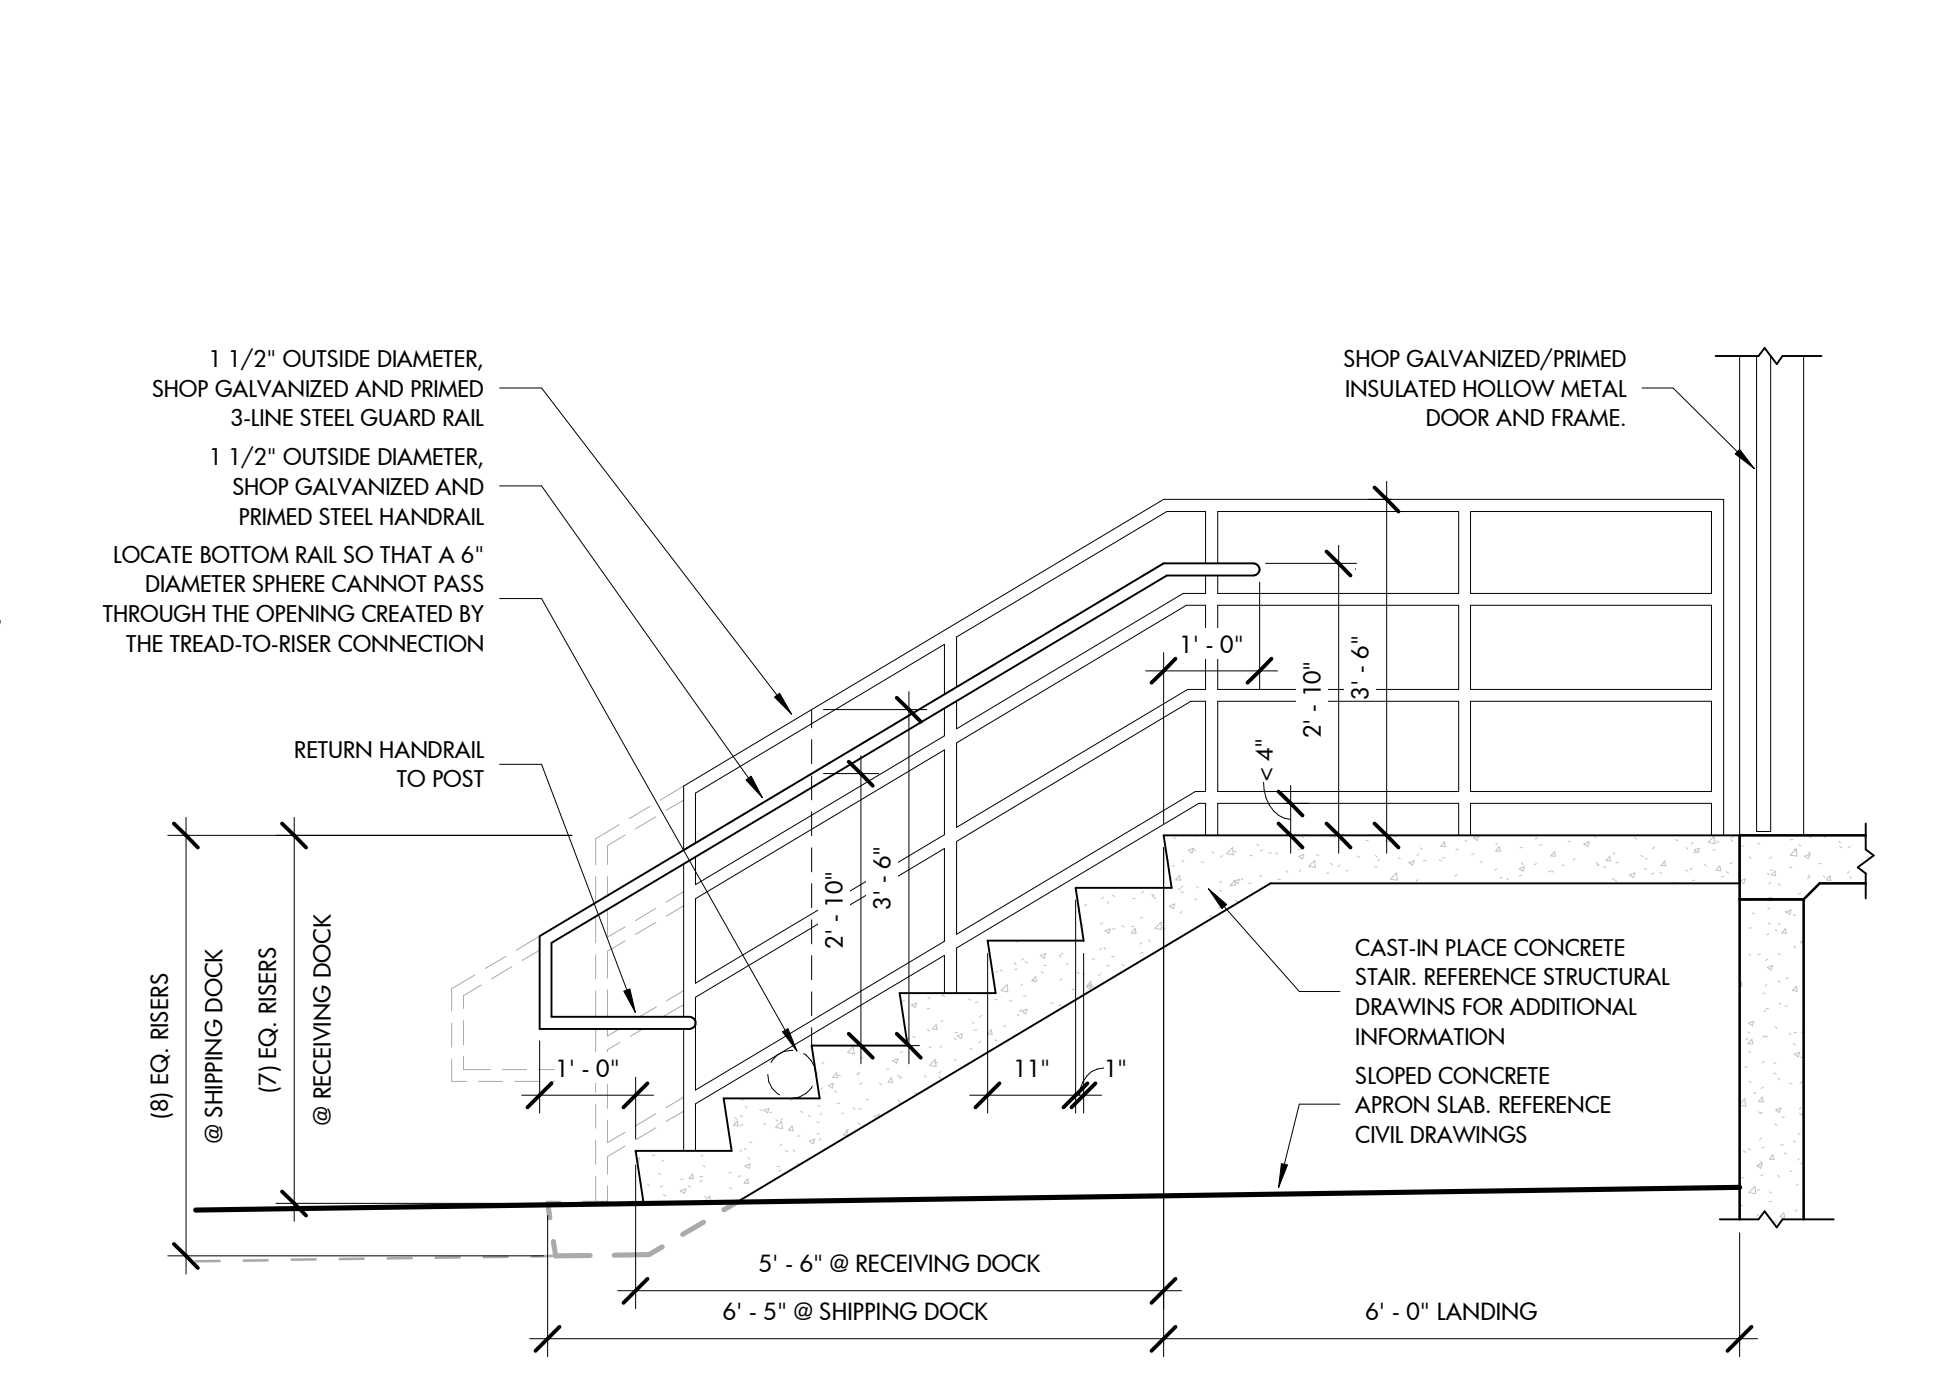


D4 DOCK STAIR SECTION
1/2" = 1'-0"

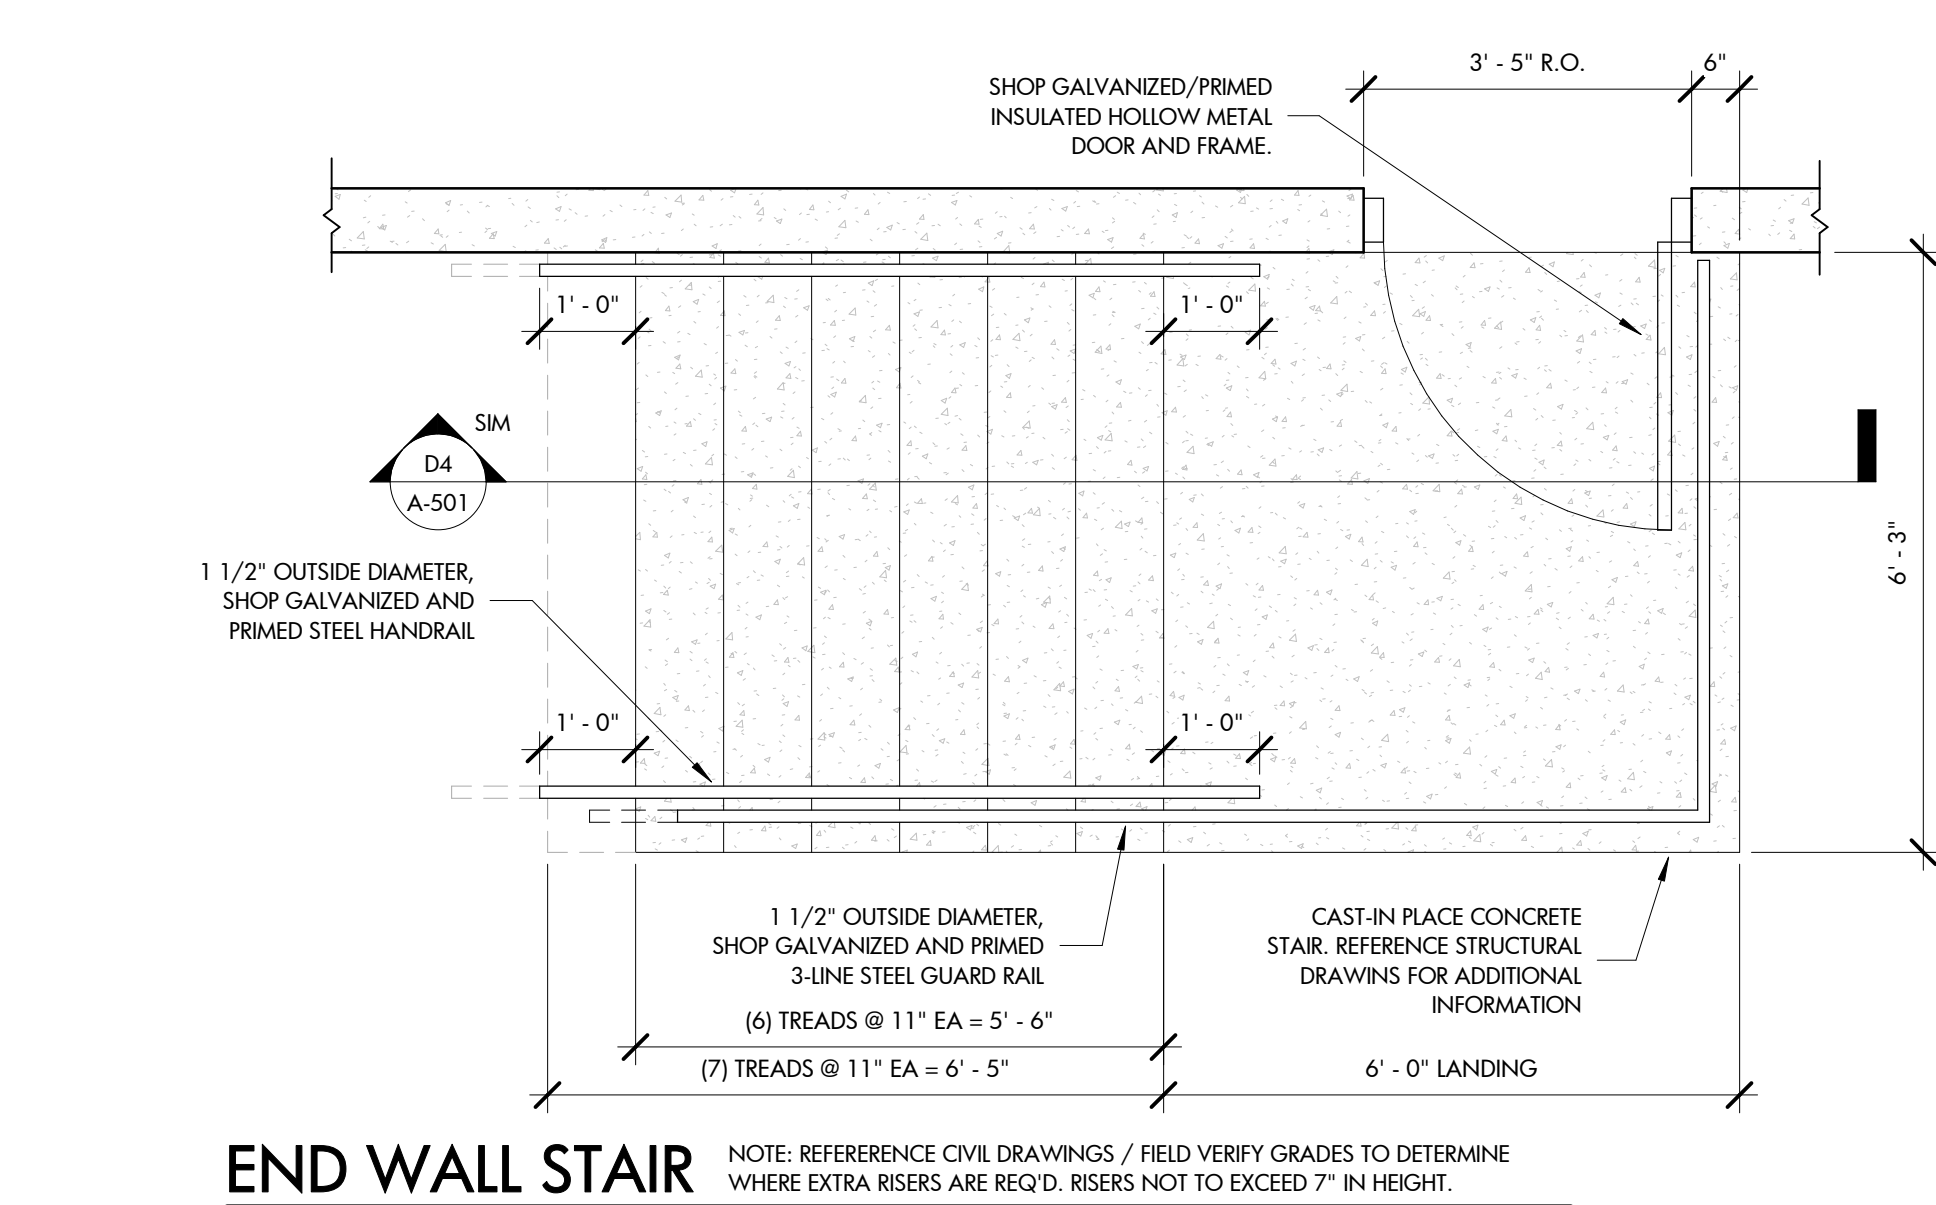


END WALL STAIR
NOTE: REFERENCE CIVIL DRAWINGS / FIELD VERIFY GRADES TO DETERMINE WHERE EXTRA RISERS ARE REQ'D. RISERS NOT TO EXCEED 7" IN HEIGHT.

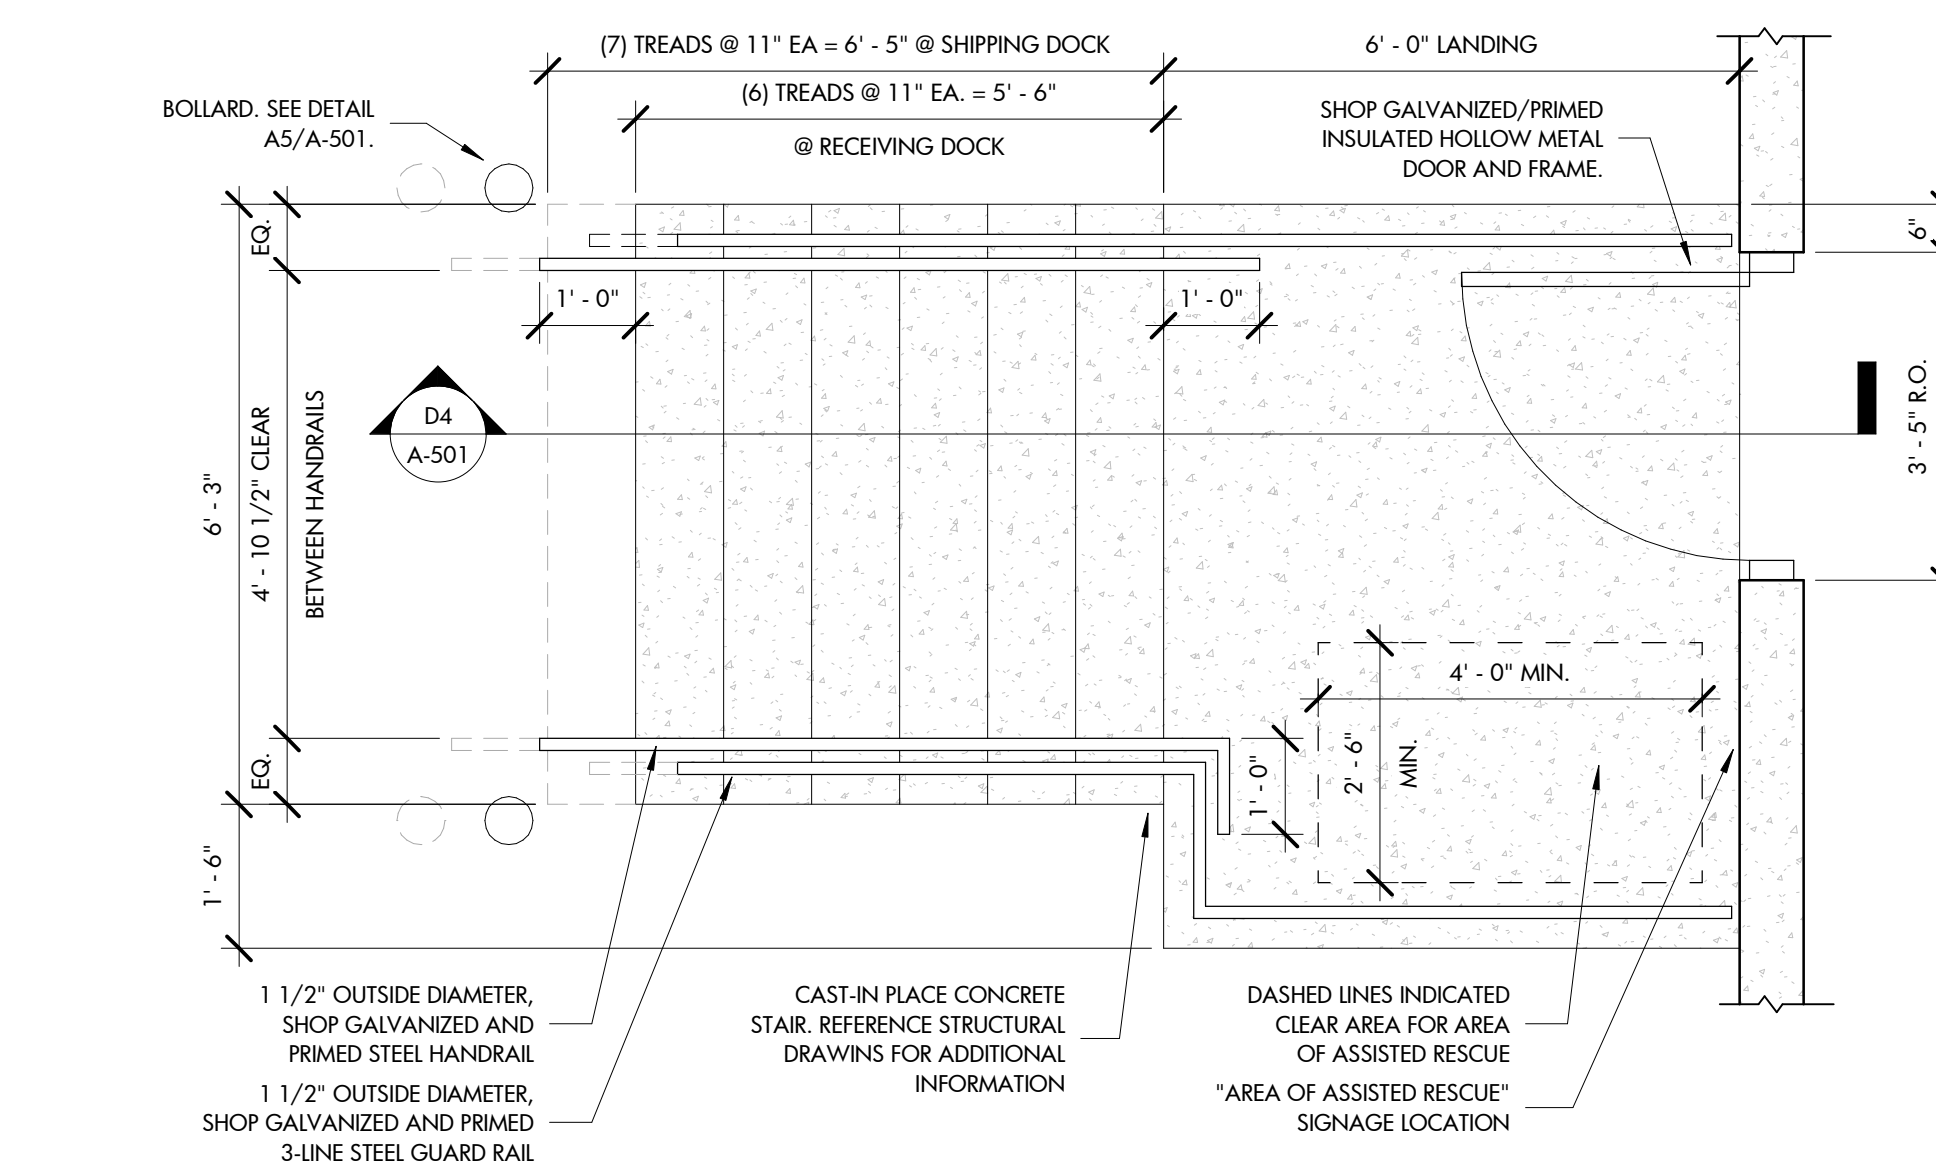


EGRESS STAIR LAYOUT

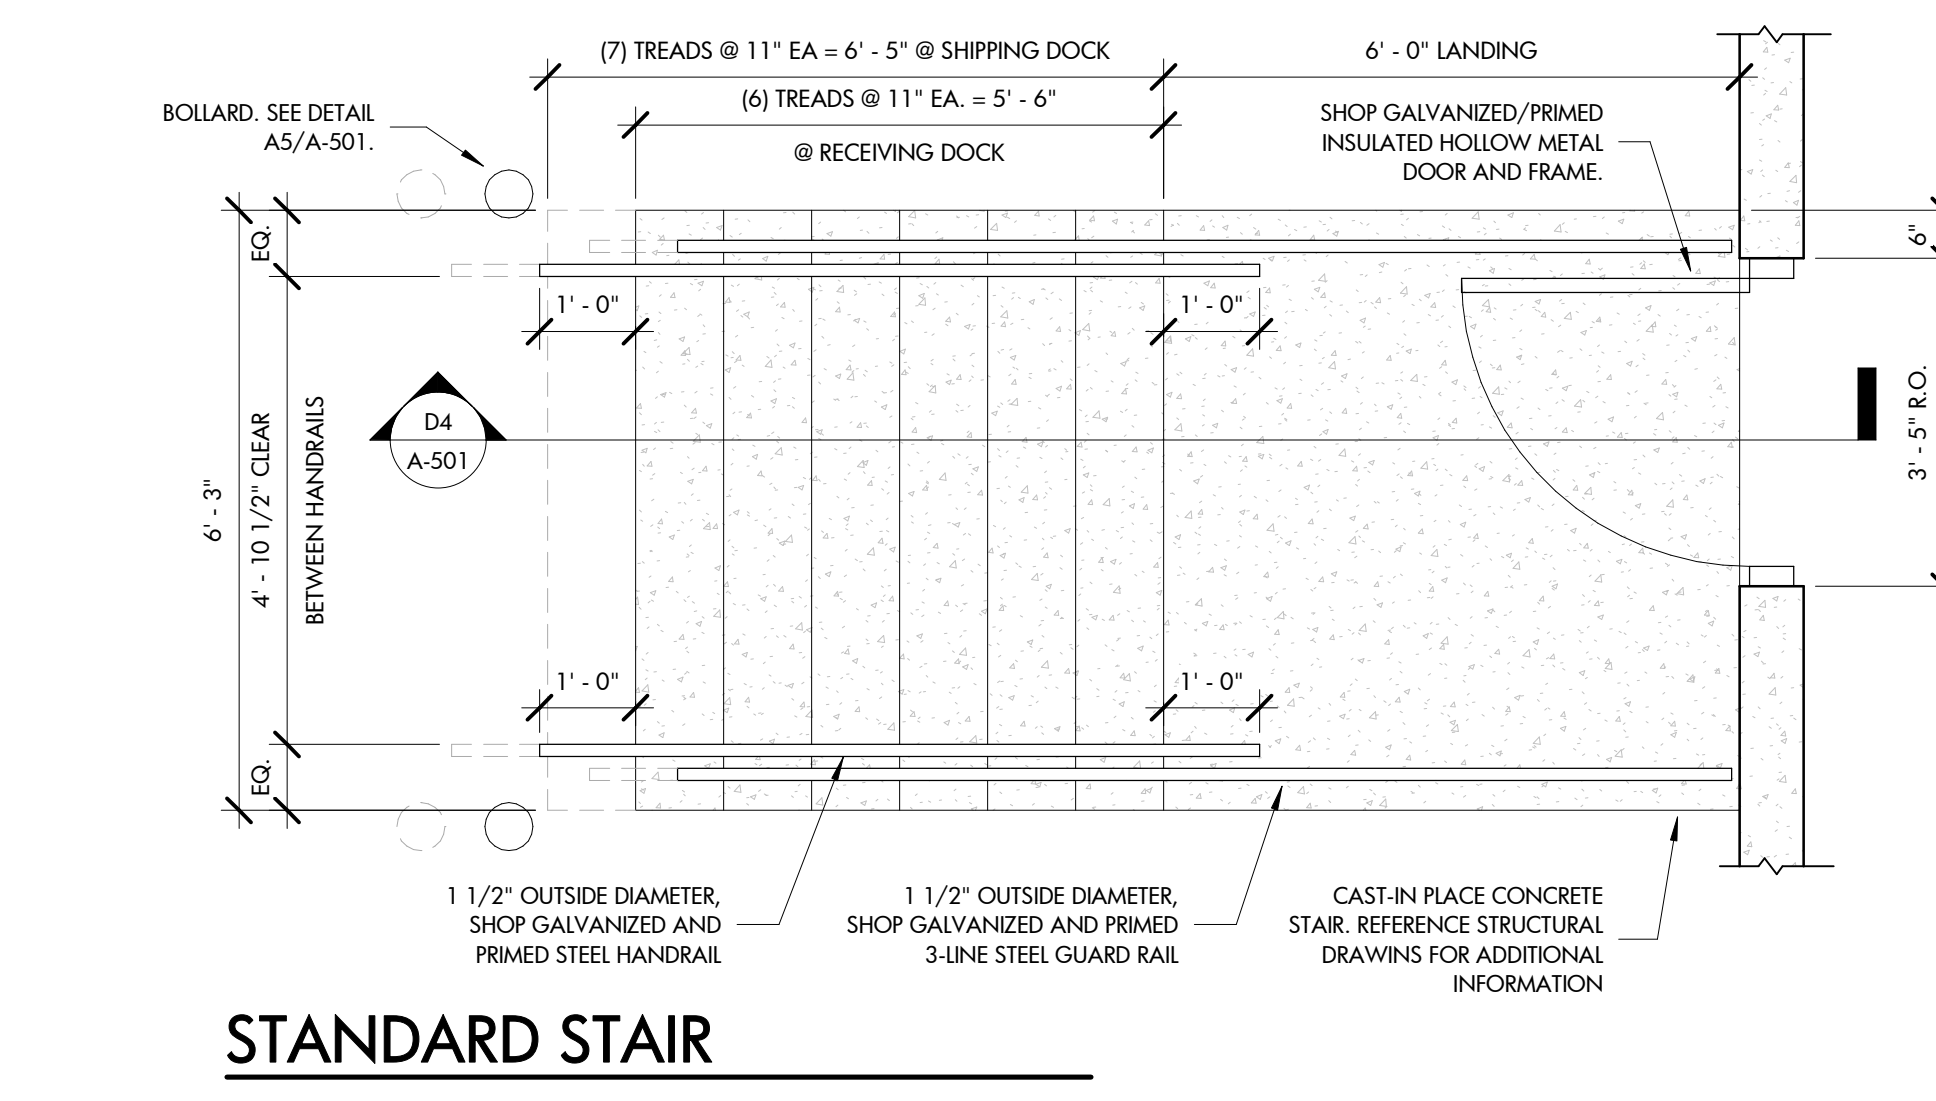


A4 DOCK STAIR PLANS
1/2" = 1'-0"

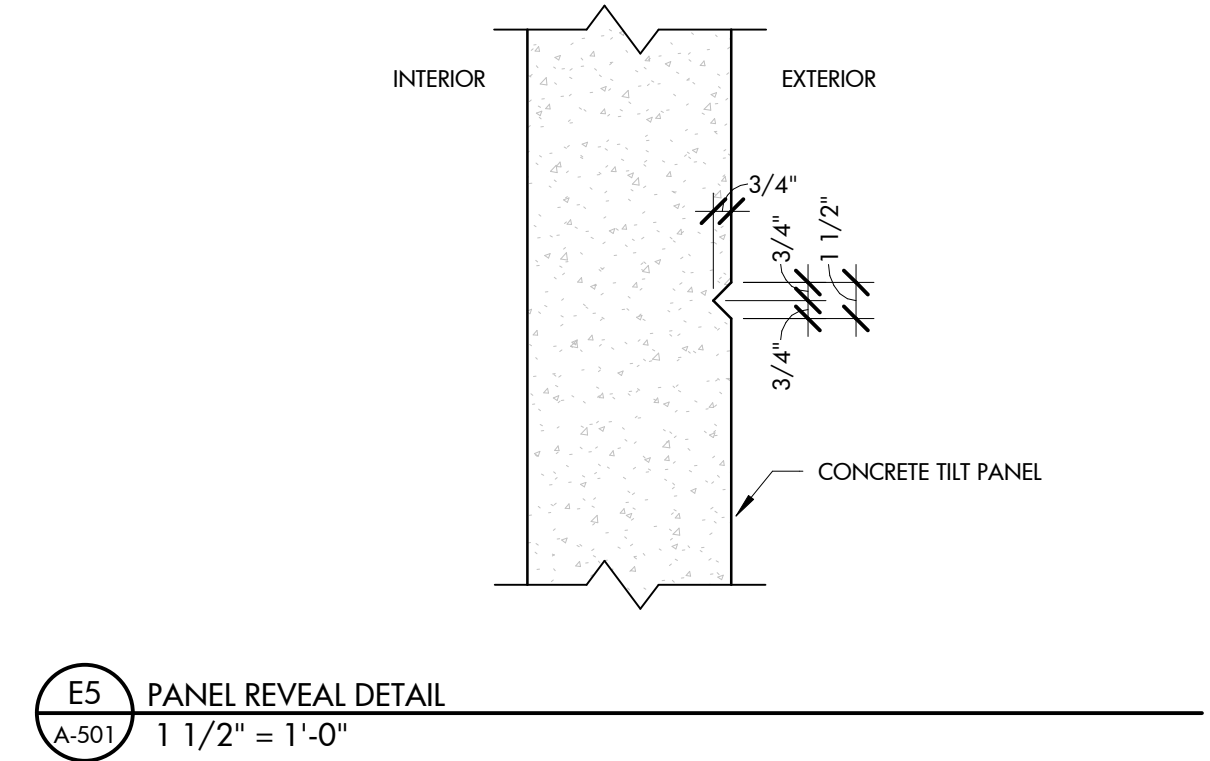


E5 PANEL REVEAL DETAIL
1 1/2" = 1'-0"

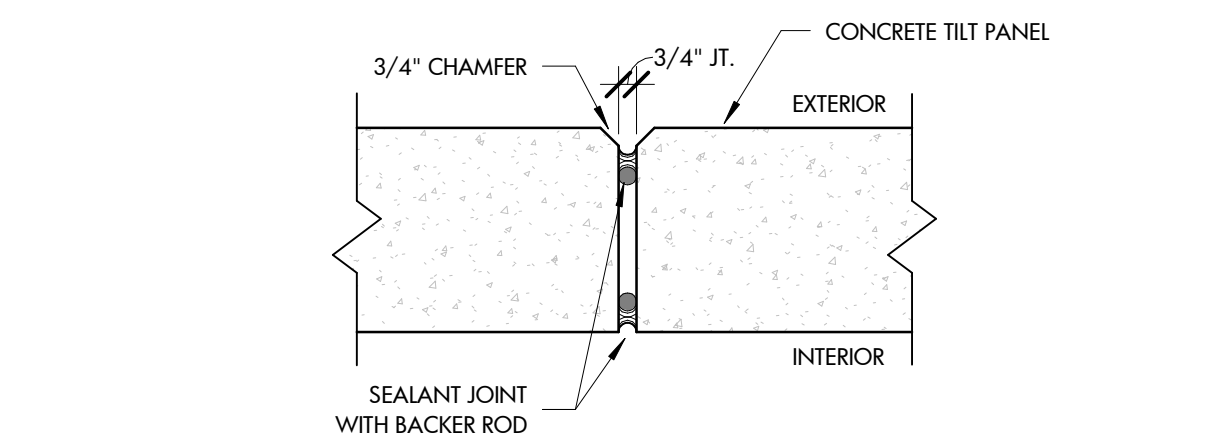


D5 PANEL JOINT DETAIL
1 1/2" = 1'-0"

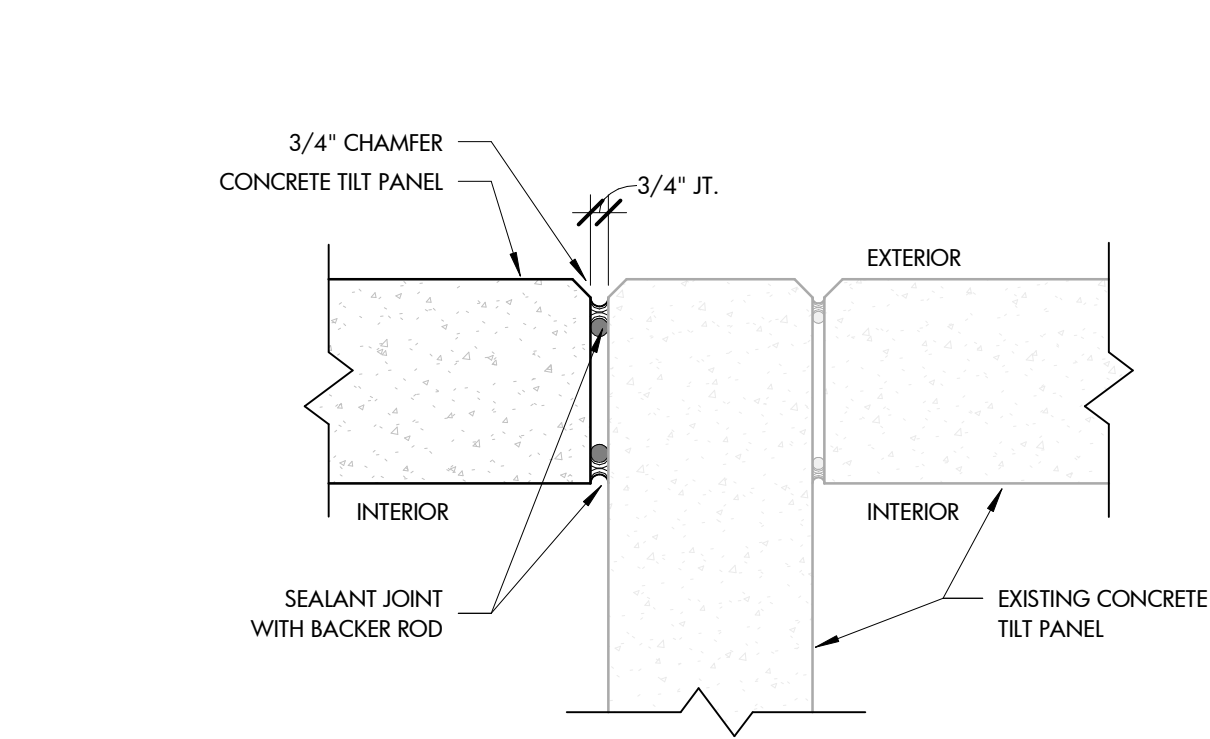

C5 PANEL CORNER DETAIL
1 1/2" = 1'-0"

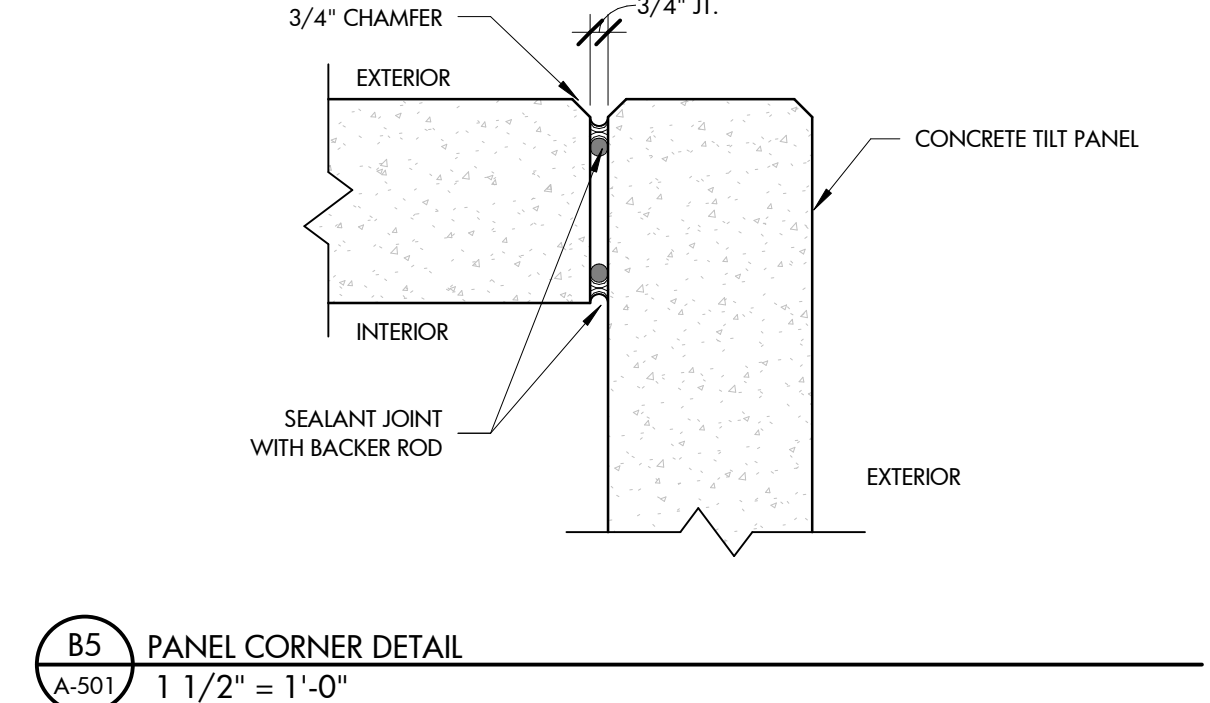

B5 PANEL CORNER DETAIL
1 1/2" = 1'-0"

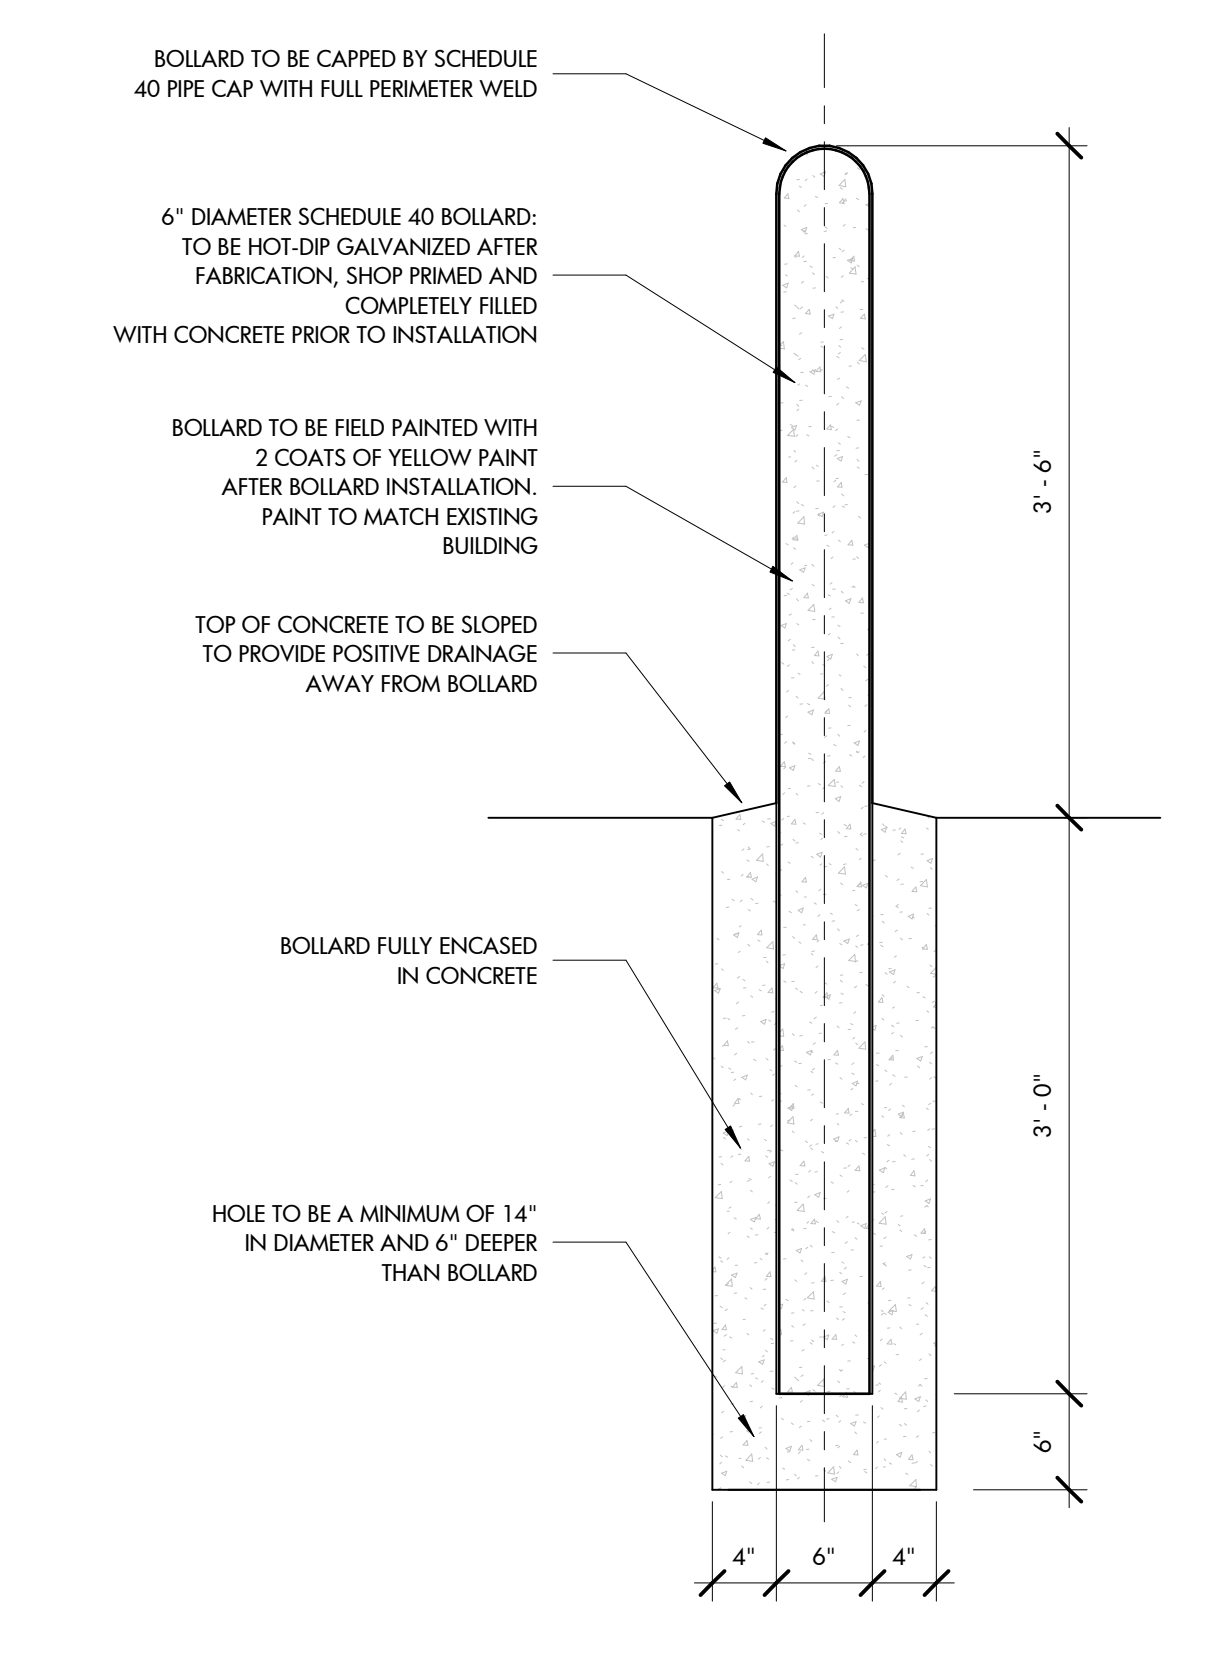

A5 BOLLARD SECTION
1" = 1'-0"



300 S. DAWSON STREET
RALEIGH, NC 27601 | 919.821.5547
www.hagersmith.com

© COPYRIGHT 2023

SEALS



PROJECT 288-000-000

ROOMS TO GO -
PHASE II
EXPANSION
901 Rooms to Go Way
Dunn, NC 28334

CONSULTANTS



ROOMS TO GO logo

901 Rooms to Go Way
Dunn, NC 28334
(910) 292-3505

DRAWING TITLE

DETAILS

REVISIONS

NUMBER DESCRIPTION DATE

DRAWN BY KRT

CHECKED BY BDG

DATE ISSUED 12/18/23 OF


A-501

DOOR HARDWARE/SCHEDULE NOTES

A.	EXTERIOR HM DOORS TO RECEIVE LATCH GUARDS.
B.	ALL EXTERIOR HM DOORS/FRAMES TO BE SHIP GALVANIZED AND PRIMED ON ALL SURFACES PRIOR TO INSTALLATION. ALL HOLLOW METAL DOORS AND FRAMES TO BE PAINTED.
C.	MEDICO CORES WILL BE PROVIDED BY THE OWNER. GENERAL CONTRACTOR TO PROVIDE TEMPORARY CORES DURING CONSTRUCTION. MORTISED CYLINDER LOCKS ARE NOT ACCEPTABLE. GENERAL CONTRACTOR TO COORDINATE ADDITIONAL KEYING REQUIREMENTS DIRECTLY WITH THE OWNER.
D.	ALL DOORS DESIGNATED AS EGRESS DOORS IN THE LIFE SAFETY PLAN (SEE SHEET G-101) ARE TO RECEIVE PANIC HARDWARE.
E.	PROVIDE A MINIMUM OF (3) SLICERS ON ALL DOORS.
F.	ALL OVERHEAD DOCK DOORS TO RECEIVE THE FOLLOWING ACCESSORIES/EQUIPMENT: - INTERIOR SAFETY GATE - RECESSED DOCK LEVER WITH DOCK BUMPER
G.	SHIPPING SIDE DOCK DOORS 1001-1017 TO RECEIVE DOCK LIGHTS.

REVISED NOTES

DOOR AND FRAME SCHEDULE																
MARK	WIDTH	HEIGHT	DOOR				FRAME				DETAILS		HARDWARE	FIRE RATING	REMARKS	
			THICKNESS	TYPE	MATERIAL	FINISH	TYPE	MATERIAL	FINISH	HEAD	JAMB					
101A	3'-0"	7'-0"	1 3/4"	A	HM, GALV	PT	F1	HM, GALV	PT	H1	J1	#2	-	EMPLOYEE ACCESS DOOR		
101B	3'-0"	7'-0"	1 3/4"	A	HM, GALV	PT	F1	HM, GALV	PT	H1	J1	#1	-			
101C	3'-0"	7'-0"	1 3/4"	A	HM, GALV	PT	F1	HM, GALV	PT	H1	J1	#1	-			
101D	3'-0"	7'-0"	1 3/4"	A	HM, GALV	PT	F1	HM, GALV	PT	H1	J1	#1	-			
101E	3'-0"	7'-0"	1 3/4"	A	HM, GALV	PT	F1	HM, GALV	PT	H1	J1	#1	-			
101F	7'-0"	7'-0"	1 3/4"	A	HM, GALV	PT	F1	HM, GALV	PT	H1	#2	J1	#2	-	EMPLOYEE ACCESS DOOR	
101G	3'-0"	7'-0"	1 3/4"	A	HM, GALV	PT	F1	HM, GALV	PT	H1	J1	#1	-			
101H	3'-0"	7'-0"	1 3/4"	A	HM, GALV	PT	F1	HM, GALV	PT	H1	J1	#1	-			
101J	3'-0"	7'-0"	1 3/4"	A	HM, GALV	PT	F1	HM, GALV	PT	H1	J1	#1	-			
101K	3'-0"	7'-0"	1 3/4"	A	HM, GALV	PT	F1	HM, GALV	PT	H1	J1	#1	-			
101L	3'-0"	7'-0"	1 3/4"	A	HM, GALV	PT	F1	HM, GALV	PT	H1	J1	#1	-			
101M	3'-0"	7'-0"	1 3/4"	A	HM, GALV	PT	F1	HM, GALV	PT	H1	J1	#1	-			
101N	3'-0"	7'-0"	1 3/4"	A	HM, GALV	PT	F1	HM, GALV	PT	H1	J1	#2	-	EMPLOYEE ACCESS DOOR		
101P	3'-0"	7'-0"	1 3/4"	A	HM, GALV	PT	F1	HM, GALV	PT	H1	J1	#1	-			
101Q	3'-0"	7'-0"	1 3/4"	A	HM, GALV	PT	F1	HM, GALV	PT	H1	J1	#1	-			
101R	3'-0"	7'-0"	1 3/4"	A	HM, GALV	PT	F1	HM, GALV	PT	H1	J1	#1	-			
101S	3'-0"	7'-0"	1 3/4"	A	HM, GALV	PT	F1	HM, GALV	PT	H1	J1	#1	-			
101T	3'-0"	7'-0"	1 3/4"	A	HM, GALV	PT	F1	HM, GALV	PT	H1	J1	#2	-	EMPLOYEE ACCESS DOOR		
102	3'-0"	7'-0"	1 3/4"	B	HM	PT	F2	HM	PT	H2	J2	#3	-			
103	3'-0"	7'-0"	1 3/4"	B	HM	PT	F2	HM	PT	H2	J2	#3	-			
104	3'-0"	7'-0"	1 3/4"	B	HM	PT	F2	HM	PT	H2	J2	#4	-			
1001	9'-4"	10'-2"	-	C	INS. MTL	PREFINISHED	-	-	-	H3	J3	*	-	"SEE DOOR/HARDWARE SCHEDULE NOTES 'F' & 'G'"		
1002	9'-4"	10'-2"	-	C	INS. MTL	PREFINISHED	-	-	-	H3	J3	*	-	"SEE DOOR/HARDWARE SCHEDULE NOTES 'F' & 'G'"		
1003	9'-4"	10'-2"	-	C	INS. MTL	PREFINISHED	-	-	-	H3	J3	*	-	"SEE DOOR/HARDWARE SCHEDULE NOTES 'F' & 'G'"		
1004	9'-4"	10'-2"	-	C	INS. MTL	PREFINISHED	-	-	-	H3	J3	*	-	"SEE DOOR/HARDWARE SCHEDULE NOTES 'F' & 'G'"		
1005	9'-4"	10'-2"	-	C	INS. MTL	PREFINISHED	-	-	-	H3	J3	*	-	"SEE DOOR/HARDWARE SCHEDULE NOTES 'F' & 'G'"		
1006	9'-4"	10'-2"	-	C	INS. MTL	PREFINISHED	-	-	-	H3	J3	*	-	"SEE DOOR/HARDWARE SCHEDULE NOTES 'F' & 'G'"		
1007	9'-4"	10'-2"	-	C	INS. MTL	PREFINISHED	-	-	-	H3	J3	*	-	"SEE DOOR/HARDWARE SCHEDULE NOTES 'F' & 'G'"		
1008	9'-4"	10'-2"	-	C	INS. MTL	PREFINISHED	-	-	-	H3	J3	*	-	"SEE DOOR/HARDWARE SCHEDULE NOTES 'F' & 'G'"		
1009	9'-4"	10'-2"	-	C	INS. MTL	PREFINISHED	-	-	-	H3	J3	*	-	"SEE DOOR/HARDWARE SCHEDULE NOTES 'F' & 'G'"		
1010	9'-4"	10'-2"	-	C	INS. MTL	PREFINISHED	-	-	-	H3	J3	*	-	"SEE DOOR/HARDWARE SCHEDULE NOTES 'F' & 'G'"		
1011	9'-4"	10'-2"	-	C	INS. MTL	PREFINISHED	-	-	-	H3	J3	*	-	"SEE DOOR/HARDWARE SCHEDULE NOTES 'F' & 'G'"		
1012	9'-4"	10'-2"	-	C	INS. MTL	PREFINISHED	-	-	-	H3	J3	*	-	"SEE DOOR/HARDWARE SCHEDULE NOTES 'F' & 'G'"		
1013	9'-4"	10'-2"	-	C	INS. MTL	PREFINISHED	-	-	-	H3	J3	*	-	"SEE DOOR/HARDWARE SCHEDULE NOTES 'F' & 'G'"		
1014	9'-4"	10'-2"	-	C	INS. MTL	PREFINISHED	-	-	-	H3	J3	*	-	"SEE DOOR/HARDWARE SCHEDULE NOTES 'F' & 'G'"		
1015	9'-4"	10'-2"	-	C	INS. MTL	PREFINISHED	-	-	-	H3	J3	*	-	"SEE DOOR/HARDWARE SCHEDULE NOTES 'F' & 'G'"		
1016	9'-4"	10'-2"	-	C	INS. MTL	PREFINISHED	-	-	-	H3	J3	*	-	"SEE DOOR/HARDWARE SCHEDULE NOTES 'F' & 'G'"		
1017	9'-4"	10'-2"	-	C	INS. MTL	PREFINISHED	-	-	-	H3	J3	*	-	"SEE DOOR/HARDWARE SCHEDULE NOTES 'F' & 'G'"		
1018	9'-4"	10'-2"	-	C	INS. MTL	PREFINISHED	-	-	-	H3	J3	*	-	"SEE DOOR/HARDWARE SCHEDULE NOTES 'F' & 'G'"		
1019	9'-4"	10'-2"	-	C	INS. MTL	PREFINISHED	-	-	-	H3	J3	*	-	"SEE DOOR/HARDWARE SCHEDULE NOTE 'F'"		
1020	9'-4"	10'-2"	-	C	INS. MTL	PREFINISHED	-	-	-	H3	J3	*	-	"SEE DOOR/HARDWARE SCHEDULE NOTE 'F'"		
1021	9'-4"	10'-2"	-	C	INS. MTL	PREFINISHED	-	-	-	H3	J3	*	-	"SEE DOOR/HARDWARE SCHEDULE NOTE 'F'"		
1022	9'-4"	10'-2"	-	C	INS. MTL	PREFINISHED	-	-	-	H3	J3	*	-	"SEE DOOR/HARDWARE SCHEDULE NOTE 'F'"		
1023	9'-4"	10'-2"	-	C	INS. MTL	PREFINISHED	-	-	-	H3	J3	*	-	"SEE DOOR/HARDWARE SCHEDULE NOTE 'F'"		
1024	9'-4"	10'-2"	-	C	INS. MTL	PREFINISHED	-	-	-	H3	J3	*	-	"SEE DOOR/HARDWARE SCHEDULE NOTE 'F'"		
1025	9'-4"	10'-2"	-	C	INS. MTL	PREFINISHED	-	-	-	H3	J3	*	-	"SEE DOOR/HARDWARE SCHEDULE NOTE 'F'"		
1026	9'-4"	10'-2"	-	C	INS. MTL	PREFINISHED	-	-	-	H3	J3	*	-	"SEE DOOR/HARDWARE SCHEDULE NOTE 'F'"		
1027	9'-4"	10'-2"	-	C	INS. MTL	PREFINISHED	-	-	-	H3	J3	*	-	"SEE DOOR/HARDWARE SCHEDULE NOTE 'F'"		
1028	9'-4"	10'-2"	-	C	INS. MTL	PREFINISHED	-	-	-	H3	J3	*	-	"SEE DOOR/HARDWARE SCHEDULE NOTE 'F'"		
1029	9'-4"	10'-2"	-	C	INS. MTL	PREFINISHED	-	-	-	H3	J3	*	-	"SEE DOOR/HARDWARE SCHEDULE NOTE 'F'"		
1030	9'-4"	10'-2"	-	C	INS. MTL	PREFINISHED	-	-	-	H3	J3	*	-	"SEE DOOR/HARDWARE SCHEDULE NOTE 'F'"		
1031	9'-4"	10'-2"	-	C	INS. MTL	PREFINISHED	-	-	-	H3	J3	*	-	"SEE DOOR/HARDWARE SCHEDULE NOTE 'F'"		
1032	9'-4"	10'-2"	-	C	INS. MTL	PREFINISHED	-	-	-	H3	J3	*	-	"SEE DOOR/HARDWARE SCHEDULE NOTE 'F'"		
1033	9'-4"	10'-2"	-	C	INS. MTL	PREFINISHED	-	-	-	H3	J3	*	-	"SEE DOOR/HARDWARE SCHEDULE NOTE 'F'"		
1034	9'-4"	10'-2"	-	C	INS. MTL	PREFINISHED	-	-	-	H3	J3	*	-	"SEE DOOR/HARDWARE SCHEDULE NOTE 'F'"		

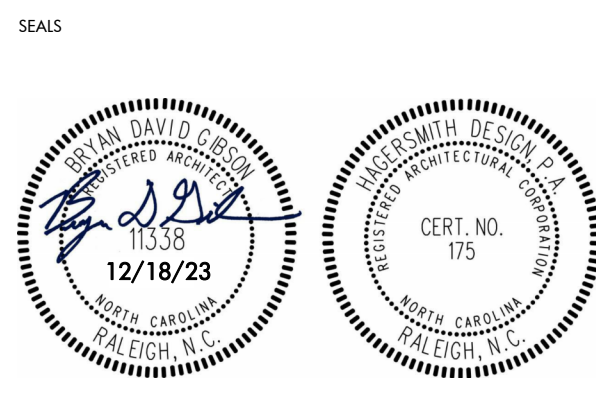





PROJECT 288-000-000

**ROOMS TO GO -
PHASE II
EXPANSION**

901 Rooms to Go Way
Dunn, NC 28334



B N K
BASS | NIXON | KENNEDY
CONSULTING ENGINEERS
ENGINEERING FIRM NUMBER: C-0110
6310 CHAPEL HILL ROAD, SUITE 250
RALEIGH, N.C. 27607
P.919.851.4422 BNKINC.COM

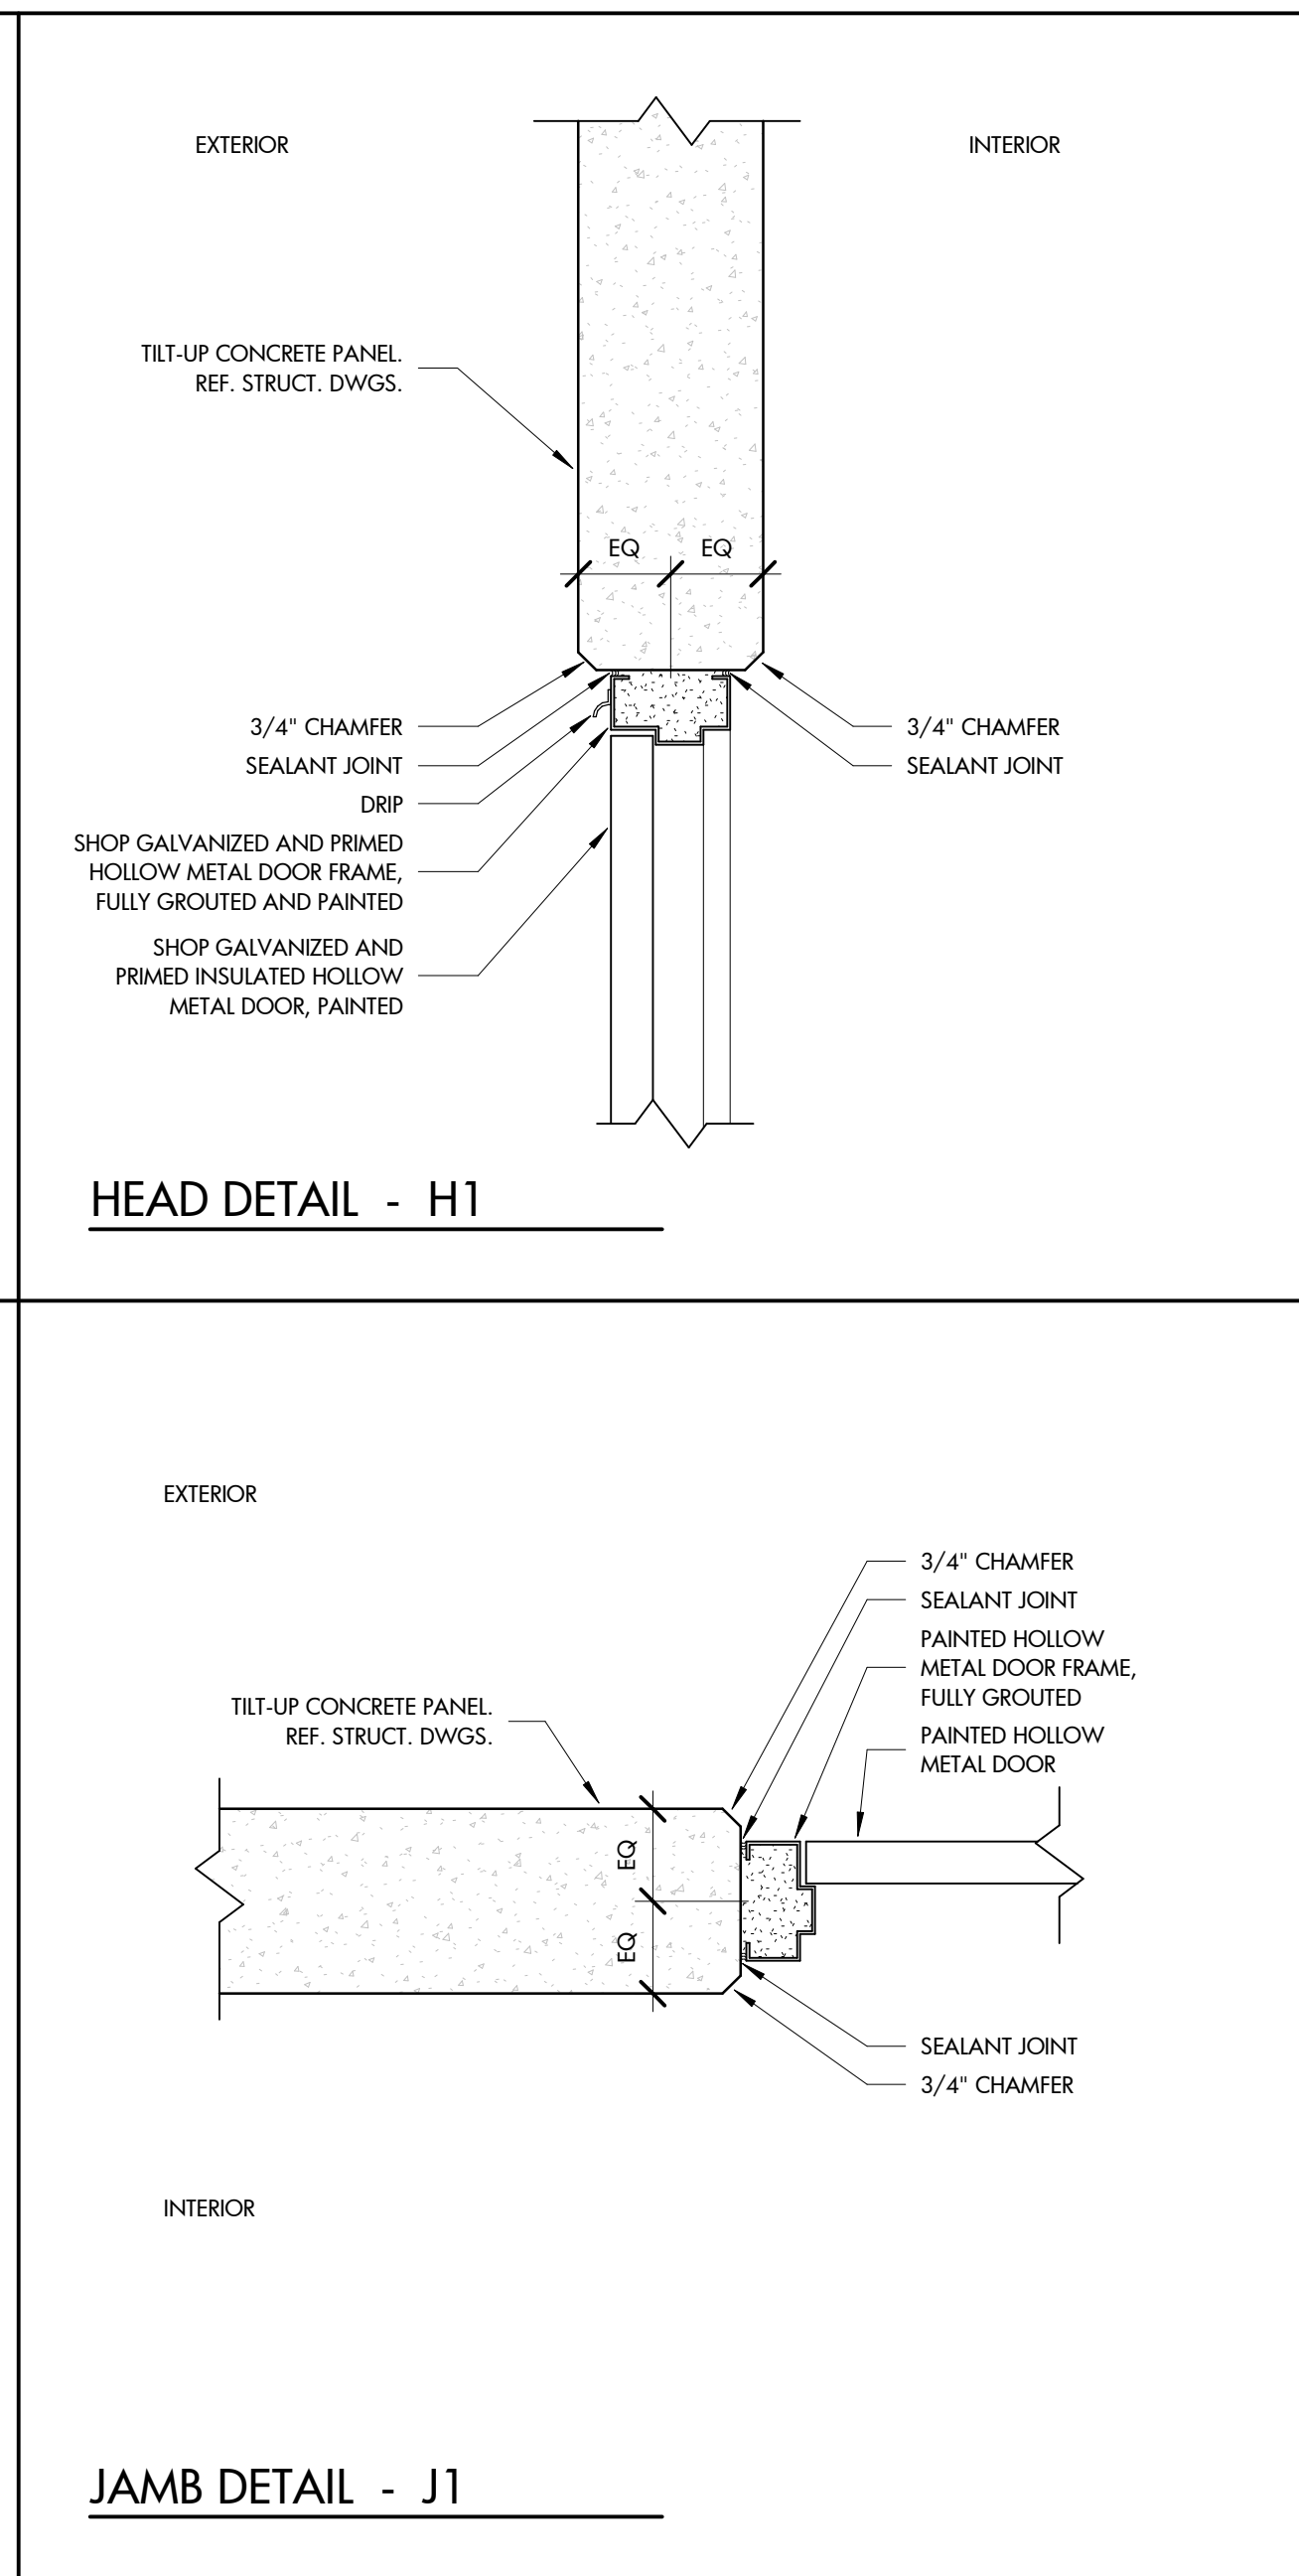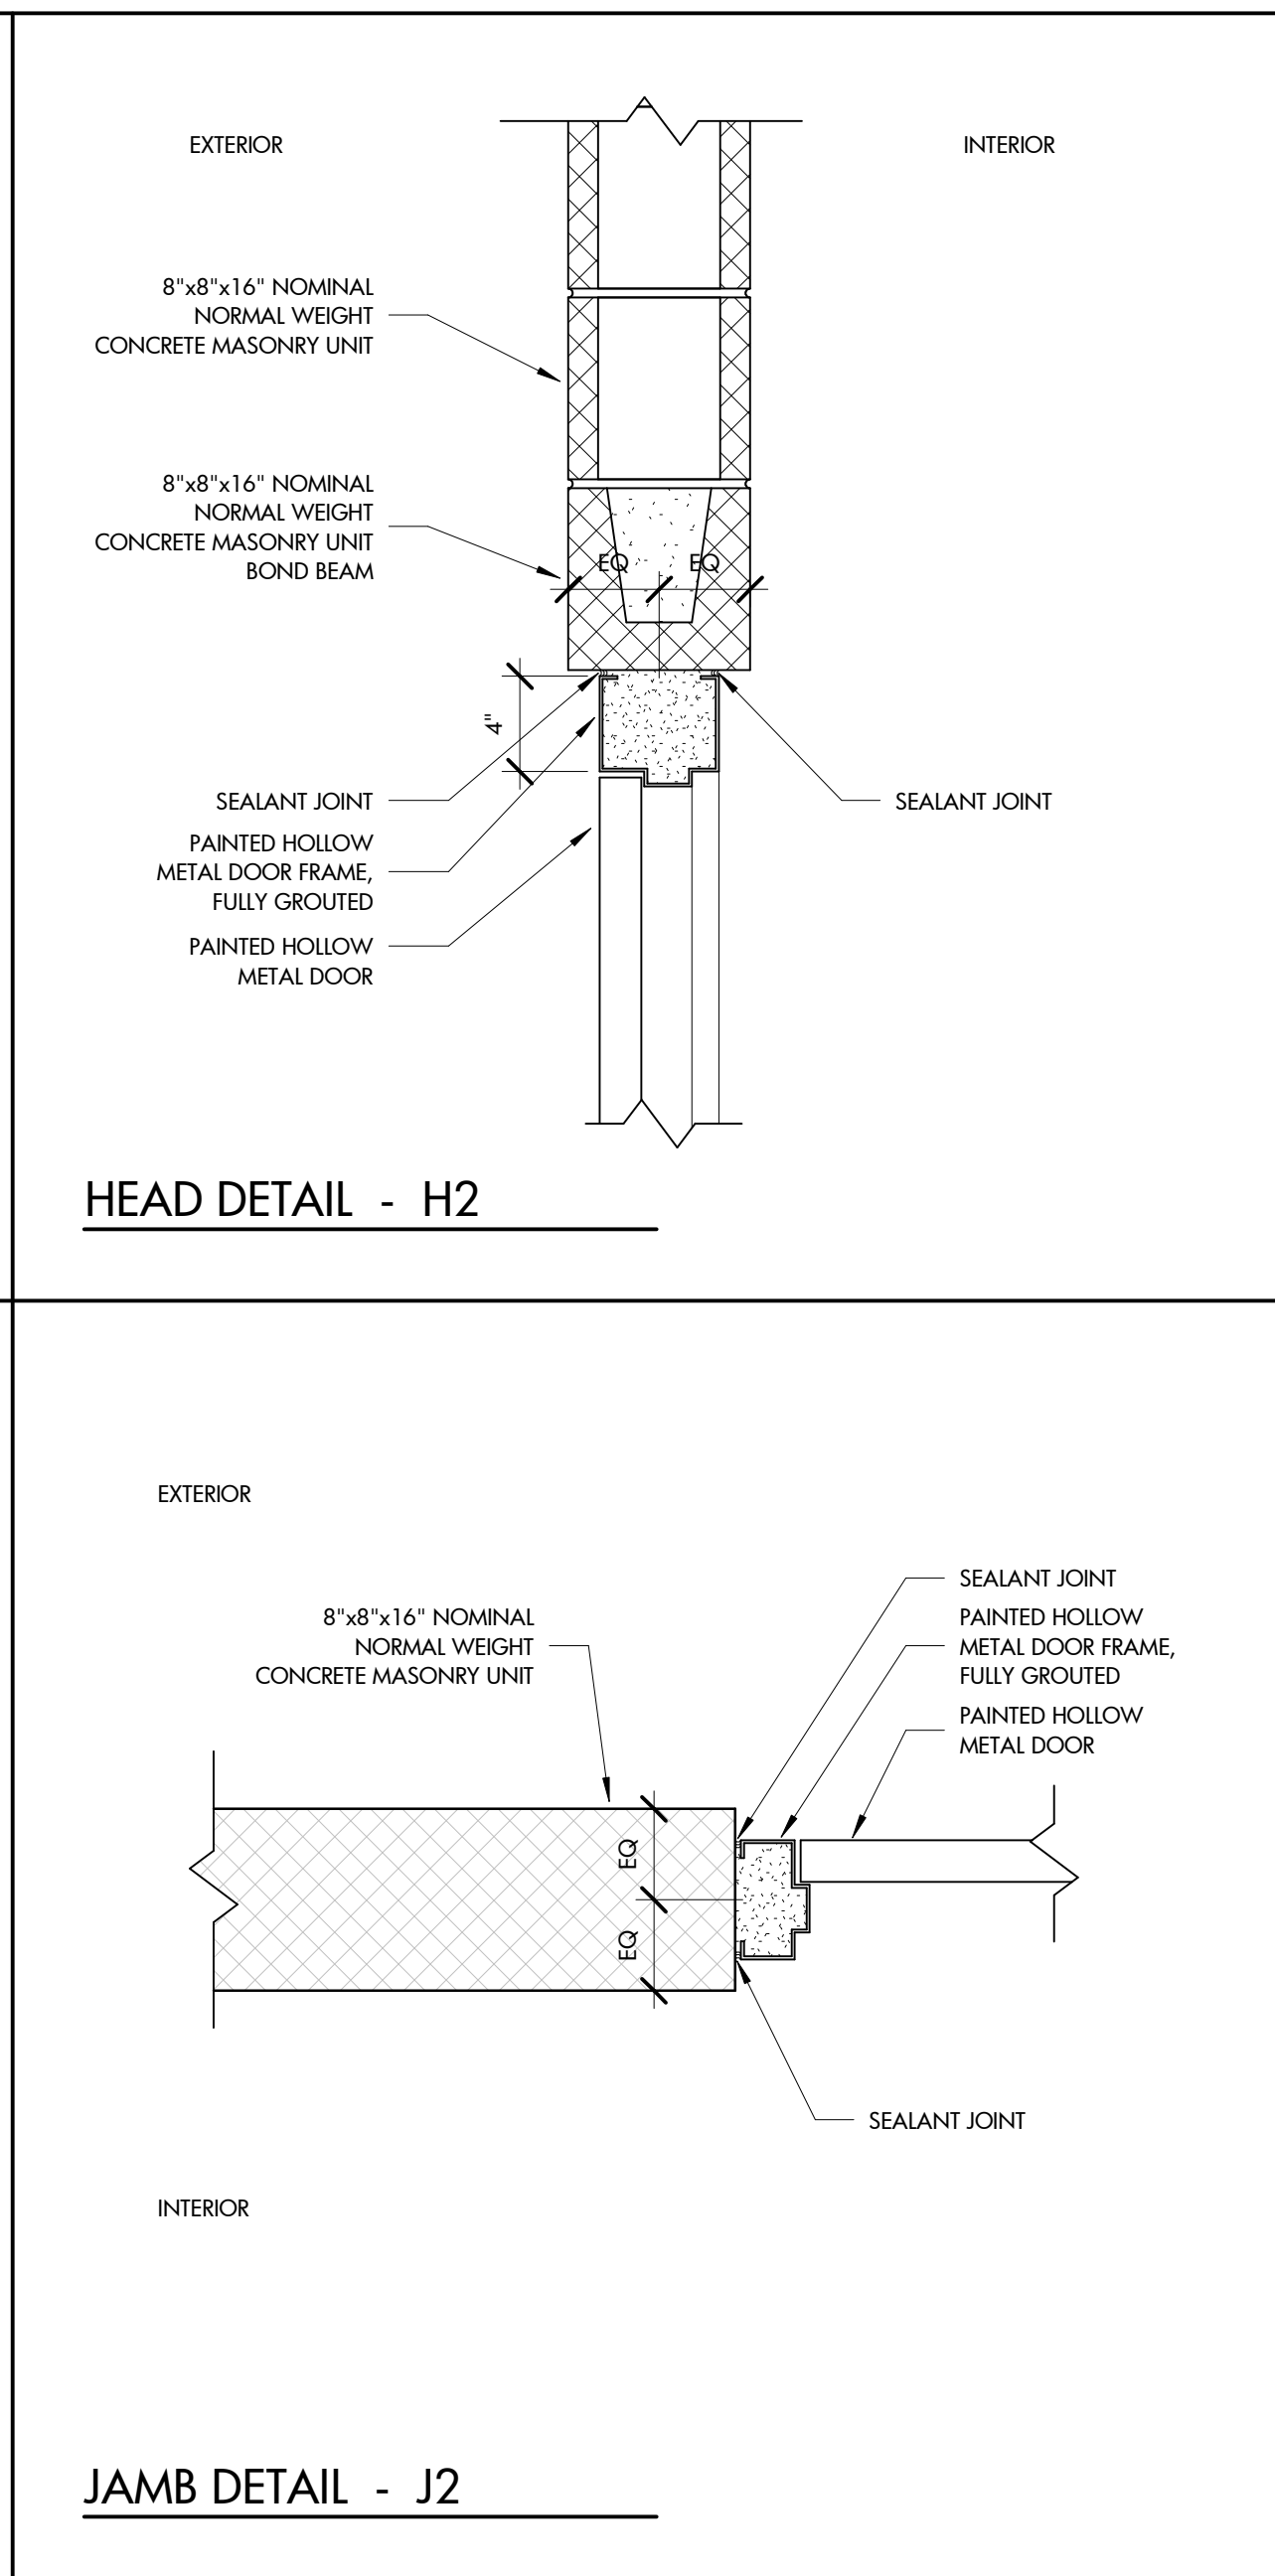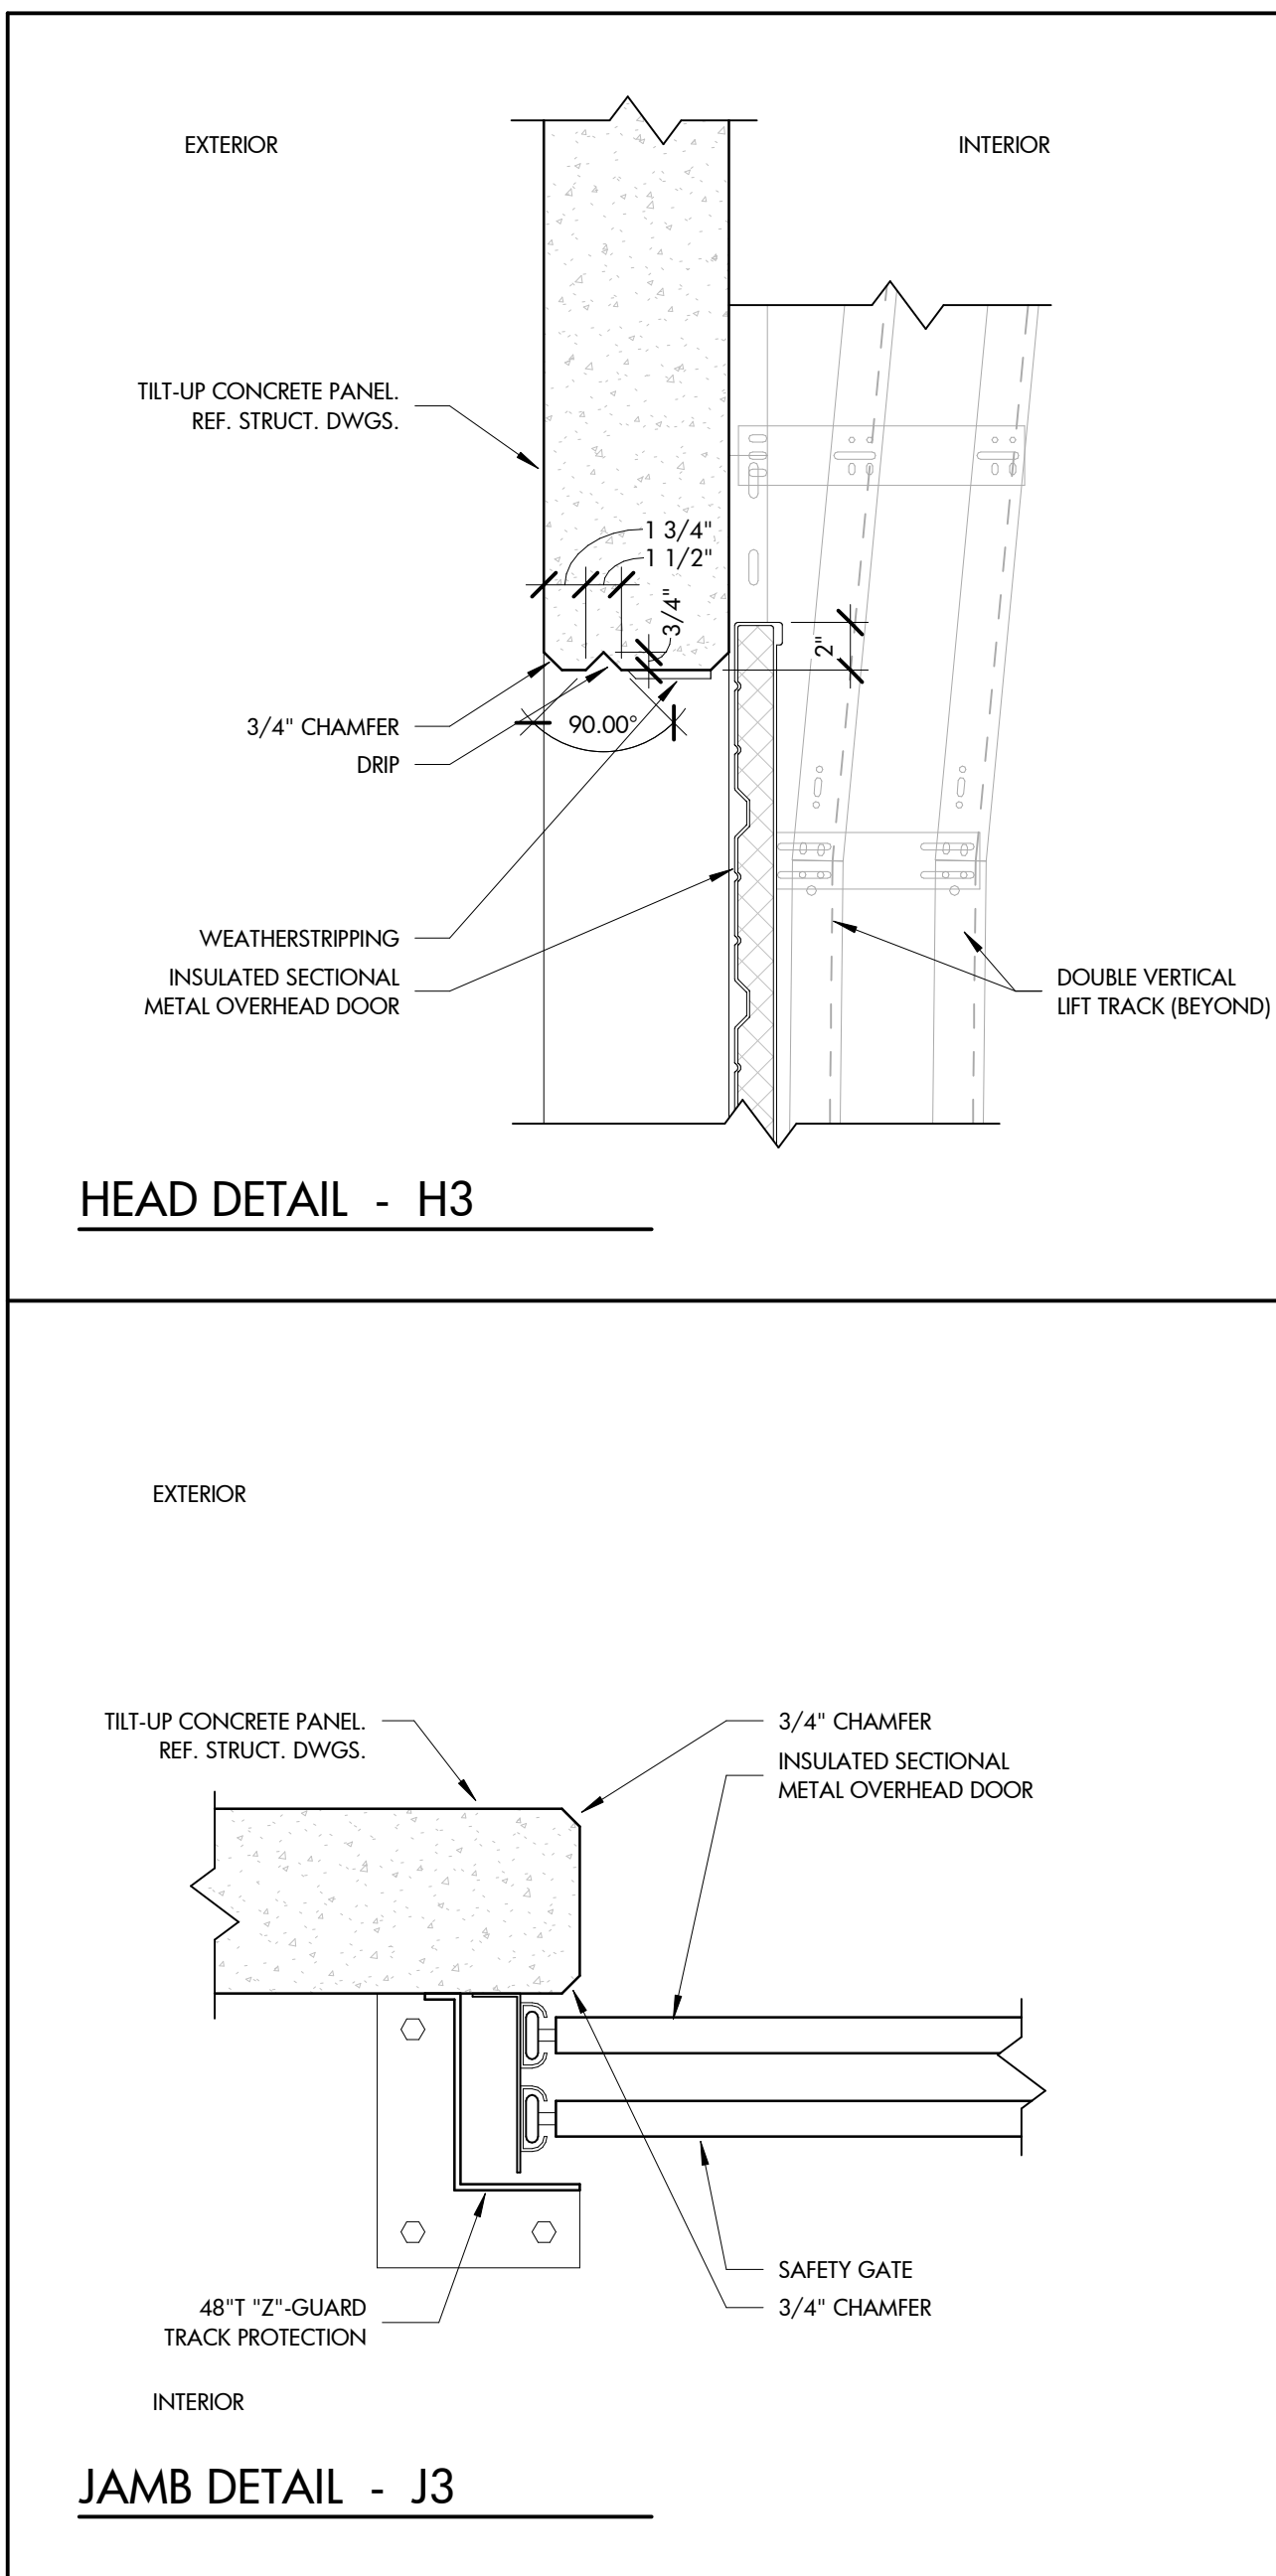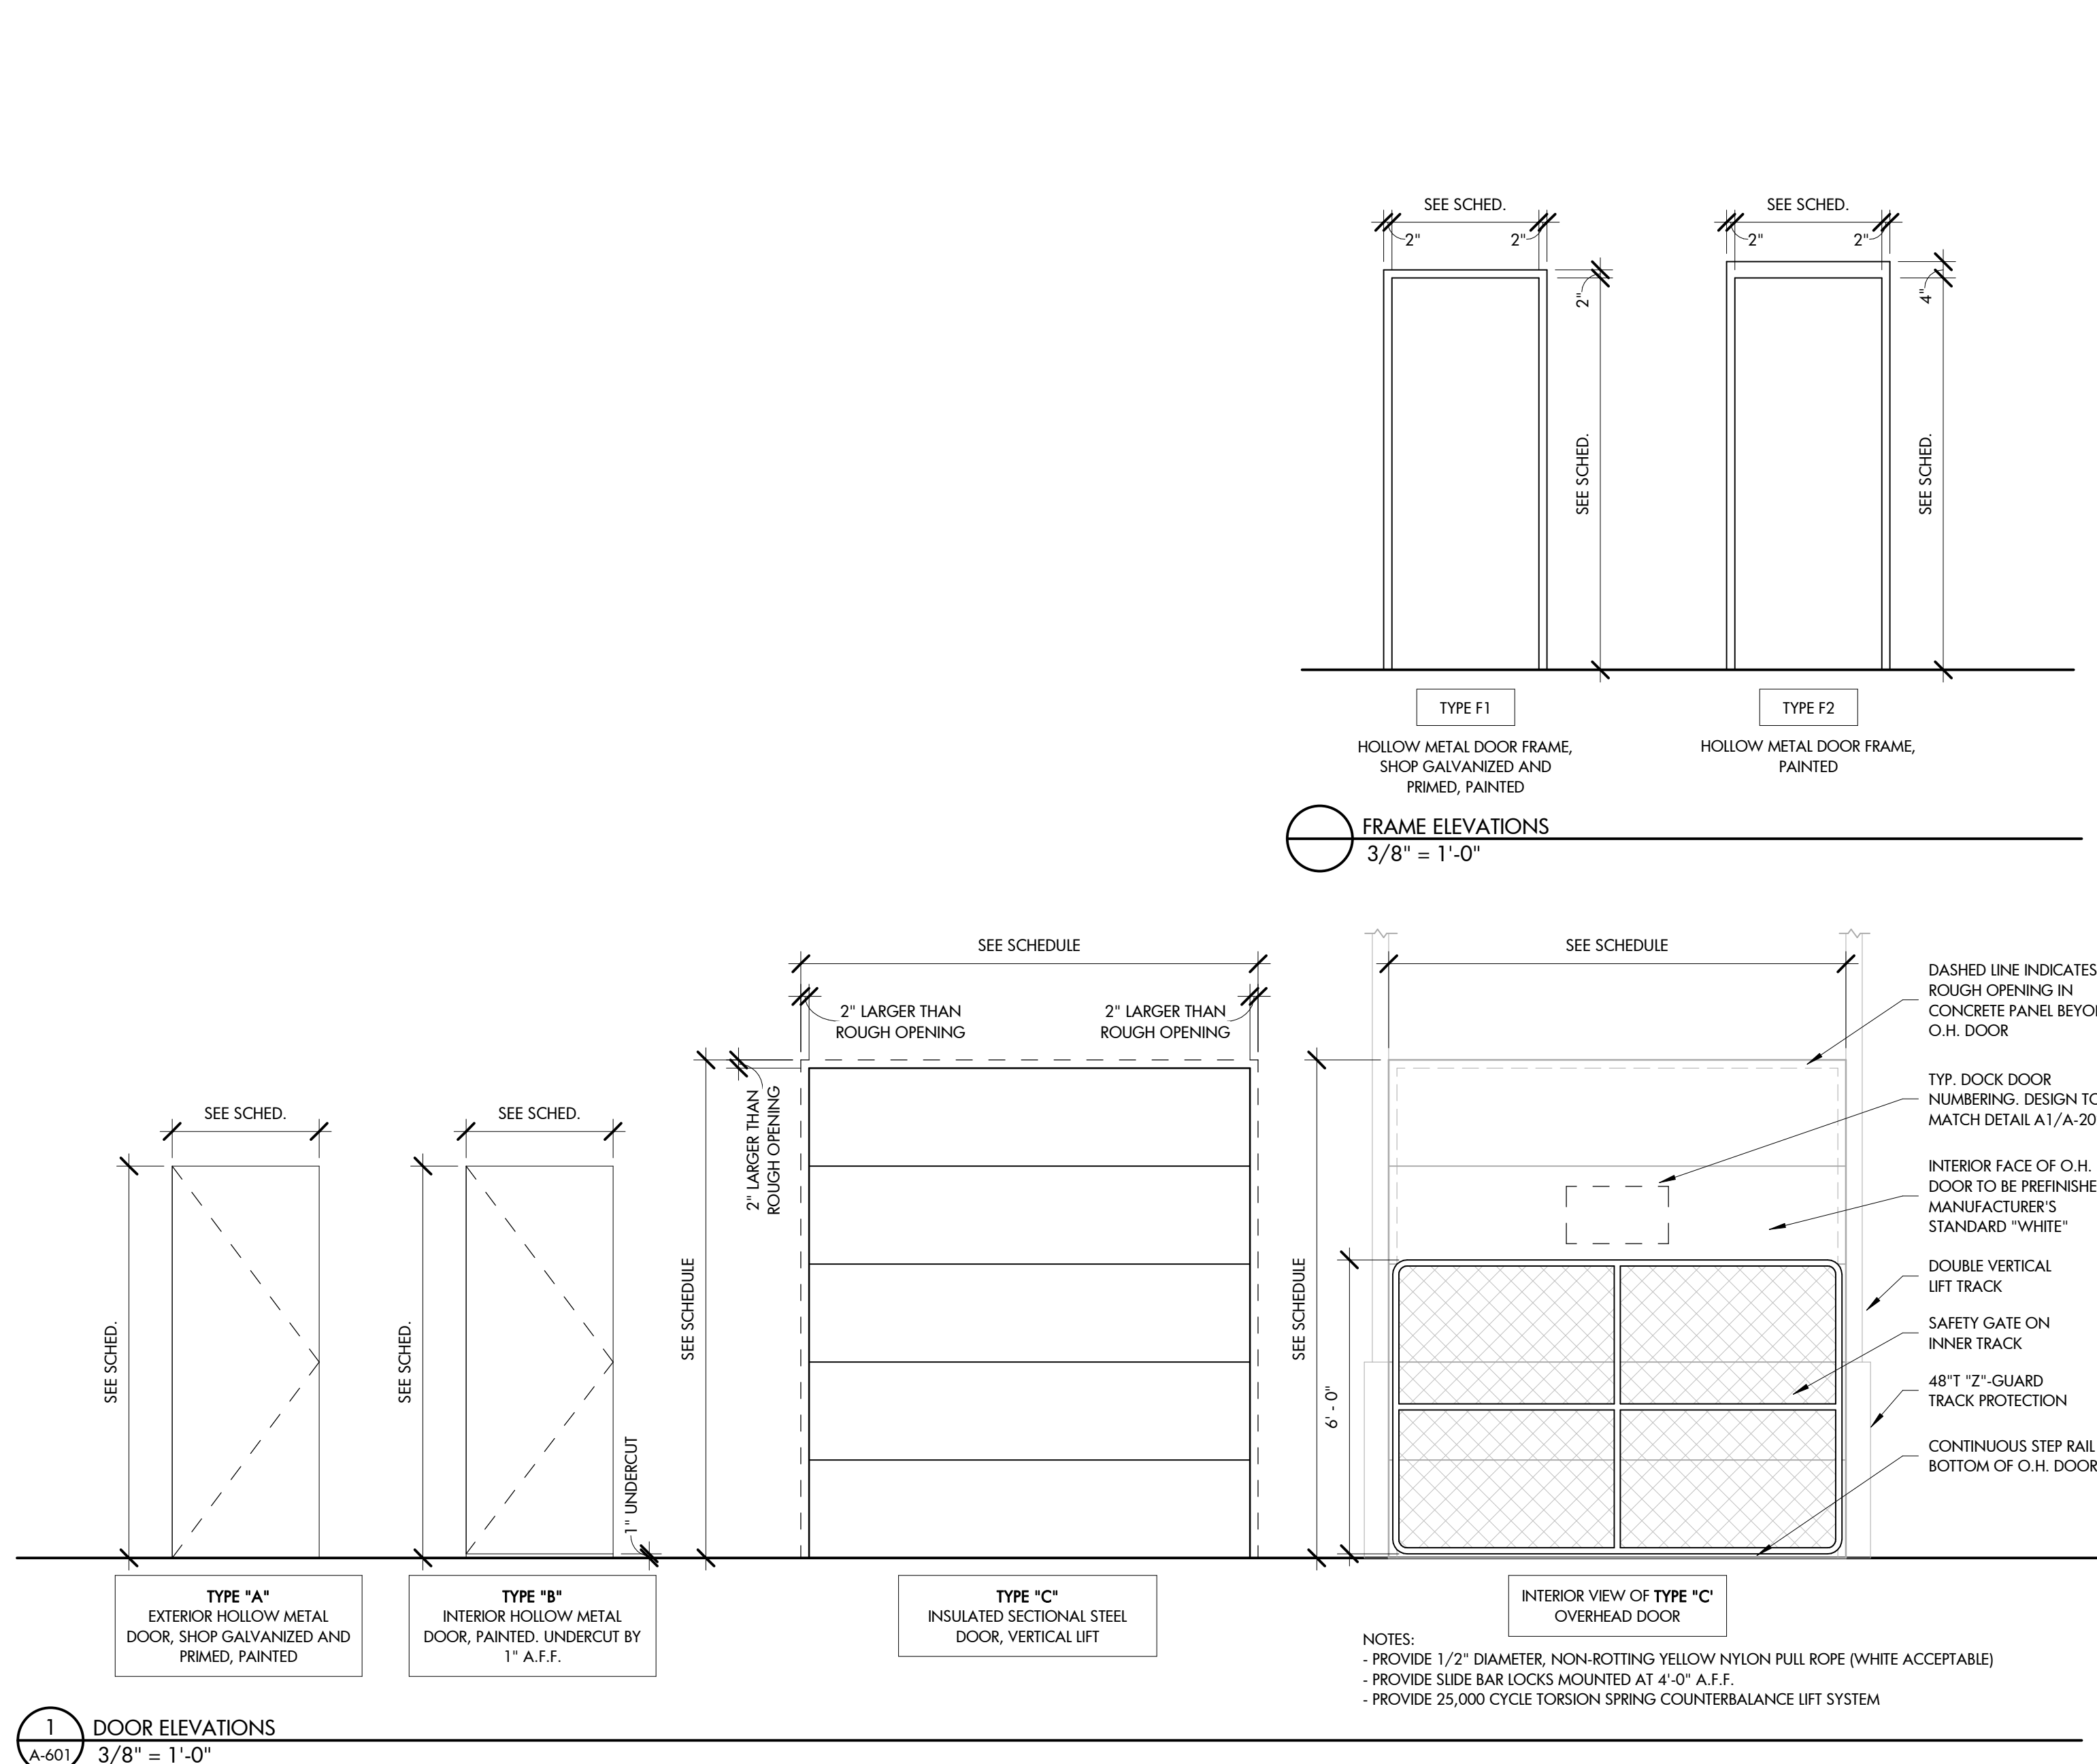

CLIENT

ROOMS TO GO

201 Rooms to Go Way

Dunn, NC 28334

(910) 292-3505

DRAWING TITLE

DOOR & WINDOW SCHEDULES

REVISIONS

NUMBER	DESCRIPTION	DATE
1	BID DOCUMENTS	02/02/21

DRAWN BY

KRT

CHECKED BY

BDG

DATE ISSUED


12/18/23

OF


A-601

FINISH LEGEND			
NO.	MATERIAL	SPECIFICATION	NOTES
FLOORING			
SC-1	SEALED CONCRETE	N/A	TROWELED FINISH FOR STANDARD ABRASION
CT-1	CERAMIC TILE	MANUFACTURER: AMERICAN OLEAN STYLE: SHADOW BAY COLOR: SEA GRASS SIZE: 12"x12"	- STACK BOND - GROUT COLOR TO MATCH MAPEI-BLACK (10) AND IS TO BE SEALED
	CERAMIC TILE (OPTION 2)	MANUFACTURER: DALTILE STYLE: CONTINENTAL SLATE COLOR: CS52 SIZE: 12"x12"	
	CERAMIC TILE (OPTION 3)	APPROVED EQUAL BY OWNER	
BASE			
TB-1	TILE BASE	MANUFACTURER: AMERICAN OLEAN STYLE: SHADOW BAY COLOR: SEA GRASS (543C9) SIZE: 3"x12"	
	TILE BASE (OPTION 2)	MANUFACTURER: DALTILE STYLE: CONTINENTAL SLATE COLOR: CS52 SIZE: 3"x12"	
	TILE BASE (OPTION 3)	APPROVED EQUAL BY OWNER	
RB-1	RESILIENT BASE	MANUFACTURER: JOHNSONITE STYLE: DC-80 COLOR: FAWN SIZE: 4" COVE	
PAINT			
PT-1	GENERAL PAINT	MATCH GUDDEN 40Y75/084 "SEED PEARL"	COLOR USED ON ALL INTERIOR WALLS, UNLESS NOTED OTHERWISE (U.N.O.)
PT-2	DOORS AND FRAMES	MATCH GUDDEN 30Y80/104 "BUFFY"	COLOR USED ON ALL INTERIOR DOORS AND FRAMES AND INTERIOR SIDE OF EXTERIOR PERSONNEL DOORS
PT-3	MISC. METALS	TRAFFIC YELLOW 2008B	COLOR FOR MISCELLANEOUS METALS TO BE PAINTED "YELLOW"
- EPOXY PAINT TO BE USED ON ALL INTERIOR CMU WALLS AND TO HAVE A GLOSS FINISH. PROVIDE (1) COAT SHERWIN WILLIAMS "TILE-CLAD II" EPOXY PRIMER AND (2) COATS OF "TILE-CLAD II" EPOXY FINISH.			
SPECIALTY			
FRP-1	FIBERGLASS REINFORCED PANELING	N/A	

GENERAL FINISH NOTES	
A.	ALL WAREHOUSE BUILDING COLUMNS TO BE SHOP PRIMED MANUFACTURER'S STANDARD GREY. REFER TO FINISH FLOOR PLAN FOR COLUMNS TO BE PAINTED YELLOW TO 25' A.F.F. - REFER TO LIFE SAFETY PLAN (SHEET G-101) FOR COLUMNS TO RECEIVE REFLECTIVE TAPE IDENTIFYING FIRE EXTINGUISHER LOCATIONS.
B.	ALL WAREHOUSE ROOF FRAMING MEMBERS TO BE SHOP PRIMED MANUFACTURER'S STANDARD GREY.
C.	UNDERSIDE OF WAREHOUSE ROOF DECK TO BE SHOP PRIMED MANUFACTURER'S STANDARD WHITE.
D.	ALL FIRE SPRINKLER PIPING BELOW 25' A.F.F. ARE TO BE PAINTED OSHA SAFETY RED.
E.	ALL WELD EMBEDS ARE TO BE FIELD PAINTED GREY TO MATCH STEEL FABRICATOR'S SHOP PRIMER (i.e. JOISTS AND GIRDER SEATS, PANEL TO PANEL CONNECTIONS, ETC.)
F.	EXTERIOR FACES OF DOCK PIT LEVELERS, DOCK CHANNELS AND BUMPER ANGLES TO BE FIELD PAINTED PT-5. REFERENCE EXTERIOR ELEVATION SHEETS FOR ADDITIONAL INFORMATION.
G.	AT TILE TO CONCRETE FLOOR TRANSITIONS, USE AN ANNOZIZED ALUMINUM TRANSITION STRIP. - BASIS OF DESIGN TO BE GENOTEK, CODE 660 OR OWNER APPROVED EQUAL.
H.	INTERIOR FINISH MATERIALS SHALL HAVE FLAME SPREAD RATINGS IN COMPLIANCE WITH THE 2018 NORTH CAROLINA BUILDING CODE.
I.	NO BASE MATERIAL REQUIRED AT WAREHOUSE FACING SIDE OF WALLS, TYP.
J.	REFERENCE REFLECTED CEILING PLANS FOR CEILING HEIGHTS.
K.	ALL EXPOSED INTERIOR AND EXTERIOR GAS LINES SHALL BE PAINTED.

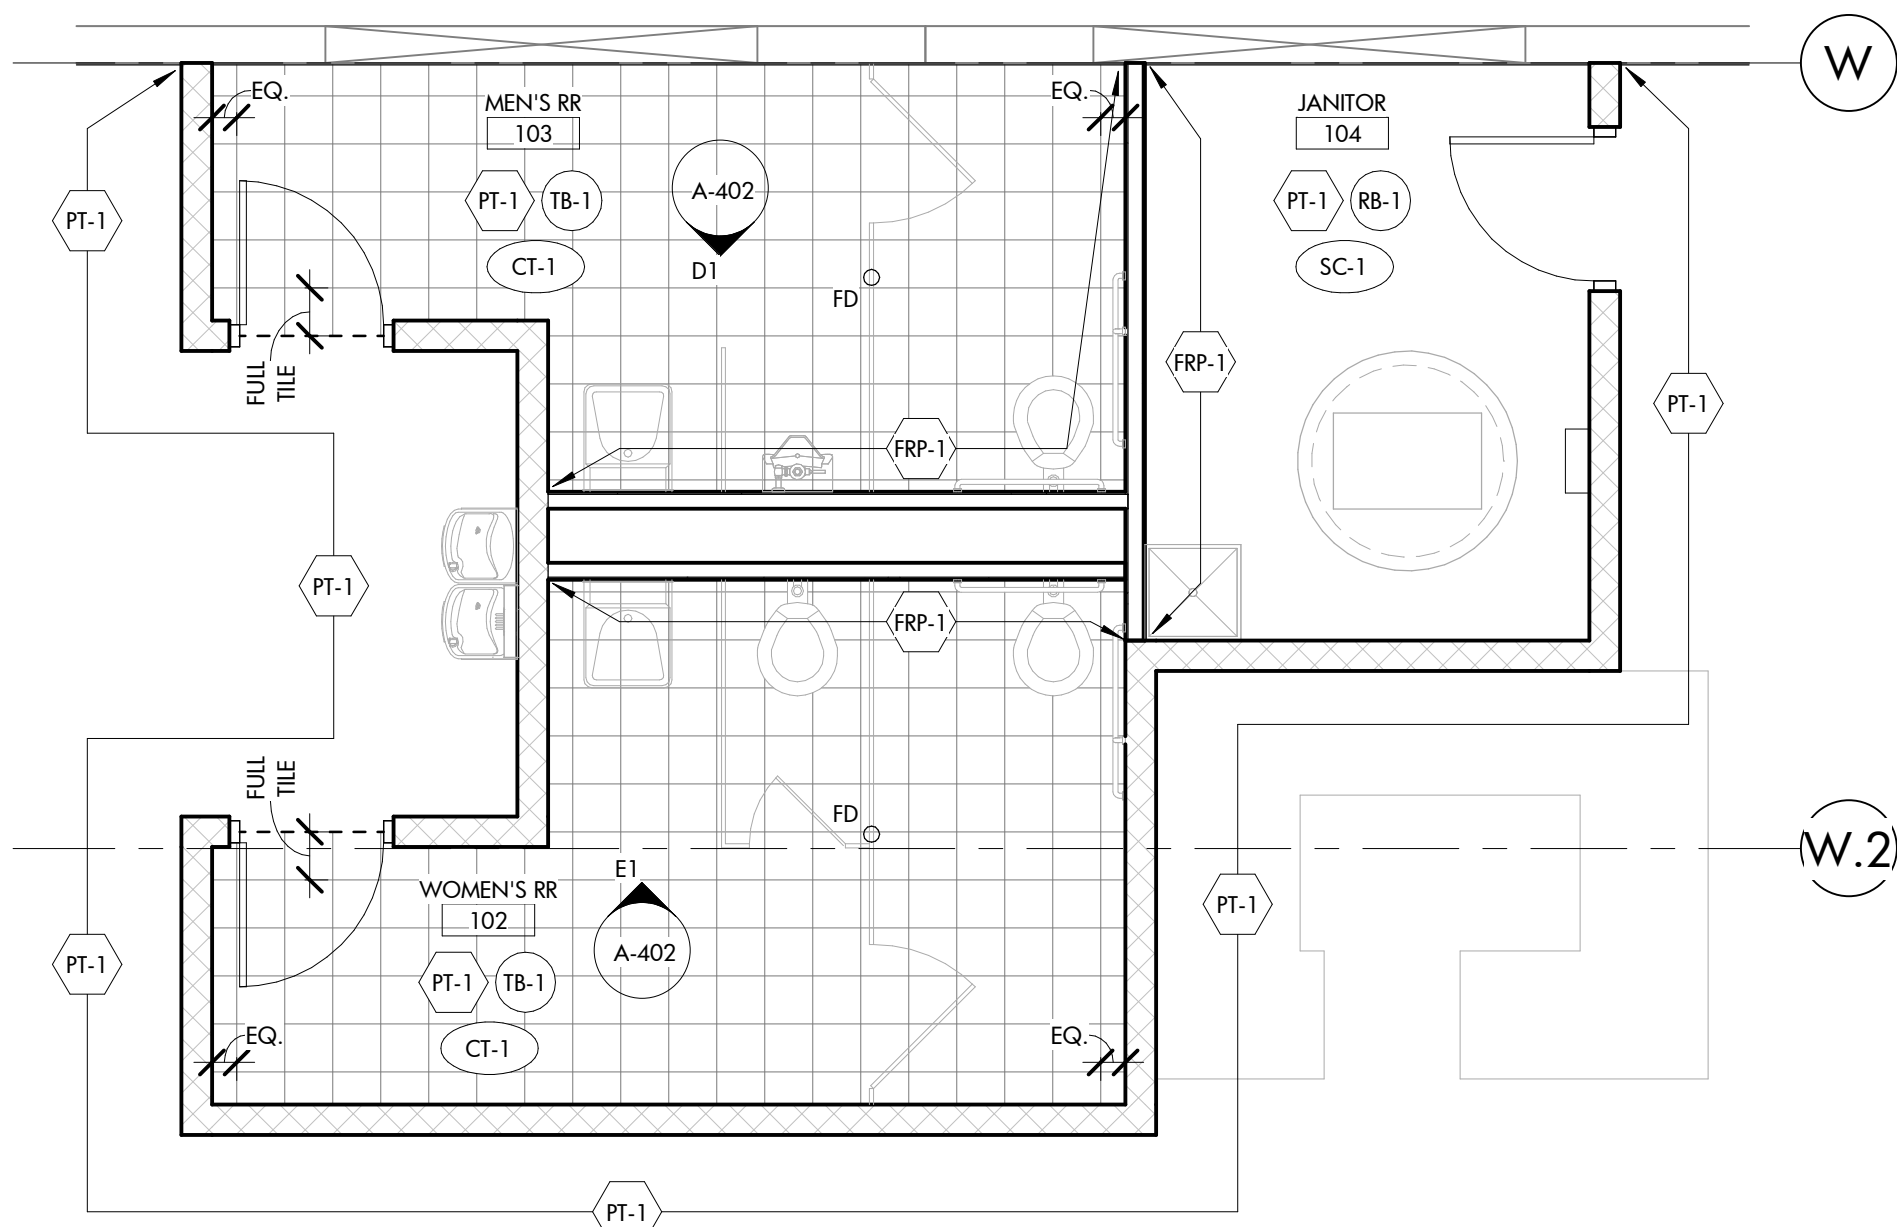

A1 ENLARGED RESTROOM FINISH PLAN
AF-101 1/4" = 1'-0"

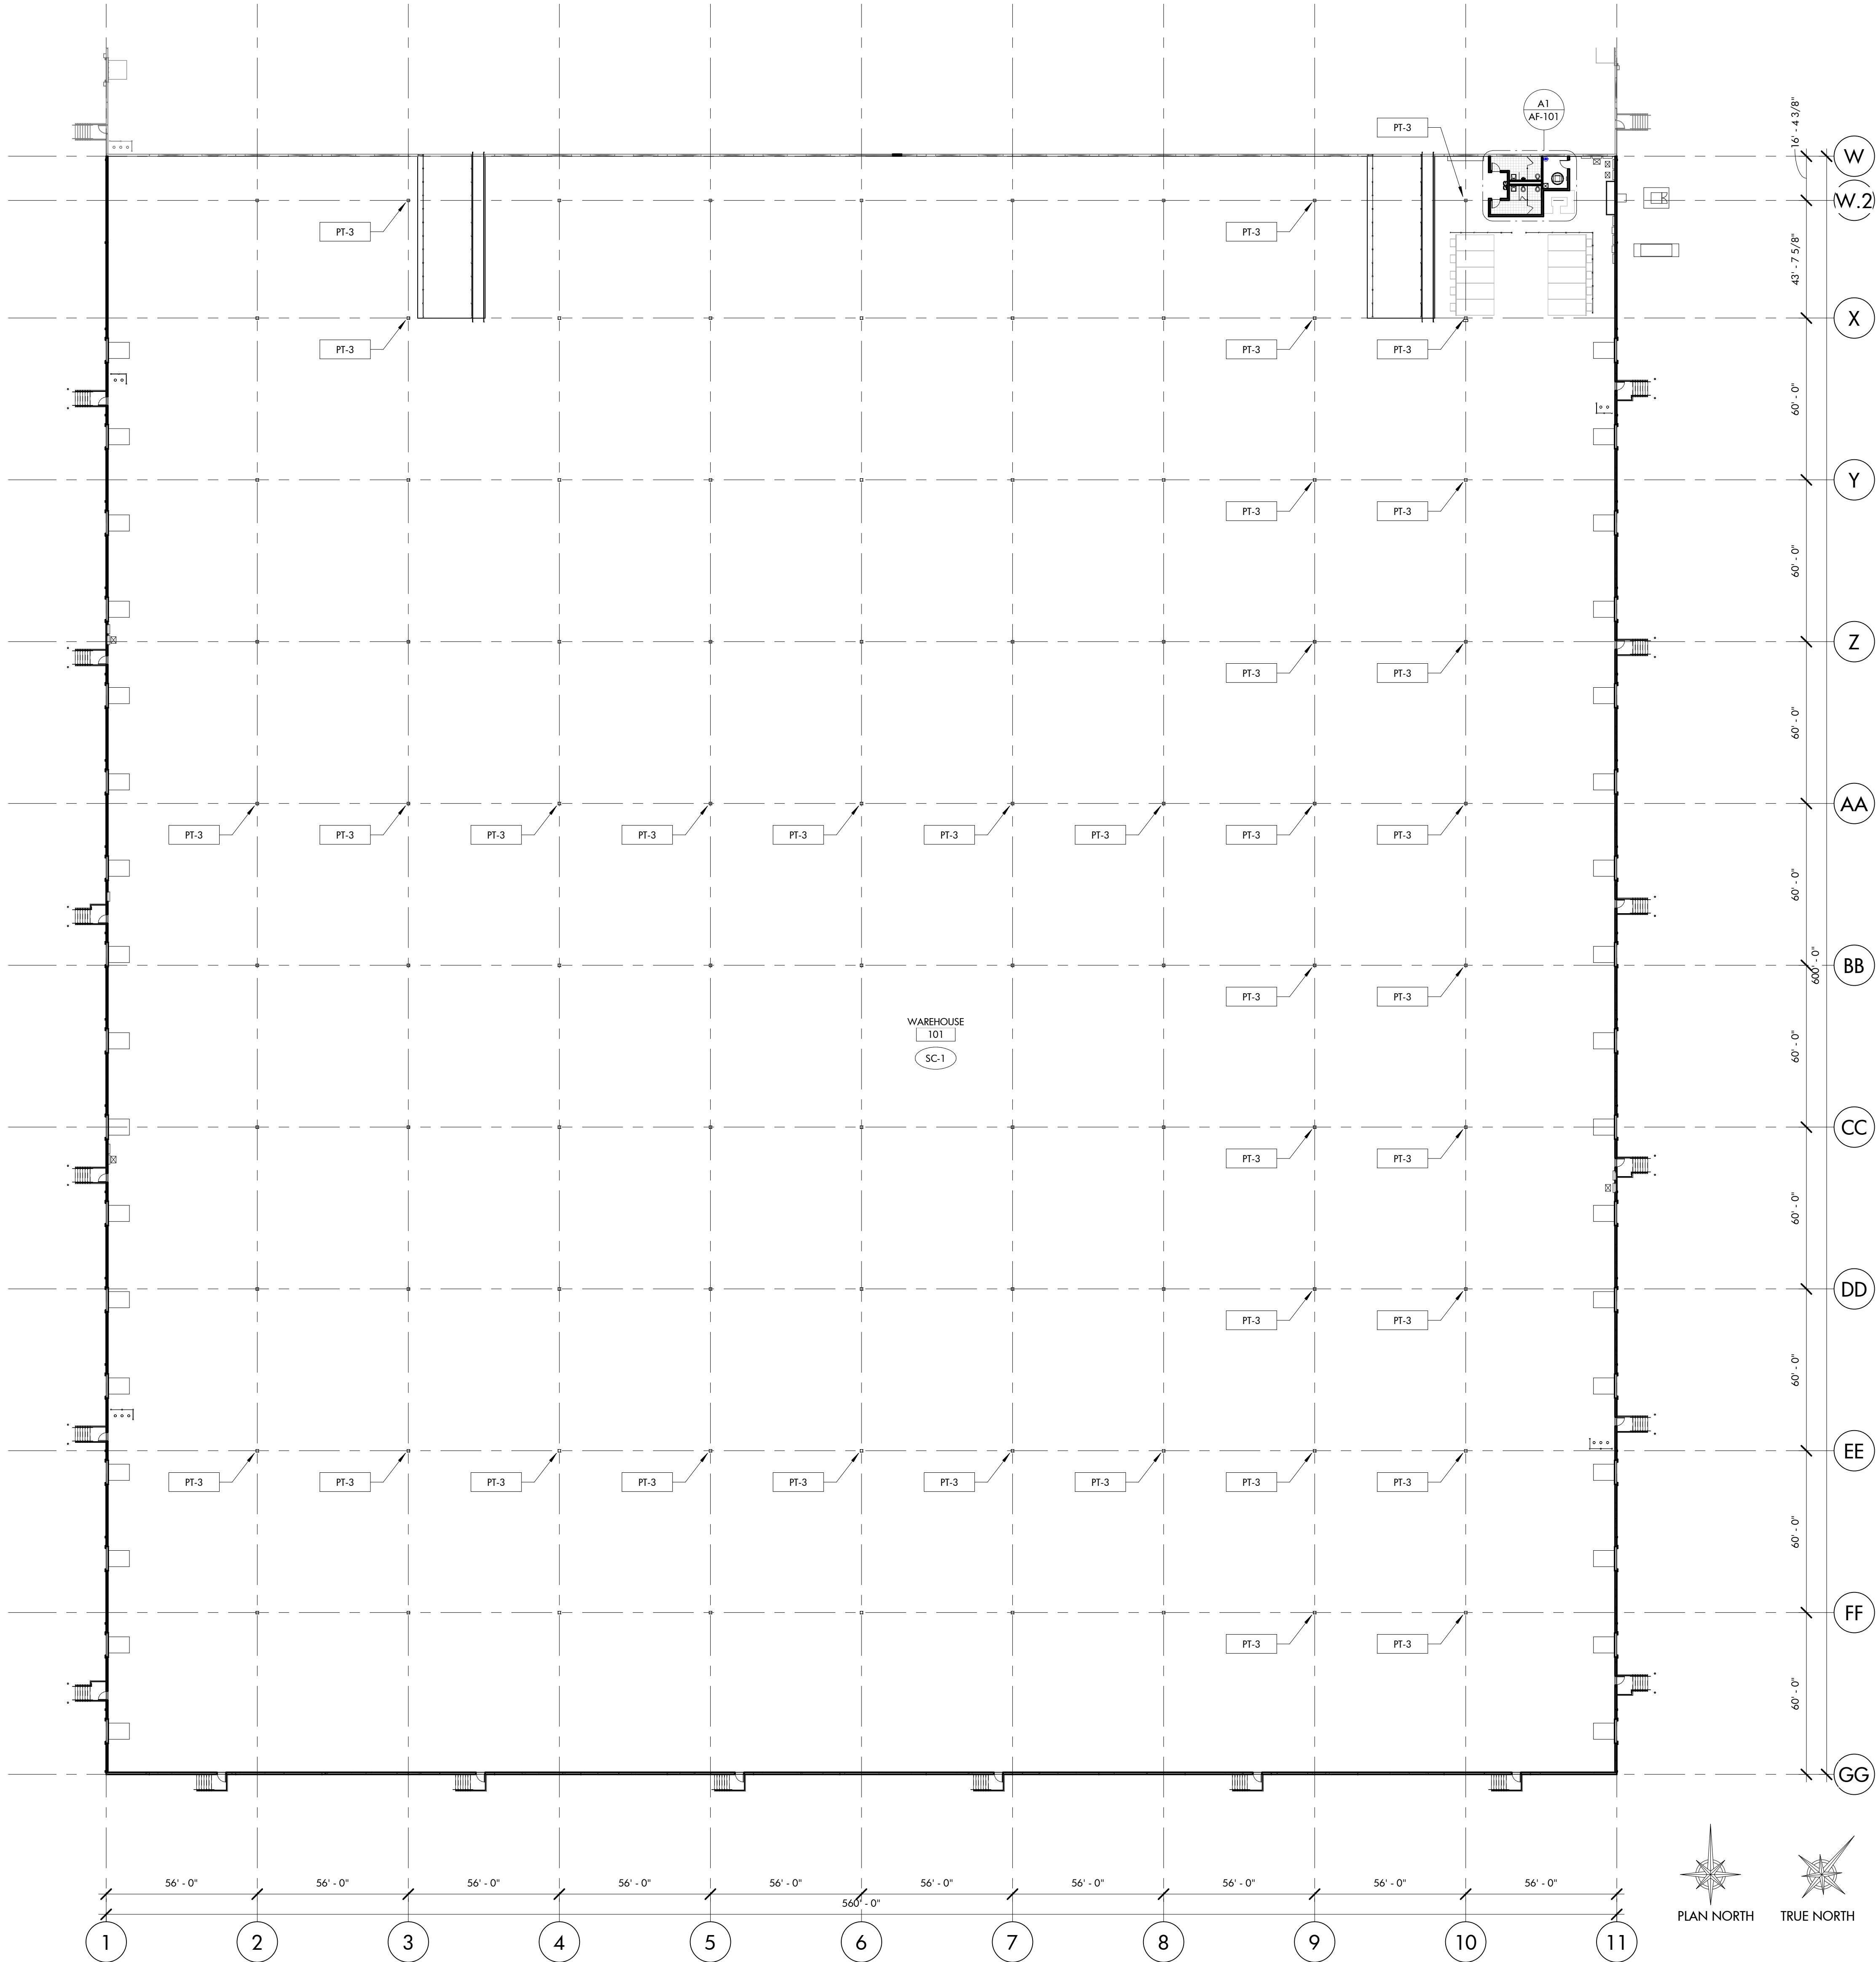


A3 PHASE II EXPANSION FINISH FLOOR PLAN
AF-101 1" = 30'-0"



PROJECT 288-000-000
**ROOMS TO GO -
PHASE II
EXPANSION**
901 Rooms to Go Way
Dunn, NC 28334



BNK
BASS | NIXON | KENNEDY
CONSULTING ENGINEERS
ENGINEERING FIRM NUMBER: C-0110
6310 CHAPEL HILL ROAD, SUITE 250
RALEIGH, N.C. 27607
P.919.851.4422 BNKINC.COM

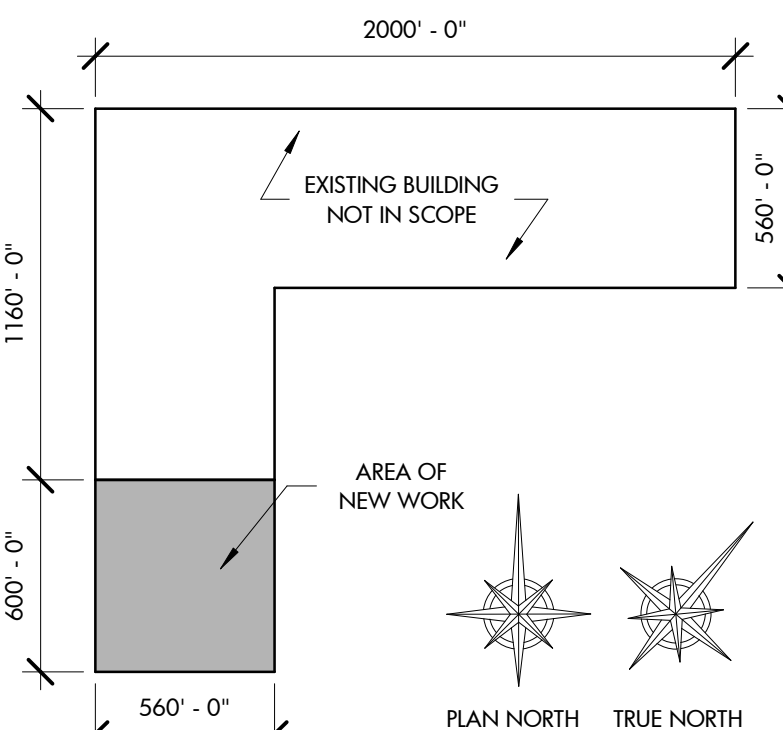

KEY PLAN
NTS
CLIENT

ROOMS TO GO

901 Rooms to Go Way
Dunn, NC 28334
(910) 292-3505

DRAWING TITLE
PHASE II EXPANSION FINISH FLOOR PLAN

REVISIONS		
NUMBER	DESCRIPTION	DATE

DRAWN BY **KRT**
CHECKED BY **BDG**
DATE ISSUED **12/18/23** OF

AF-101